




R SECTION - SUPERNATANT AND SLUDGE LINES
WP-M9106 1:50

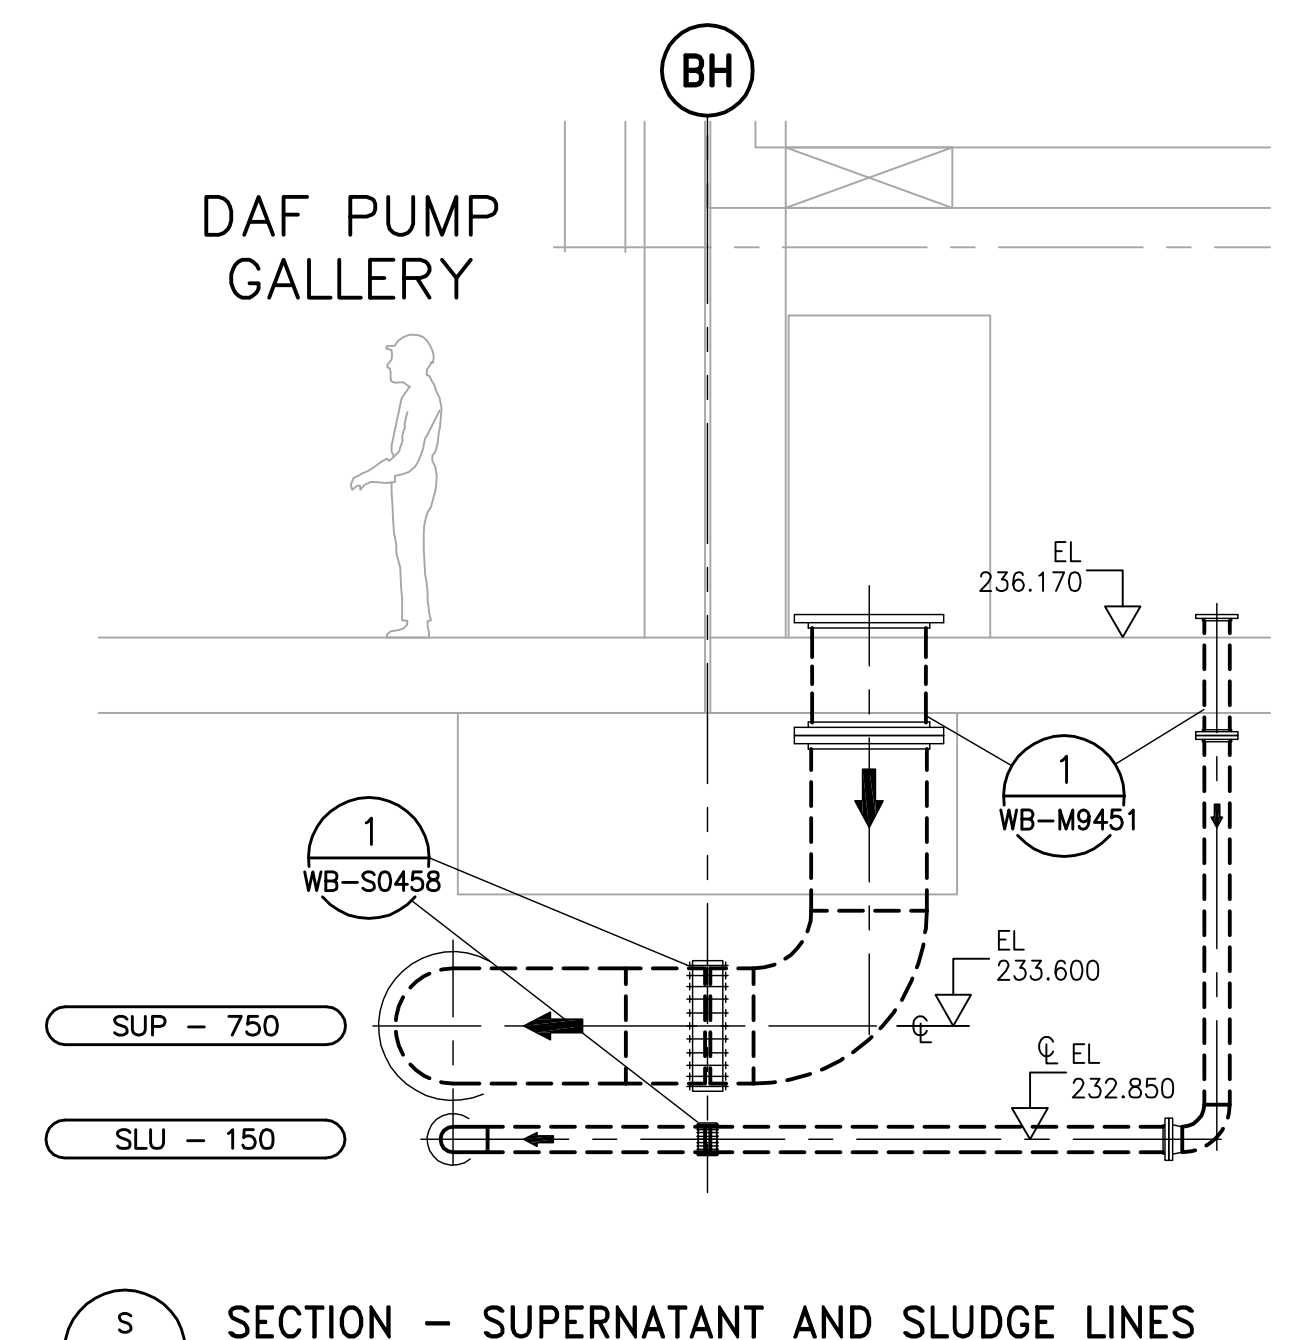


S SECTION - SUPERNATANT AND SLUDGE LINES
WP-M9106 1:50

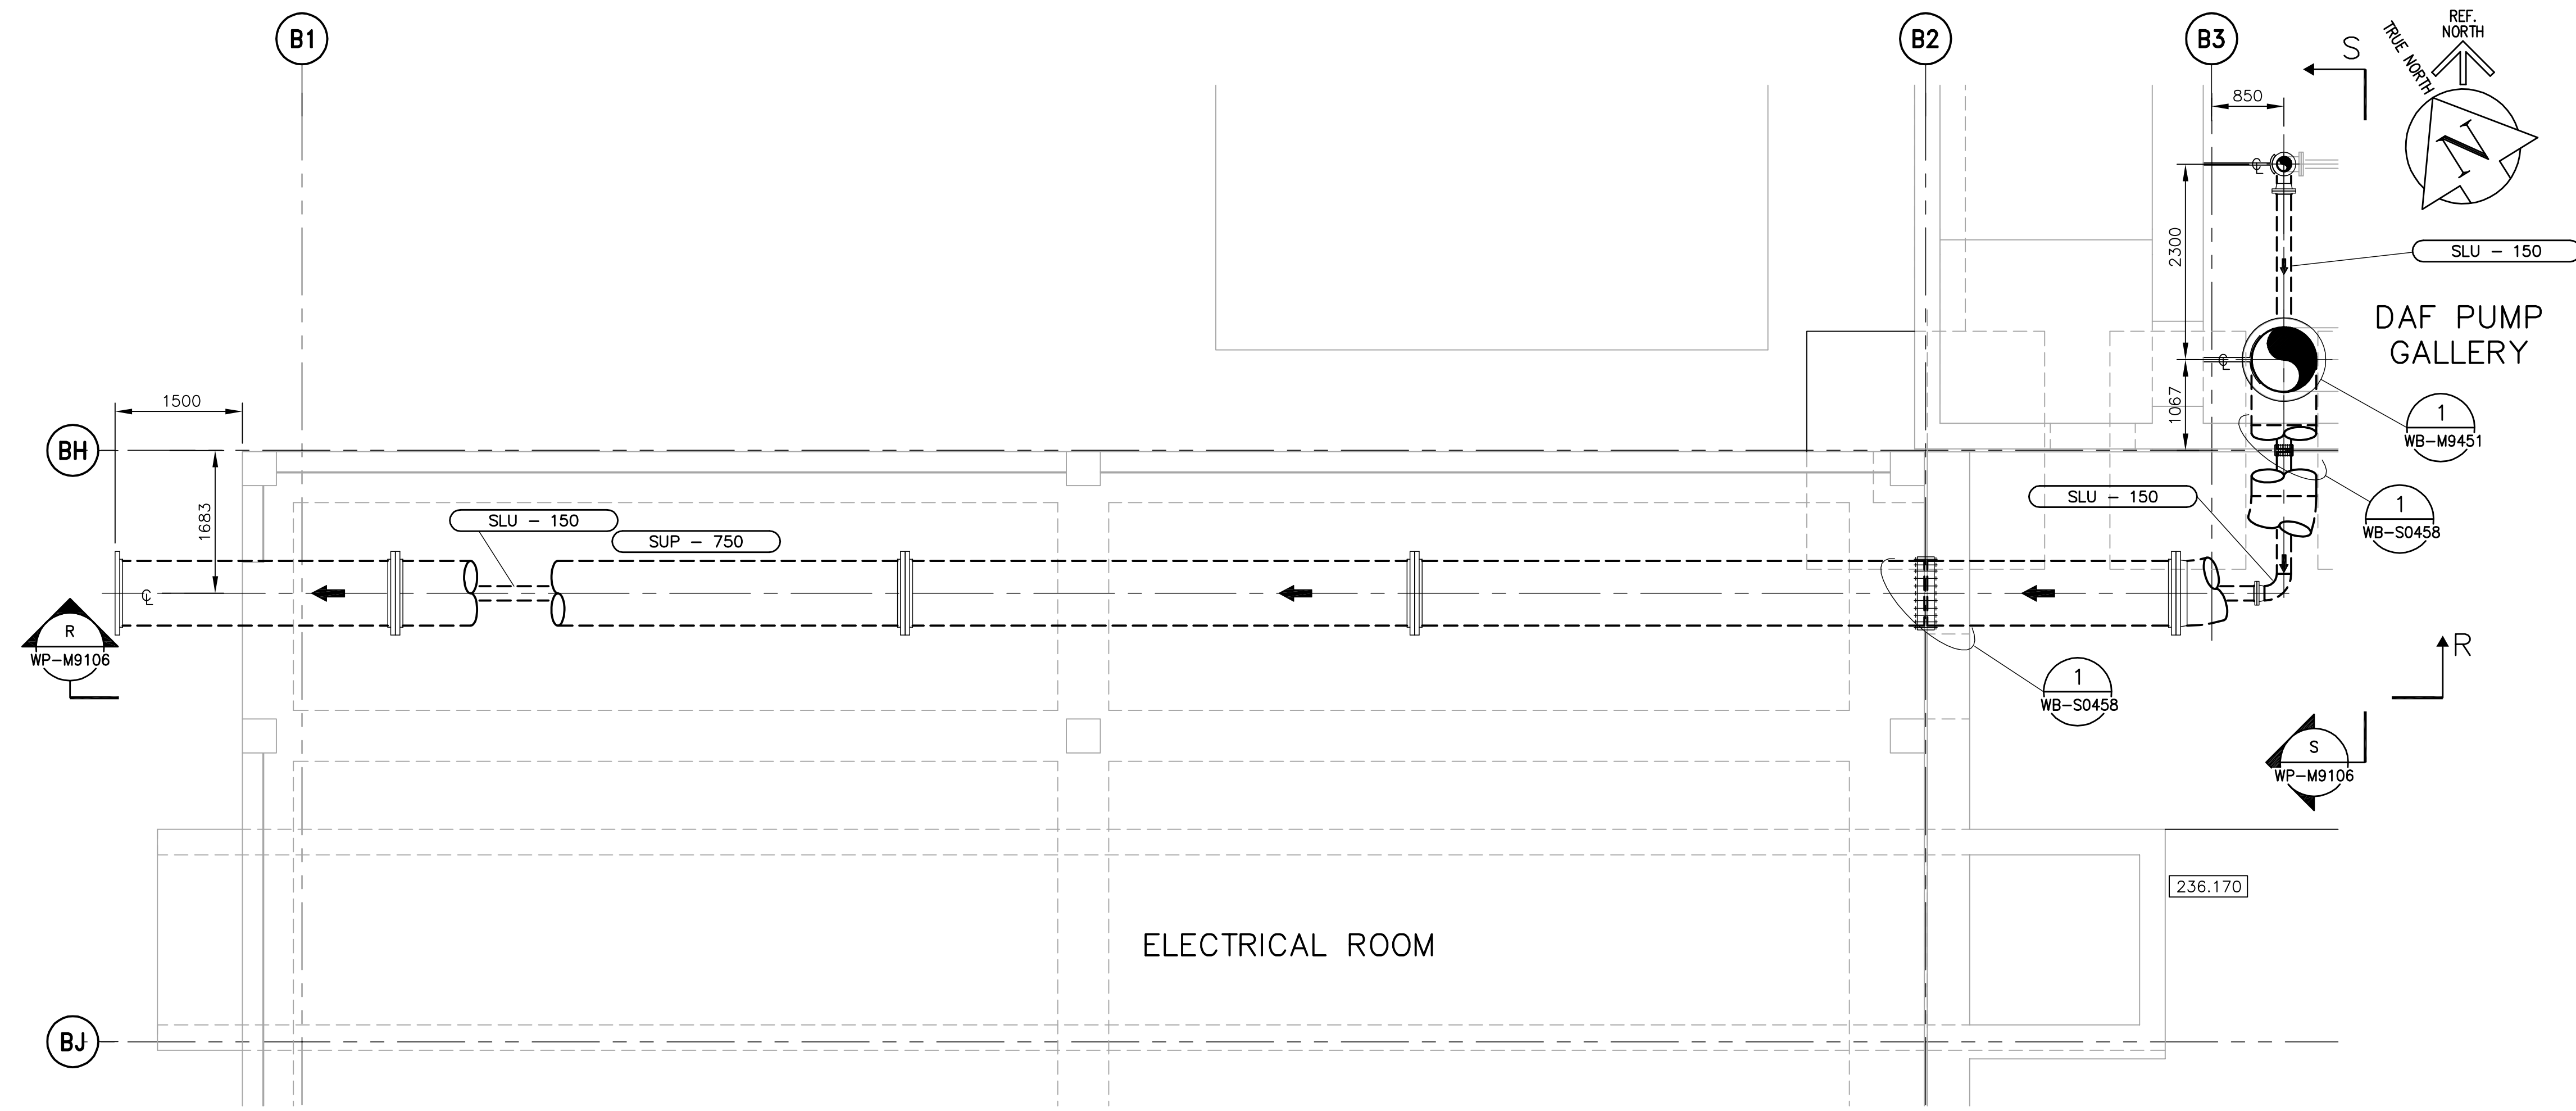

22 FIRST FLOOR PLAN - SUPERNATANT AND SLUDGE LINES
WP-M9106 1:50

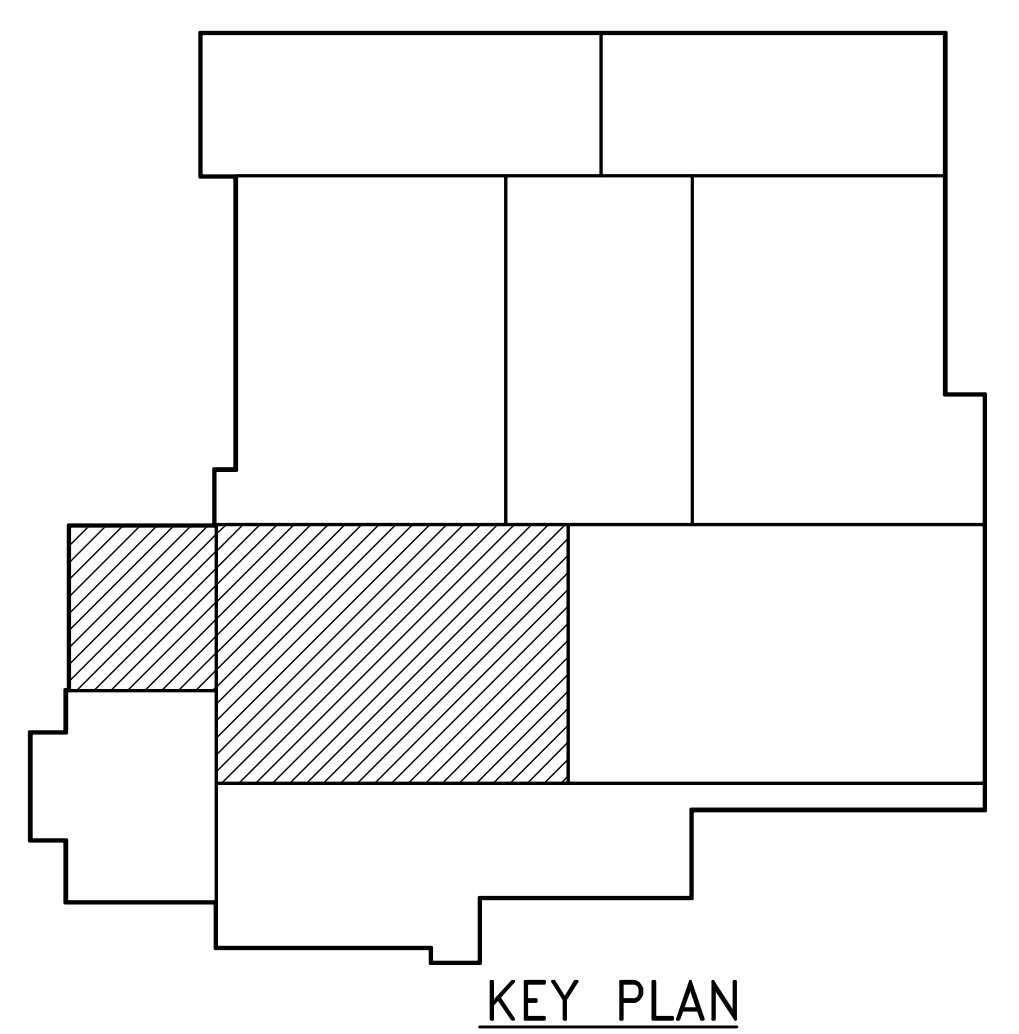

KEY PLAN

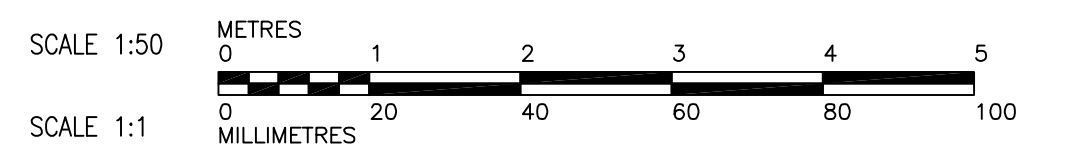

 Certificate of Authorization Earth Tech Canada Inc. No. 730 Expiry: April 30, 2006	 Frederickson Cooper ARCHITECTS	 A Tyco International Ltd. Company	ENGINEER'S SEAL	 THE CITY OF WINNIPEG WATER AND WASTE DEPARTMENT ENGINEERING DIVISION		
			DESIGNED BY: KAS		CHECKED BY: SRB	ORIGINAL SIGNED BY: S.R. BILEVICIUS
			DRAWN BY: PL		APPROVED BY: DJT	2006/02/07
			SCALE: AS SHOWN		RELEASED FOR CONSTRUCTION BY: R. SOROKOWSKI	CONSULTANT DRAWING NO. WP-M9106
B.M. ELEV. NO. REVISIONS DATE BY	00 ISSUED FOR TENDER 06/02/03 PL 01 2005/11/28	2006/02/07	WATER TREATMENT PLANT FLOCCULATION AND DAF FOUNDATIONS AND CONCRETE STRUCTURES PIPE EMBEDS FIRST FLOOR PLAN AND SECTIONS SUPERNATANT AND SLUDGE LINES	CITY FILE NUMBER SHEET OF CITY DRAWING NUMBER 1-0601P-A-M9106-001-000		