

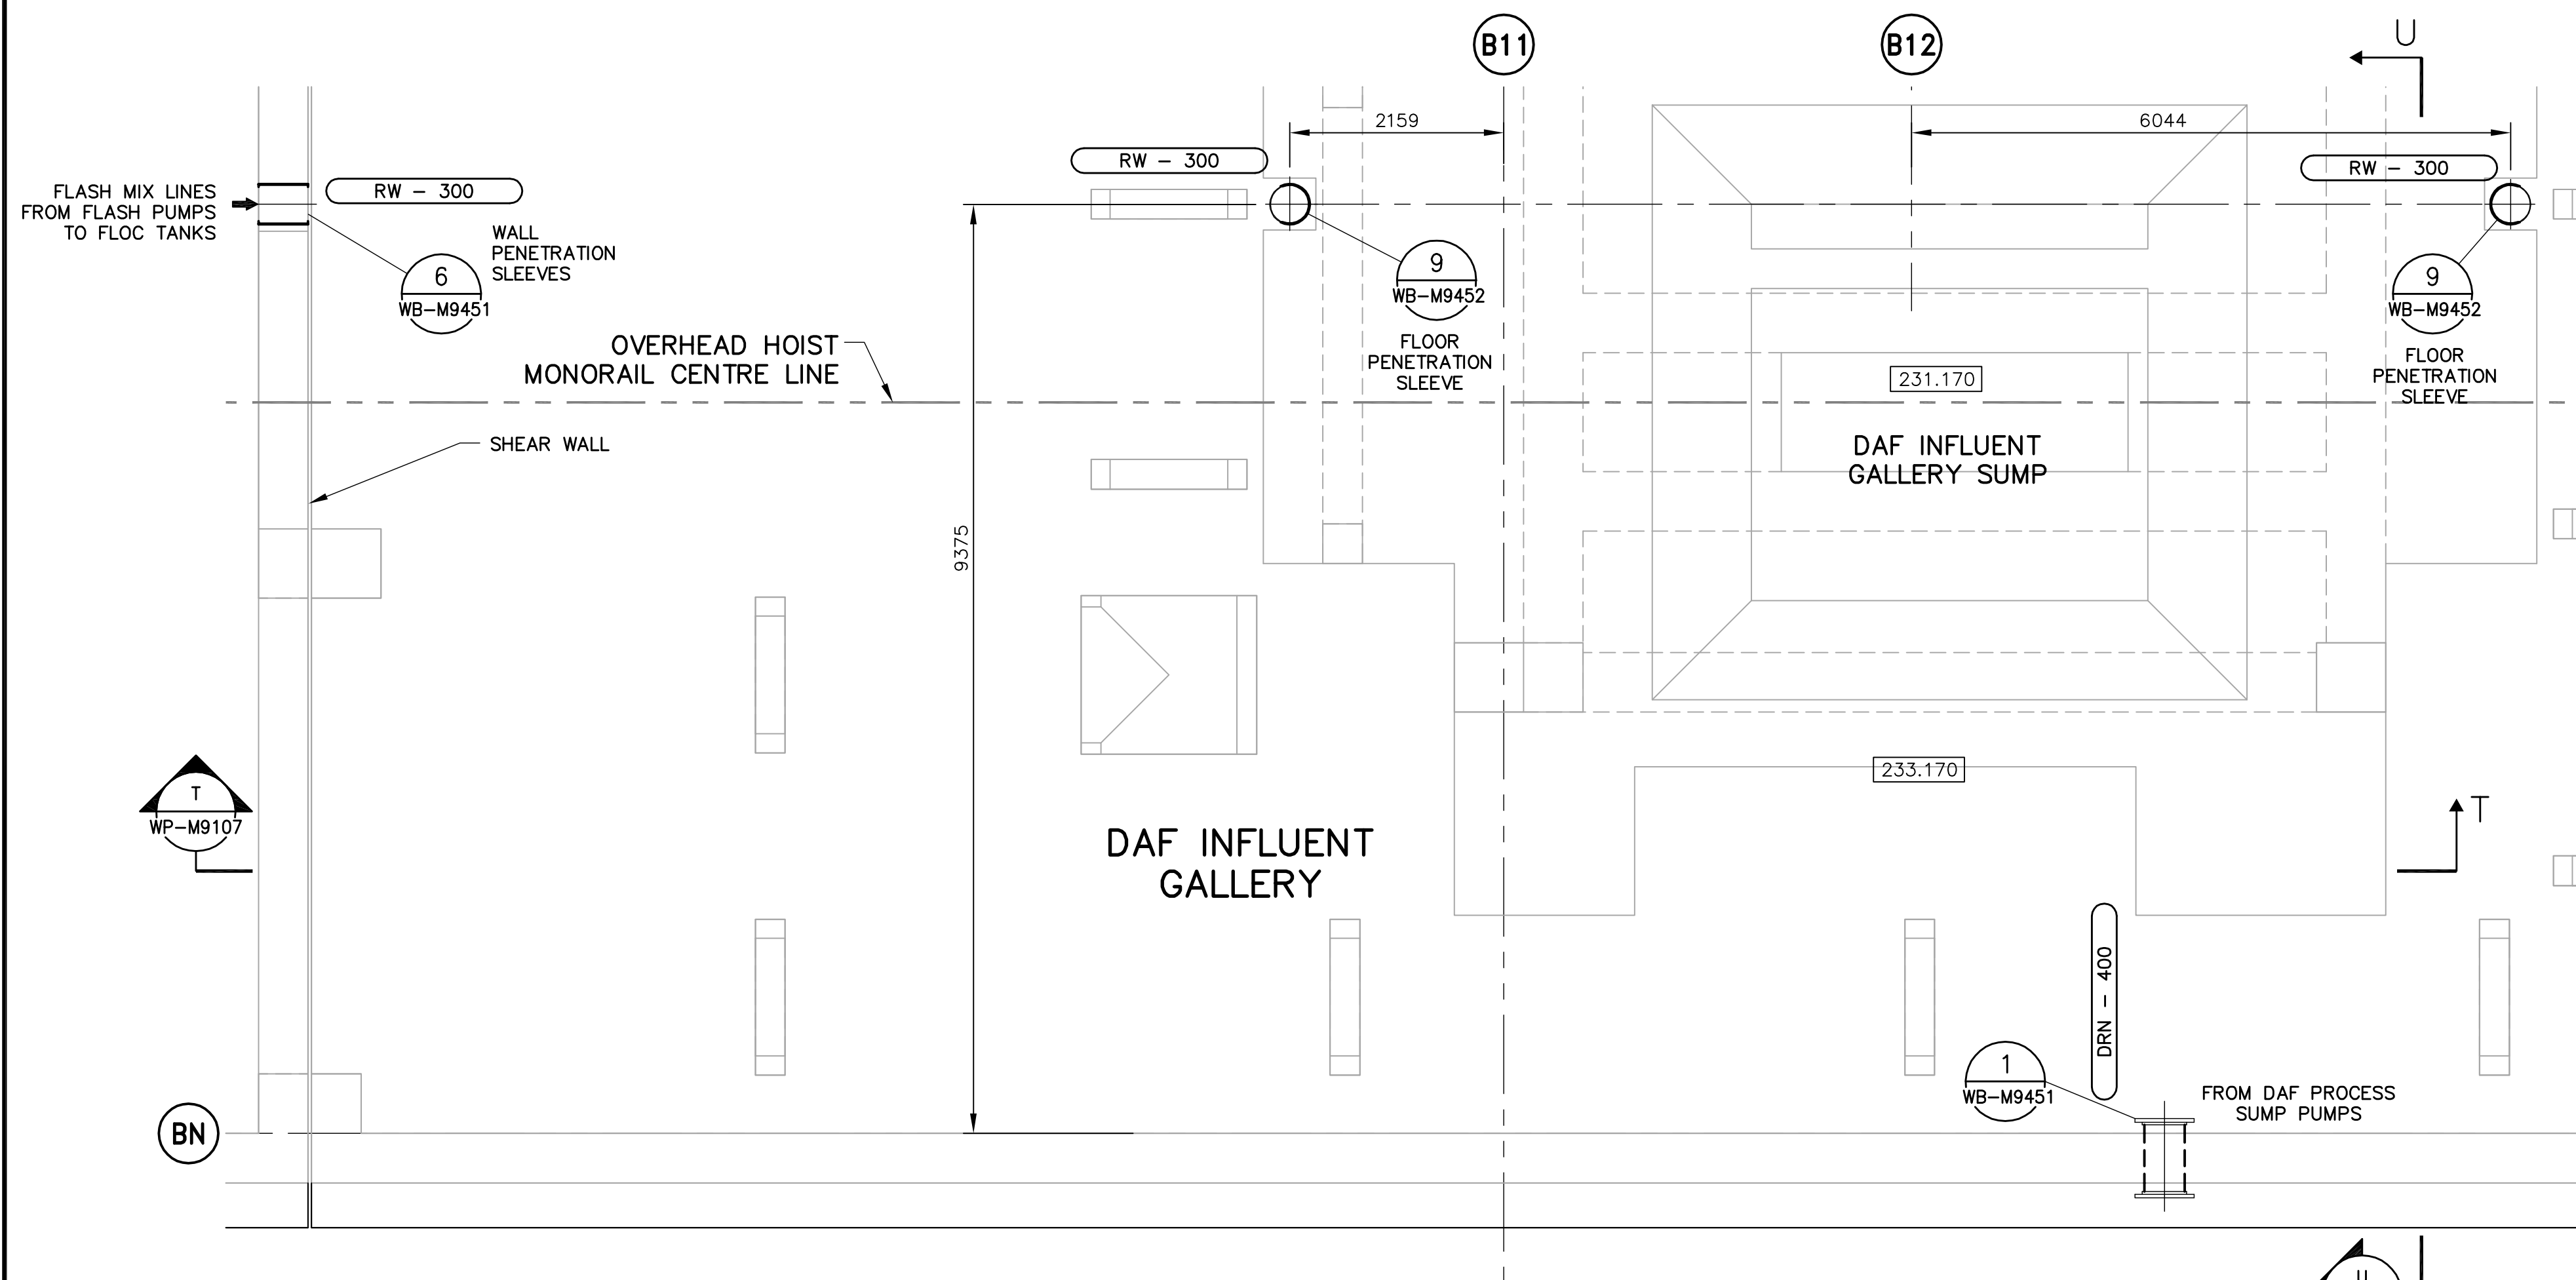


T SECTION - DAF INFLUENT GALLERY SUMP PUMPS
WP-M9107 1:50


U SECTION - DAF INFLUENT GALLERY SUMP PUMPS
WP-M9107 1:50

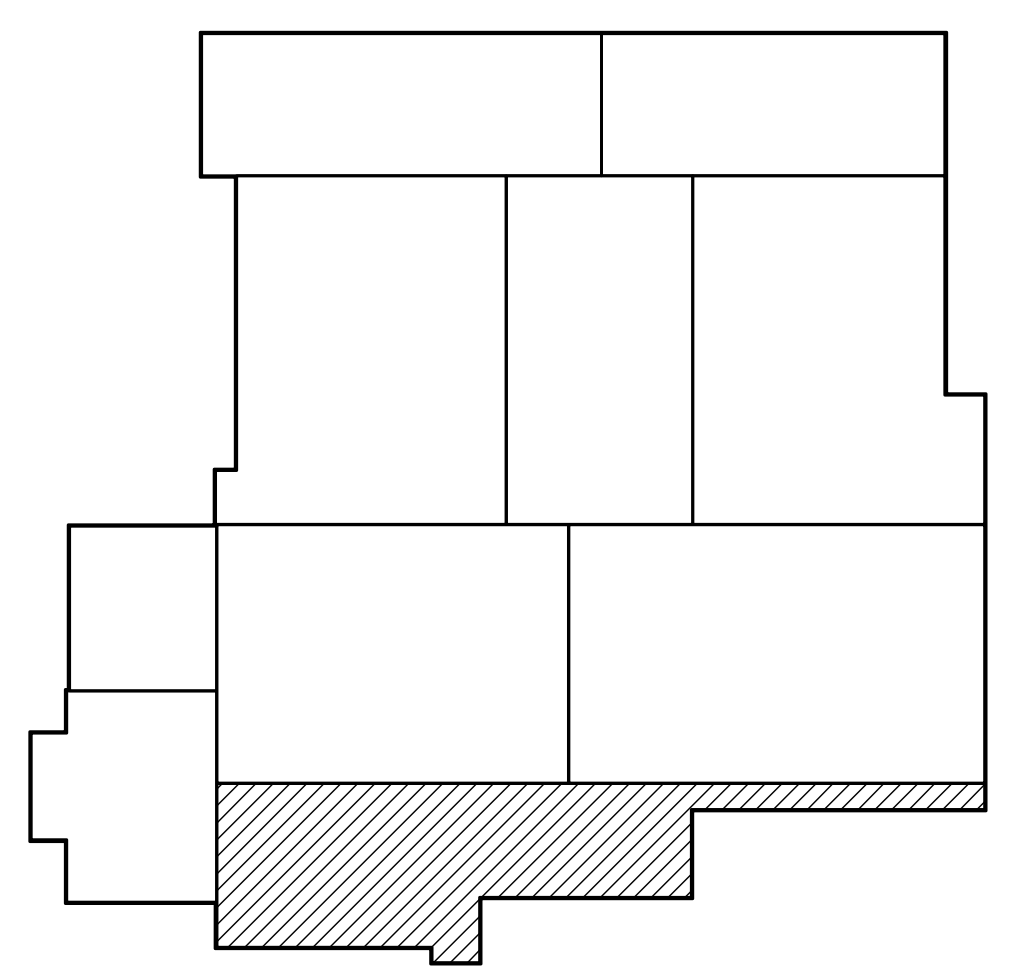

23 FIRST FLOOR PLAN - DAF INFLUENT GALLERY SUMP PUMPS
WP-M9107 1:50

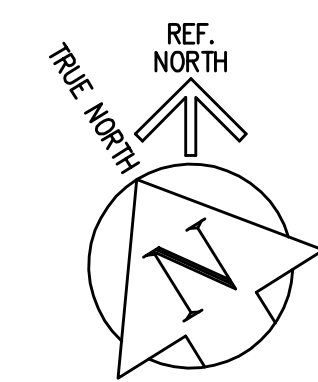

KEY PLAN

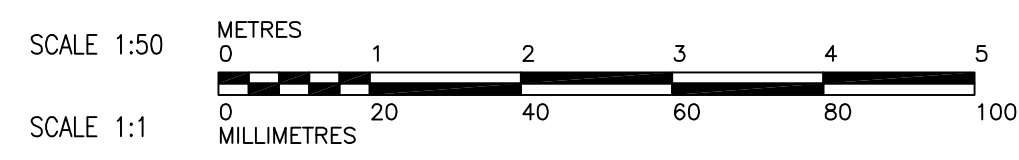

<p>Certificate of Authorization Earth Tech Canada Inc. No. 730 Expiry: April 30, 2006</p>	<p>Frederickson Cooper ARCHITECTS</p>		<p>A Tyco International Ltd. Company</p>		ENGINEER'S SEAL ORIGINAL SIGNED BY S.R. BILEVICIUS 2006/02/07	<p>THE CITY OF WINNIPEG WATER AND WASTE DEPARTMENT ENGINEERING DIVISION</p>
	DESIGNED BY	KAS	CHECKED BY	SRB	CONSULTANT DRAWING NO. WP-M9107	
	DRAWN BY	PL/LC	APPROVED BY	DJT		
	SCALE:	AS SHOWN	RELEASED FOR CONSTRUCTION BY:	R. SOROKOWSKI		
00 ISSUED FOR TENDER	06/02/03	PL				
NO. REVISIONS	DATE	BY	DATE	2005/11/28	DATE	2006/02/07