

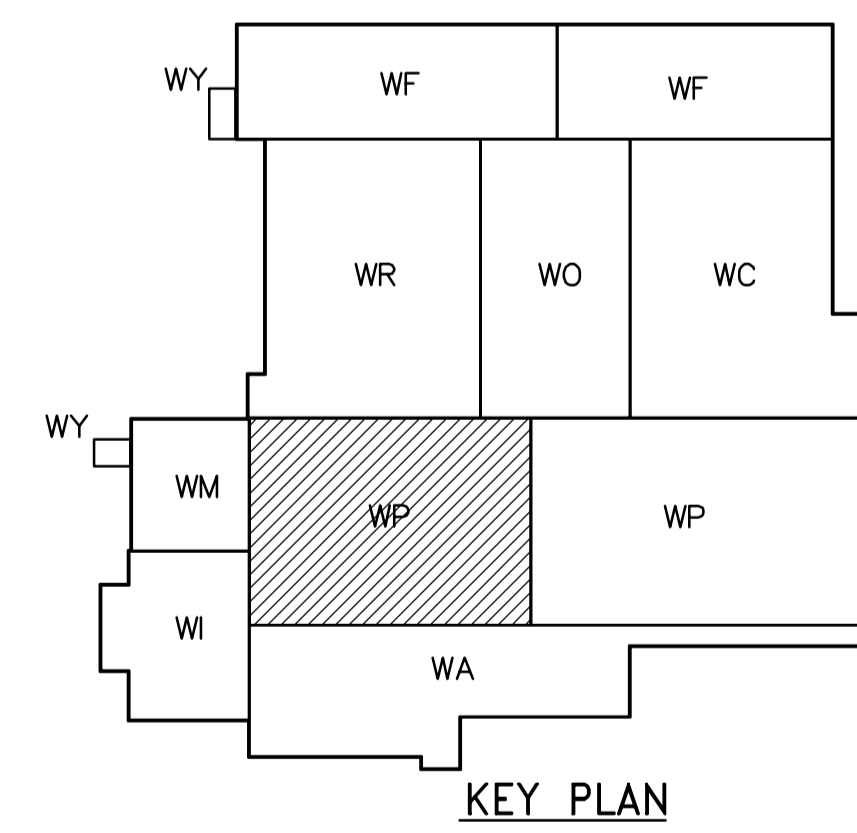
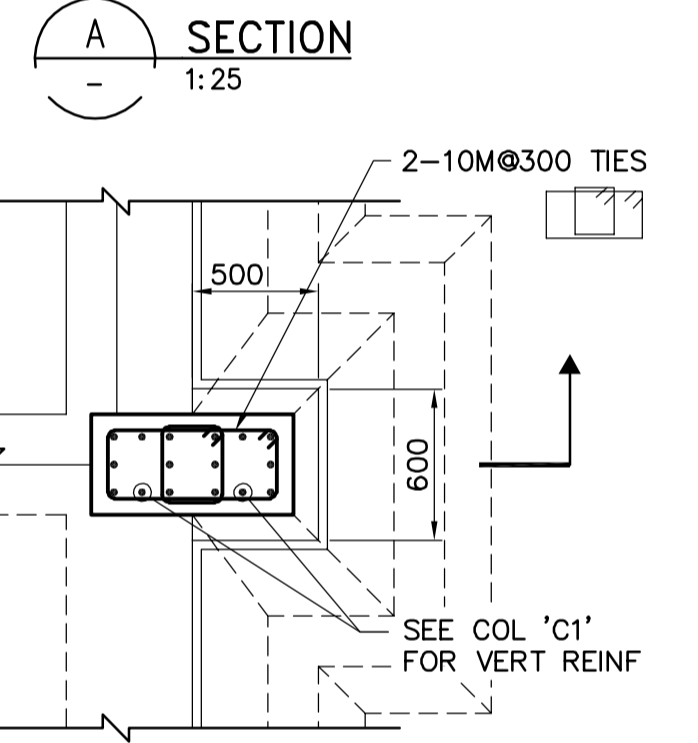


NOTES:
 1. FOR BEAM AND COLUMN SCHEDULE SEE DWG WP-S0515.

REBAR LEGEND:
 ——— TOP BARS
 - - - - - BOTTOM BARS

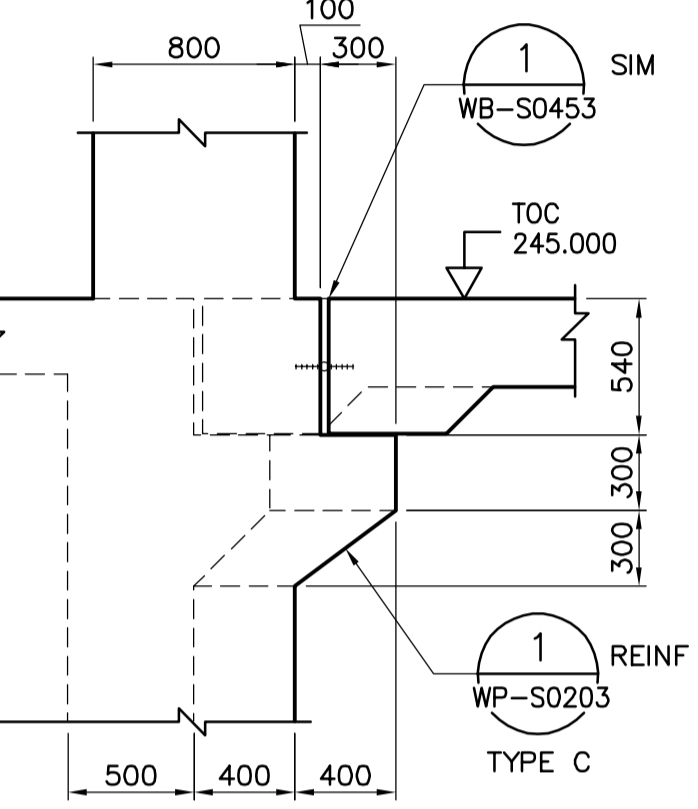

THIRD FLOOR PLAN
 1:100

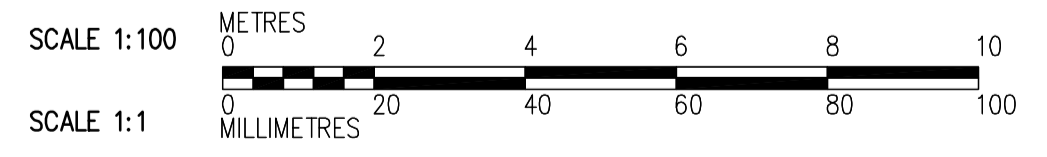

- H WP-S0213/214/215
- G WP-S0211/212
- F WP-S0209/210
- E WP-S0207/208
- D WP-S0205/206
- C WP-S0203/204



B.M. ELEV.			
DESIGNED BY	RZ	CHECKED BY	AP
DRAWN BY	RL	APPROVED BY	DJT
SCALE:	1:100	RELEASED FOR CONSTRUCTION BY:	R. SOROKOWSKI
NO. REVISIONS	00	DATE	2005/06/28
		DATE	2006/02/08

CH2MHILL
 Frederickson Cooper ARCHITECTS

EarthTech
 A Veolia International Ltd. Company

DESIGNED BY: RZ
 CHECKED BY: AP
 DRAWN BY: RL
 APPROVED BY: DJT
 SCALE: 1:100
 RELEASED FOR CONSTRUCTION BY: R. SOROKOWSKI
 DATE: 2005/06/28

ENGINEER'S SEAL
 ORIGINAL SIGNED BY: D. KRUGER
 DATE: 2006/02/06
 CONSULTANT DRAWING NO.: WP-S0131

THE CITY OF WINNIPEG
 WATER AND WASTE DEPARTMENT
 ENGINEERING DIVISION

WATER TREATMENT PLANT
 FLOCCULATION AND DAF
 FOUNDATIONS AND CONCRETE STRUCTURES

STRUCTURAL
 FLOC/DAF AREA 1
 THIRD FLOOR PLAN

CITY FILE NUMBER: _____
 SHEET OF: _____
 CITY DRAWING NUMBER: **1-060P-A-3031-001-00D**