


- NOTES:**
- SEE DWGS WP-S0111 TO WP-S0132 FOR SLAB REINFORCING AND WALL ADDITIONAL REBARS, UNO.
 - SEE DWG WP-S0515 FOR BEAM AND COLUMN SCHEDULES.
 - FOR WALL AND FTG REINF SEE SECTION **D**, TYP WP-S0206

C SECTION
 WP-F0106 1:50
 WP-S0122, WP-S0132
 WP-S0142, WP-S0147

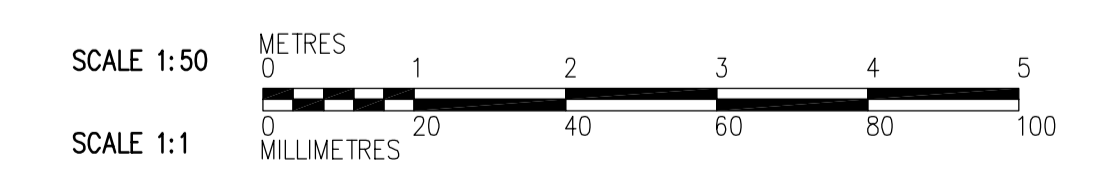

 Certificate of Authorization CH2M HILL Canada Ltd. No. 1441 Expiry: April 30, 2006	B.M. ELEV.	 Frederickson Cooper ARCHITECTS	 A Neo International Ltd. Company	ENGINEER'S SEAL	 THE CITY OF WINNIPEG WATER AND WASTE DEPARTMENT ENGINEERING DIVISION	ORIGINAL SIGNED BY D. KRUGER 2006/02/06	CITY FILE NUMBER
	DESIGNED BY RZ CHECKED BY AP			CONSULTANT DRAWING NO. WP-S0204		WATER TREATMENT PLANT FLOCCULATION AND DAF FOUNDATIONS AND CONCRETE STRUCTURES	SHEET OF
	DRAWN BY CA APPROVED BY DJT	RELEASED FOR CONSTRUCTION BY: R. SOROKOWSKI	STRUCTURAL FLOC/DAF AREA 2 SECTION	CITY DRAWING NUMBER 1-060P-A-S0204-001-00D			
	SCALE: 1:50	DATE 2005/11/01	DATE 2006/02/08	NO. REVISIONS			
00 ISSUED FOR TENDER 2006/02/03 RZ	DATE BY	DATE	DATE	DATE	DATE	DATE	DATE