


K SECTION
 WP-S0111 1:50
 WP-S0121, WP-S0131

- NOTES:**
- SEE DWG WP-S0121 FOR ADDITIONAL WALL AND SLAB REINFORCING.
 - SEE DWG WP-S0515 FOR BEAM AND COLUMN SCHEDULES.
- * ADDITIONAL BARS WITH FULL EMBEDMENT LENGTH INTO THE INTERSECTING WALLS.

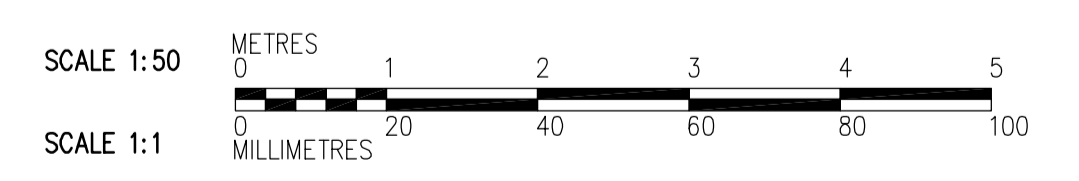

 Certificate of Authorization CH2M HILL Canada Ltd. No. 1441 Expiry: April 30, 2006	 Frederickson Cooper ARCHITECTS	 A Geo International Ltd. Company	ENGINEER'S SEAL	 THE CITY OF WINNIPEG WATER AND WASTE DEPARTMENT ENGINEERING DIVISION	WATER TREATMENT PLANT FLOCCULATION AND DAF FOUNDATIONS AND CONCRETE STRUCTURES	CITY FILE NUMBER
			DESIGNED BY: RZ CHECKED BY: AP DRAWN BY: CA APPROVED BY: DJT SCALE: 1:50 RELEASED FOR CONSTRUCTION BY: R. SOROKOWSKI			ORIGINAL SIGNED BY: D. KRUGER DATE: 2006/02/06 CONSULTANT DRAWING NO.: WP-S0216
NO. REVISIONS: 00 DATE: 2006/02/03 BY: RZ			DATE: 2005/11/08 DATE: 2006/02/08		STRUCTURAL FLOC/DAF AREA 1 SECTION	CITY DRAWING NUMBER 1-060P-A-50216-001-00D