
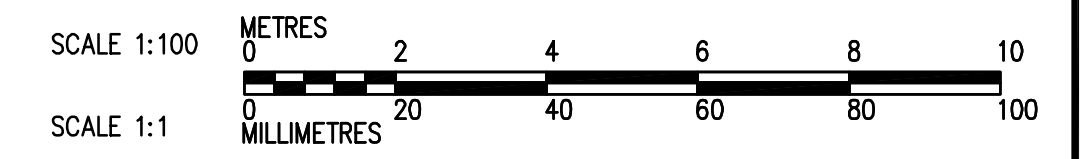


FIRST FLOOR PLAN
1:100

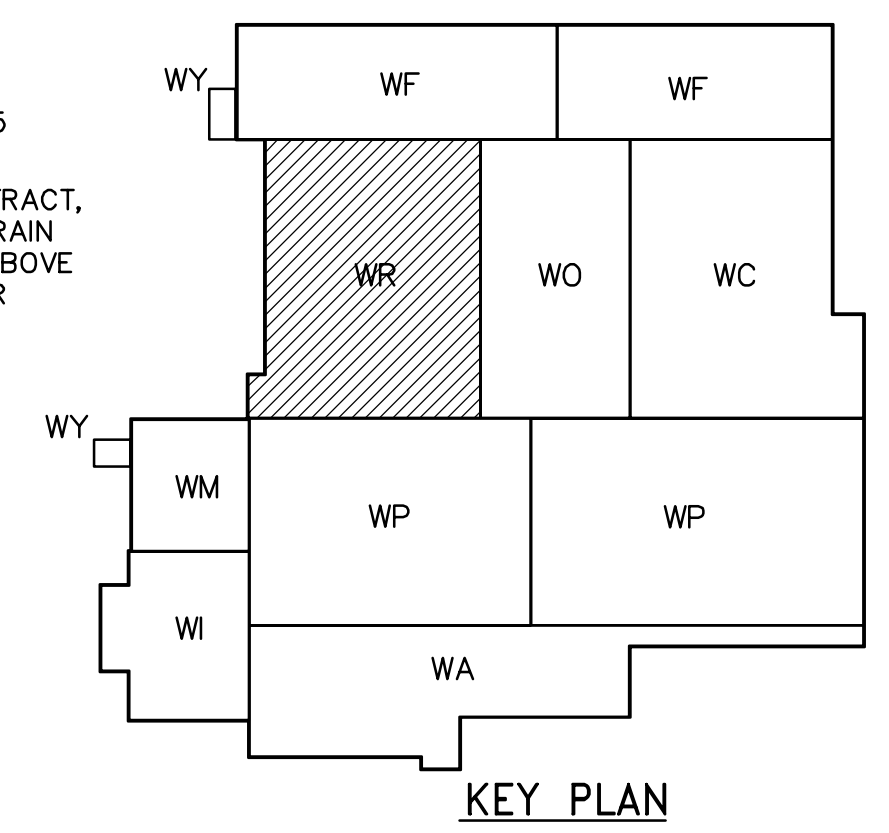

 Certificate of Authorization CH2M HILL Canada Ltd. No. 1441 Expiry: April 30, 2006	B.M. ELEV.	 Frederickson Cooper ARCHITECTS	 A Tyco International Ltd. Company	ENGINEER'S SEAL ORIGINAL SIGNED BY D.K. CUDDINGTON 2006/02/06	 THE CITY OF WINNIPEG WATER AND WASTE DEPARTMENT ENGINEERING DIVISION WATER TREATMENT PLANT RESIDUALS HANDLING FOUNDATIONS AND CONCRETE STRUCTURES PLUMBING PIPE EMBEDS RESIDUALS AREA FIRST FLOOR PLAN	CITY FILE NUMBER
	00 ISSUED FOR TENDER 2006/02/03 SW	DESIGNED BY JZ/SW DRAWN BY JMcP SCALE: 1:100	CHECKED BY DL APPROVED BY DJT RELEASED FOR CONSTRUCTION BY: R. SOROKOWSKI	SHEET OF		CITY DRAWING NUMBER 1-060R-A-1912-001-00D
	NO. REVISIONS DATE BY DATE 2005/08/02 DATE 2006/02/08	CONSULTANT DRAWING NO. WR-H9112	FOR THIS CONTRACT, END 100mm DRAIN PIPE 300mm ABOVE FINISHED FLOOR, TYP	FOR THIS CONTRACT, END 250mm STORM WATER PIPE 300mm ABOVE FINISHED FLOOR		FOR THIS CONTRACT, END 50mm VENT PIPE 300mm ABOVE FINISHED FLOOR
	FOR THIS CONTRACT, END 13mm SEAL PRIMER PIPE 300mm ABOVE FINISHED FLOOR, TYP	FOR THIS CONTRACT, END 100mm DRAIN PIPE 300mm ABOVE FINISHED FLOOR, TYP	FOR THIS CONTRACT, END 13mm SEAL PRIMER PIPE 300mm ABOVE FINISHED FLOOR, TYP	FOR THIS CONTRACT, END 100mm DRAIN PIPE 300mm ABOVE FINISHED FLOOR		FOR THIS CONTRACT, END 50mm VENT PIPE 300mm ABOVE FINISHED FLOOR