



1 NORTH ELEVATION  
1:100

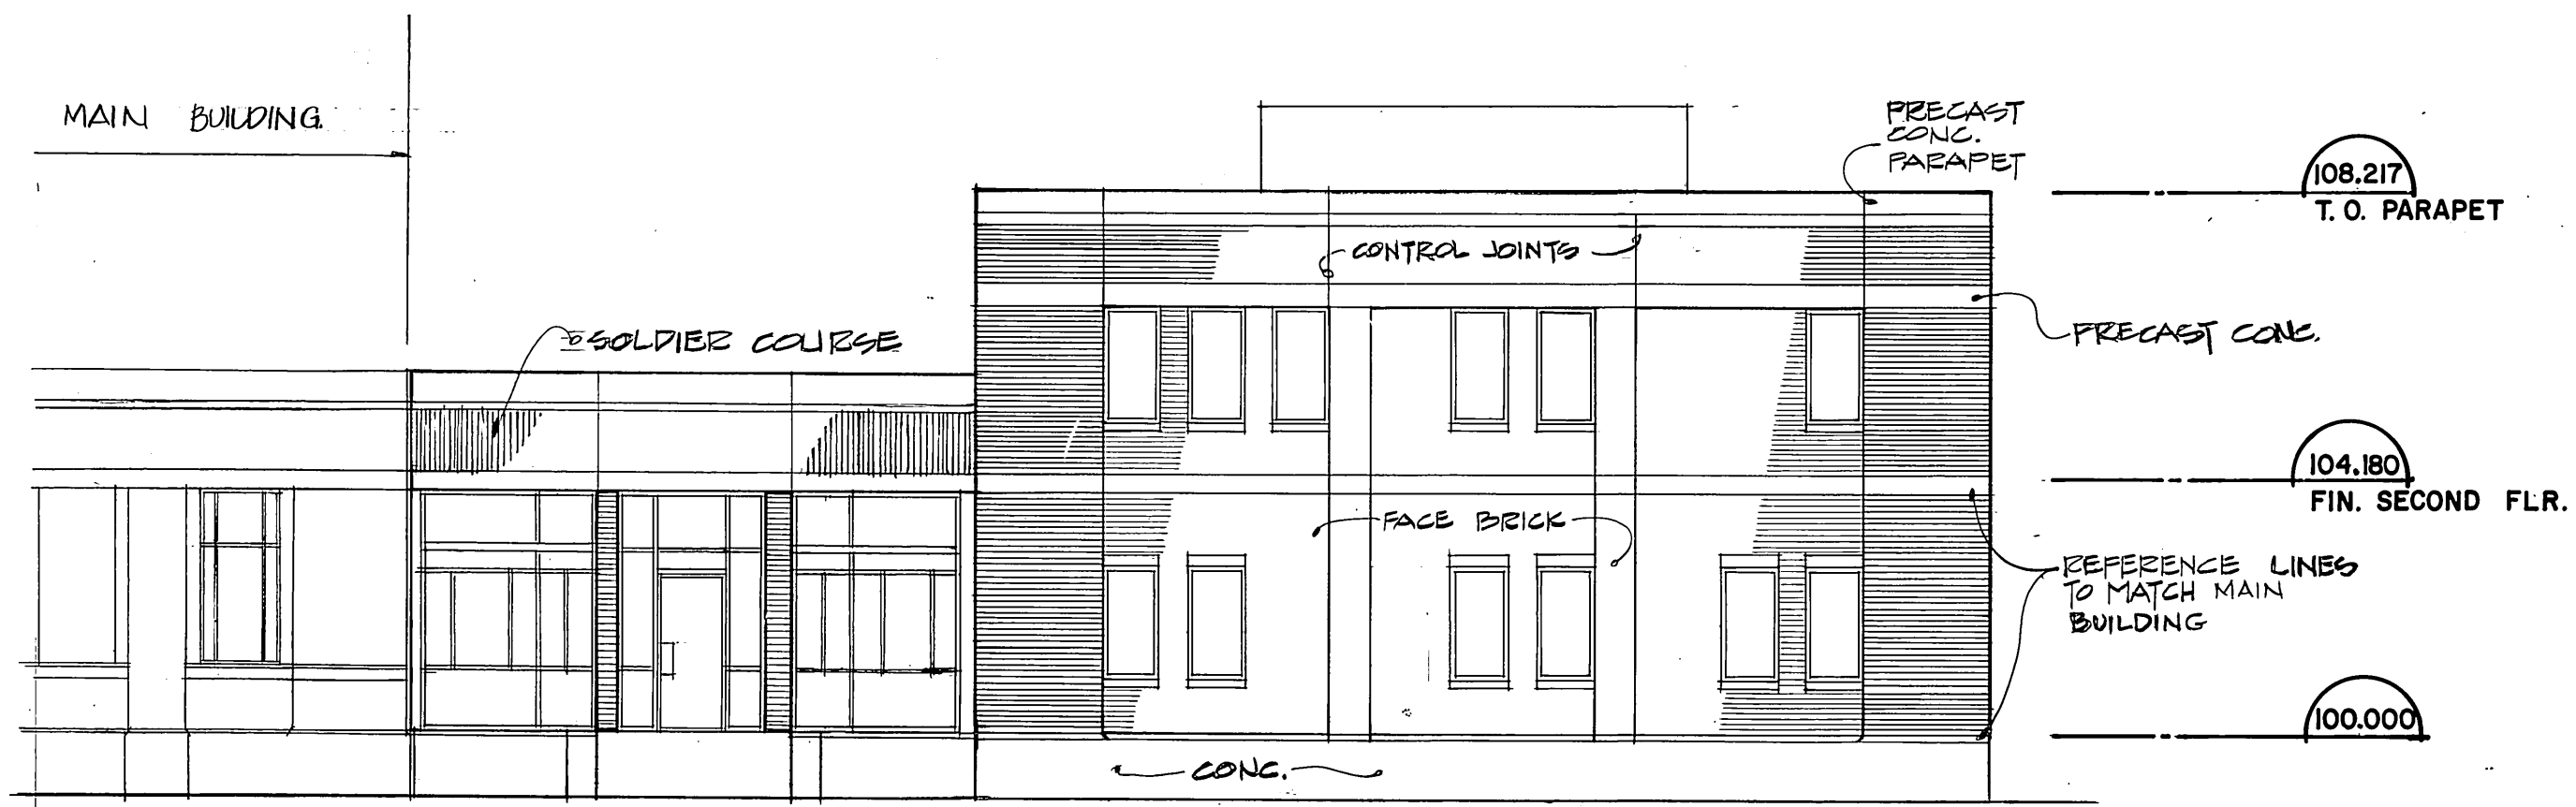

2 EAST ELEVATION  
1:100

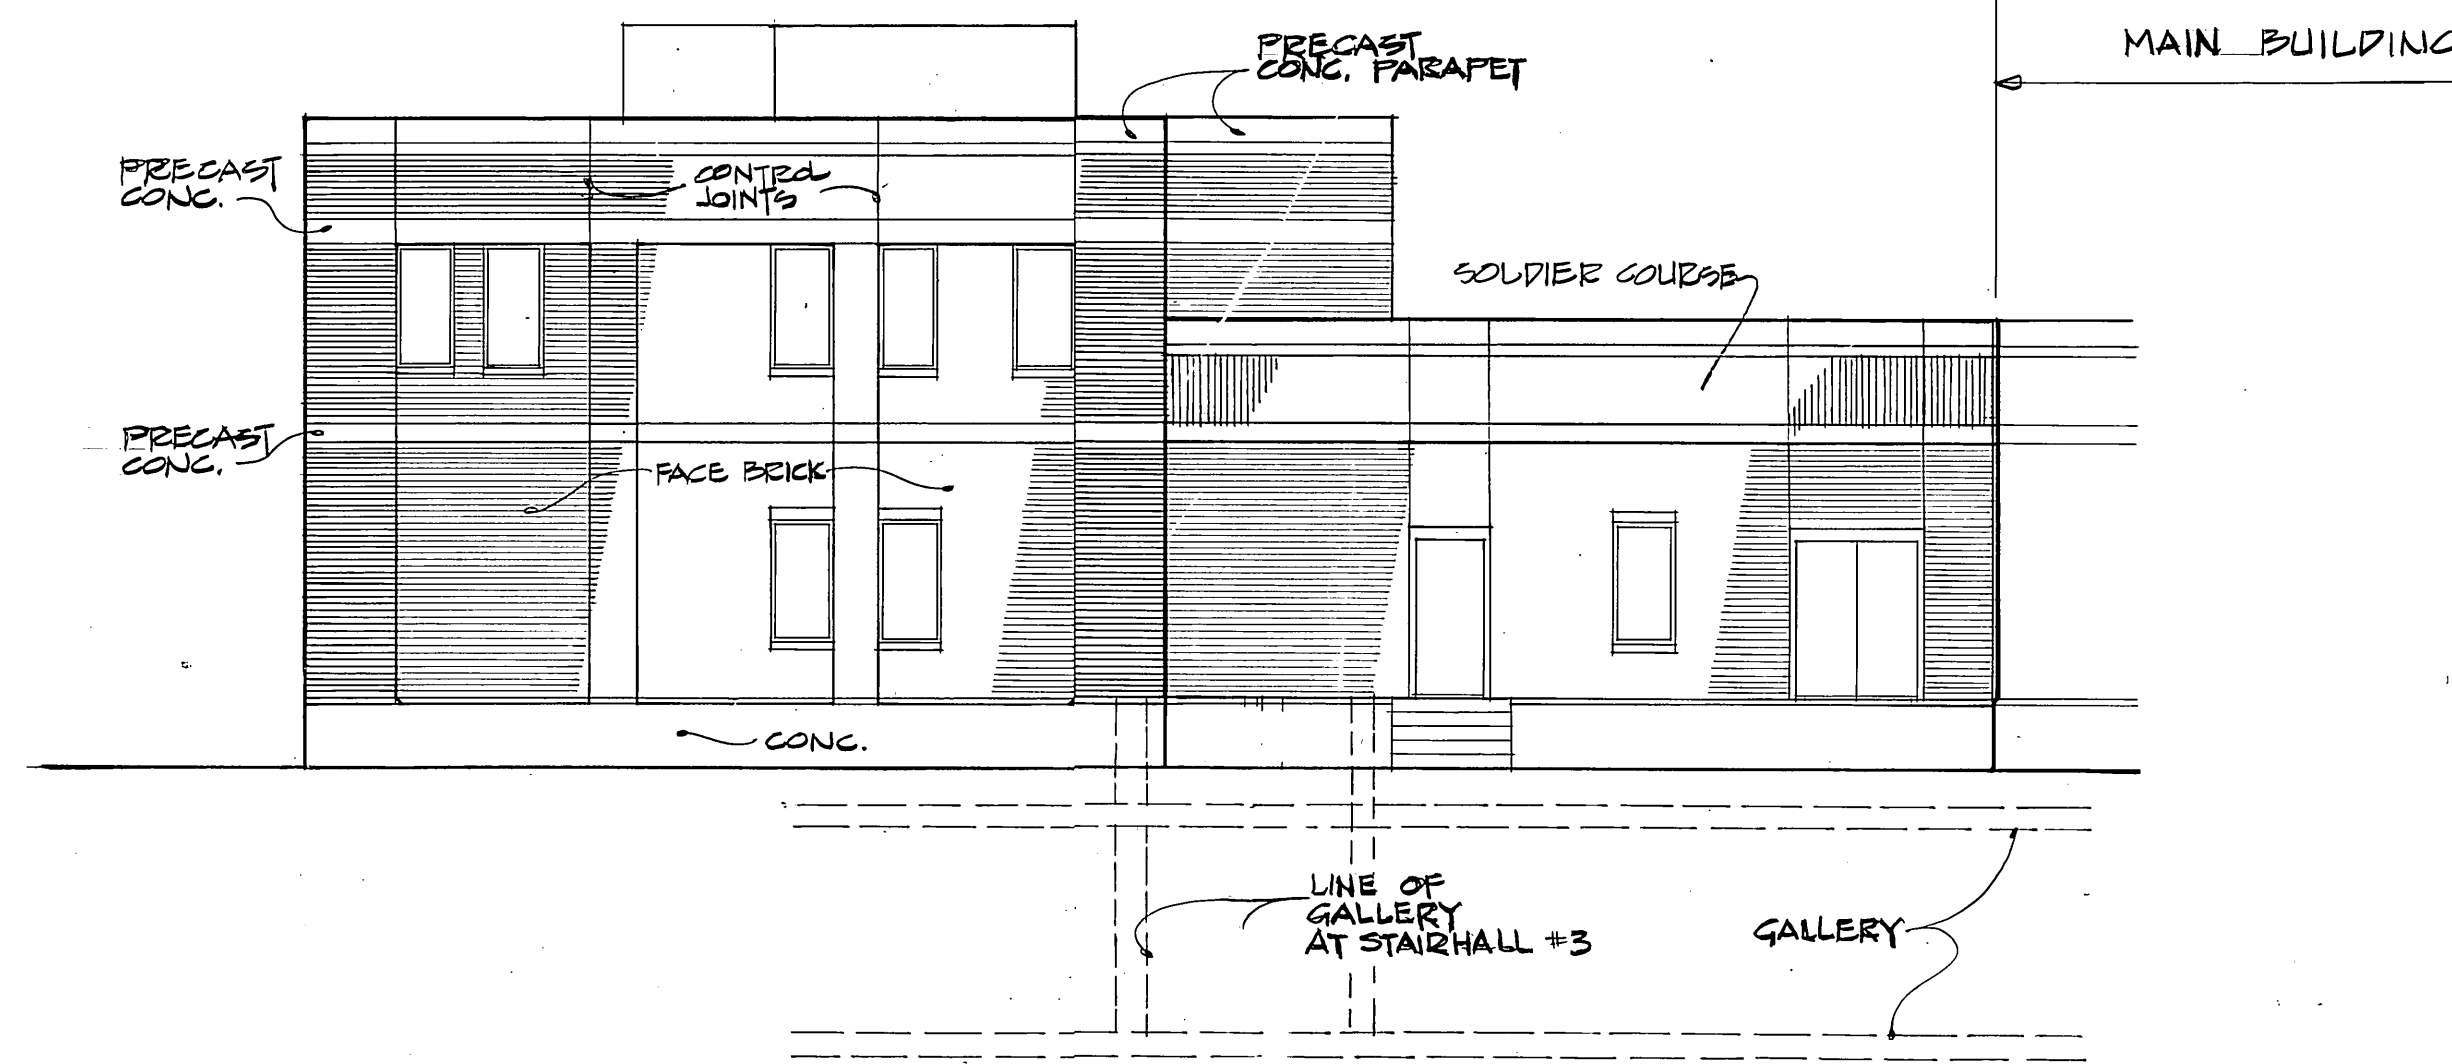

3 WEST ELEVATION  
1:100

MICROFILMED BY EK  
MICROFILMED BY EK


**METRIC**  
WHOLE NUMBERS INDICATE MILLIMETRES  
DECIMALIZED NUMBERS INDICATE METRES

SHOP DRAWING REFERENCE		
DESCRIPTION	SUPPLIER	NUMBER
Precast Architectural Concrete	Genstar Structures	2280

REVISED AS CONSTRUCTED  
DATE FEB. 14/84 BY CJA  
CHECKED BY L. ALBIANI

**E. J. GABOURY AND ASSOCIATES**  
ARCHITECTS AND URBAN DESIGNERS

NO.	REVISIONS	DATE	APP.
1	ISSUED FOR TENDER	2005/10	
2	FOR CLIENT REVIEW	22/01/82	

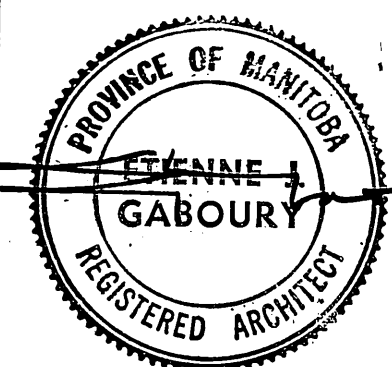

W. L. WARDROP & ASSOCIATES LTD.  
MacLAREN ENGINEERS PLANNERS & SCIENTISTS INC.

DESIGNED BY: D.C., E.J.G.  
DRAWN BY: E

CHECKED BY: D.C.  
DATE: 82. 03. 19

APPROVED BY: J. August  
DATE: Nov/82

**THE CITY OF WINNIPEG**

WORKS & OPERATIONS  
DIVISION  
WATERWORKS, WASTE & DISPOSAL DEPARTMENT

NORTH END WATER POLLUTION CONTROL CENTRE  
SECONDARY TREATMENT EXPANSION  
MAIN BUILDING EXPANSION  
ARCHITECTURAL - ELEVATIONS

RELEASED FOR CONSTRUCTION: [Signature]  
DATE: 1982.05.07

SCALE: 1:100  
DRAWING NO.: NEP 1009

NR 111 85