



SHOP DRAWING REFERENCE		
DESCRIPTION	SUPPLIER	NUMBER
Rooftop Unit	Trane	2298
Heat Canopy Fan, Main Wastewater and Acid Exhaust Hood Fans	Chicago	2303
Laboratory Equipment	Can-Lab	2295

- NOTE**
- AIR SUPPLY GRILLES FOR LABORATORY ARE : TITUS' SERIES 200 DIFFUSER CL-202-0-0-A-65 SIZES AS SPECIFIED ON THIS DWG.
 - ALL DUCTWORK, AIR SUPPLY GRILLES, EXHAUST FANS, ETC. IN LABORATORY AREA WERE FIELD LOCATED


LEGEND
 (FD) FIRE DAMPER

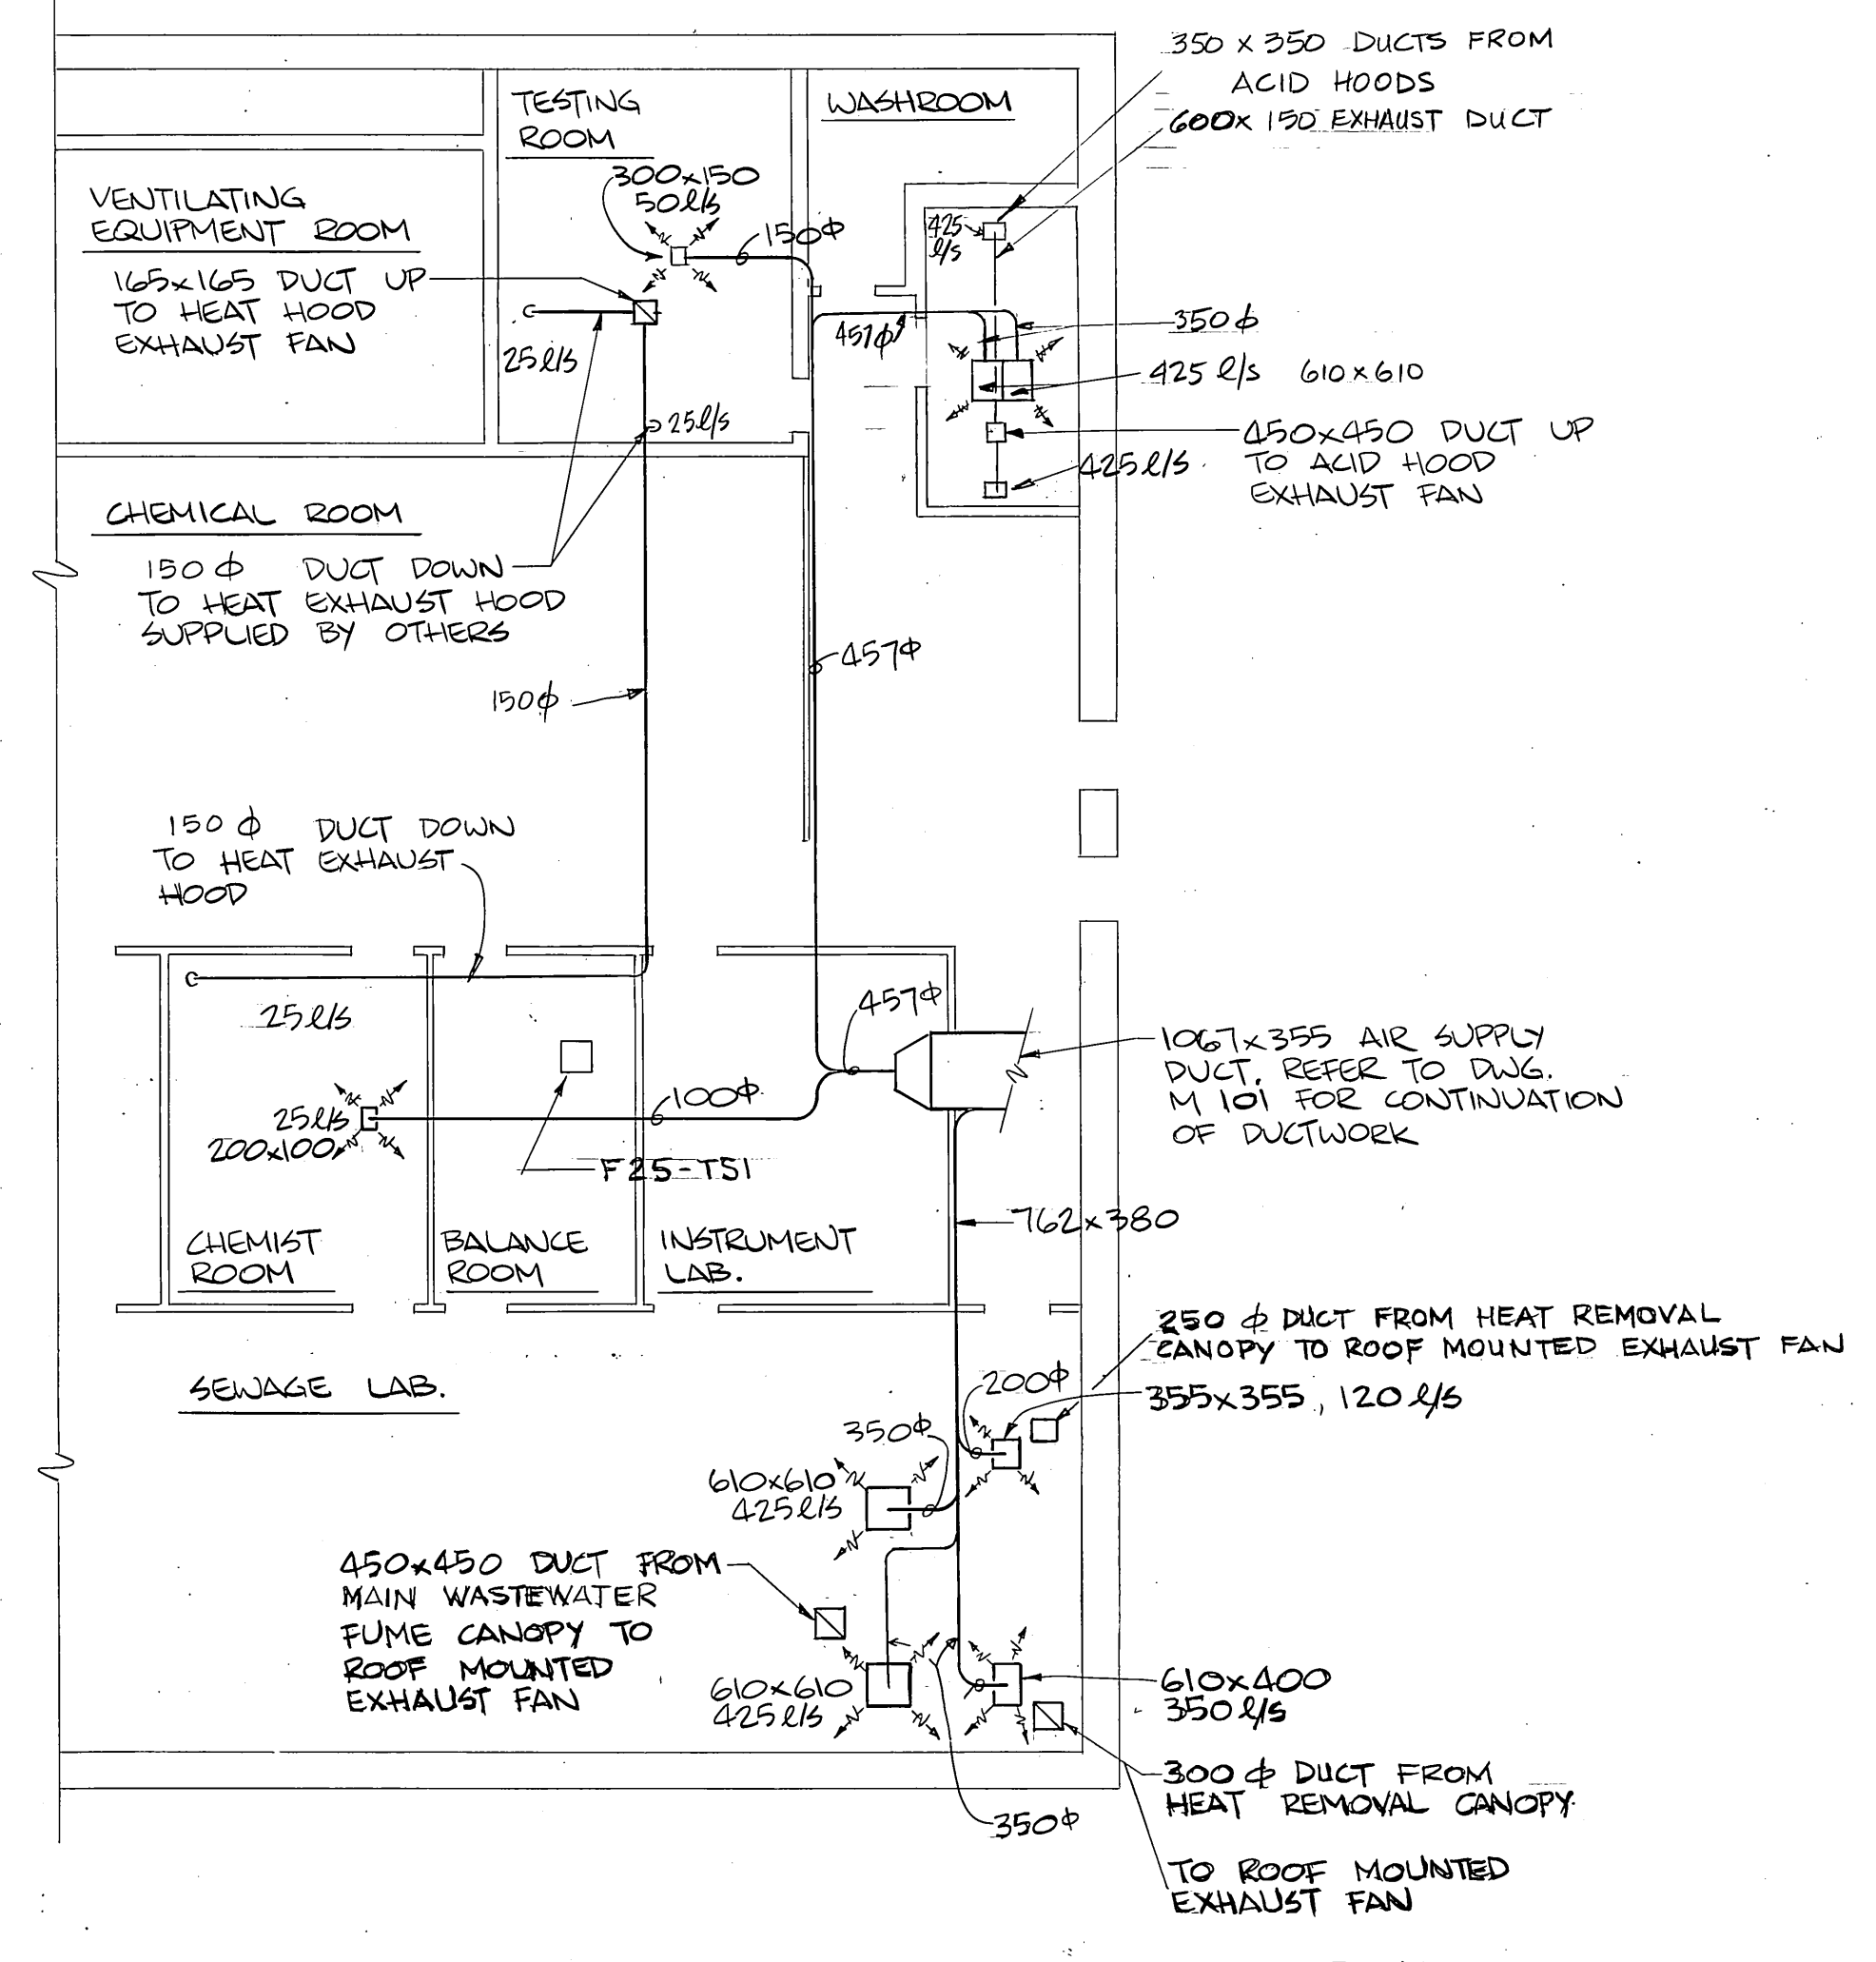


LABORATORY VENTILATION FLOOR PLAN
1:100

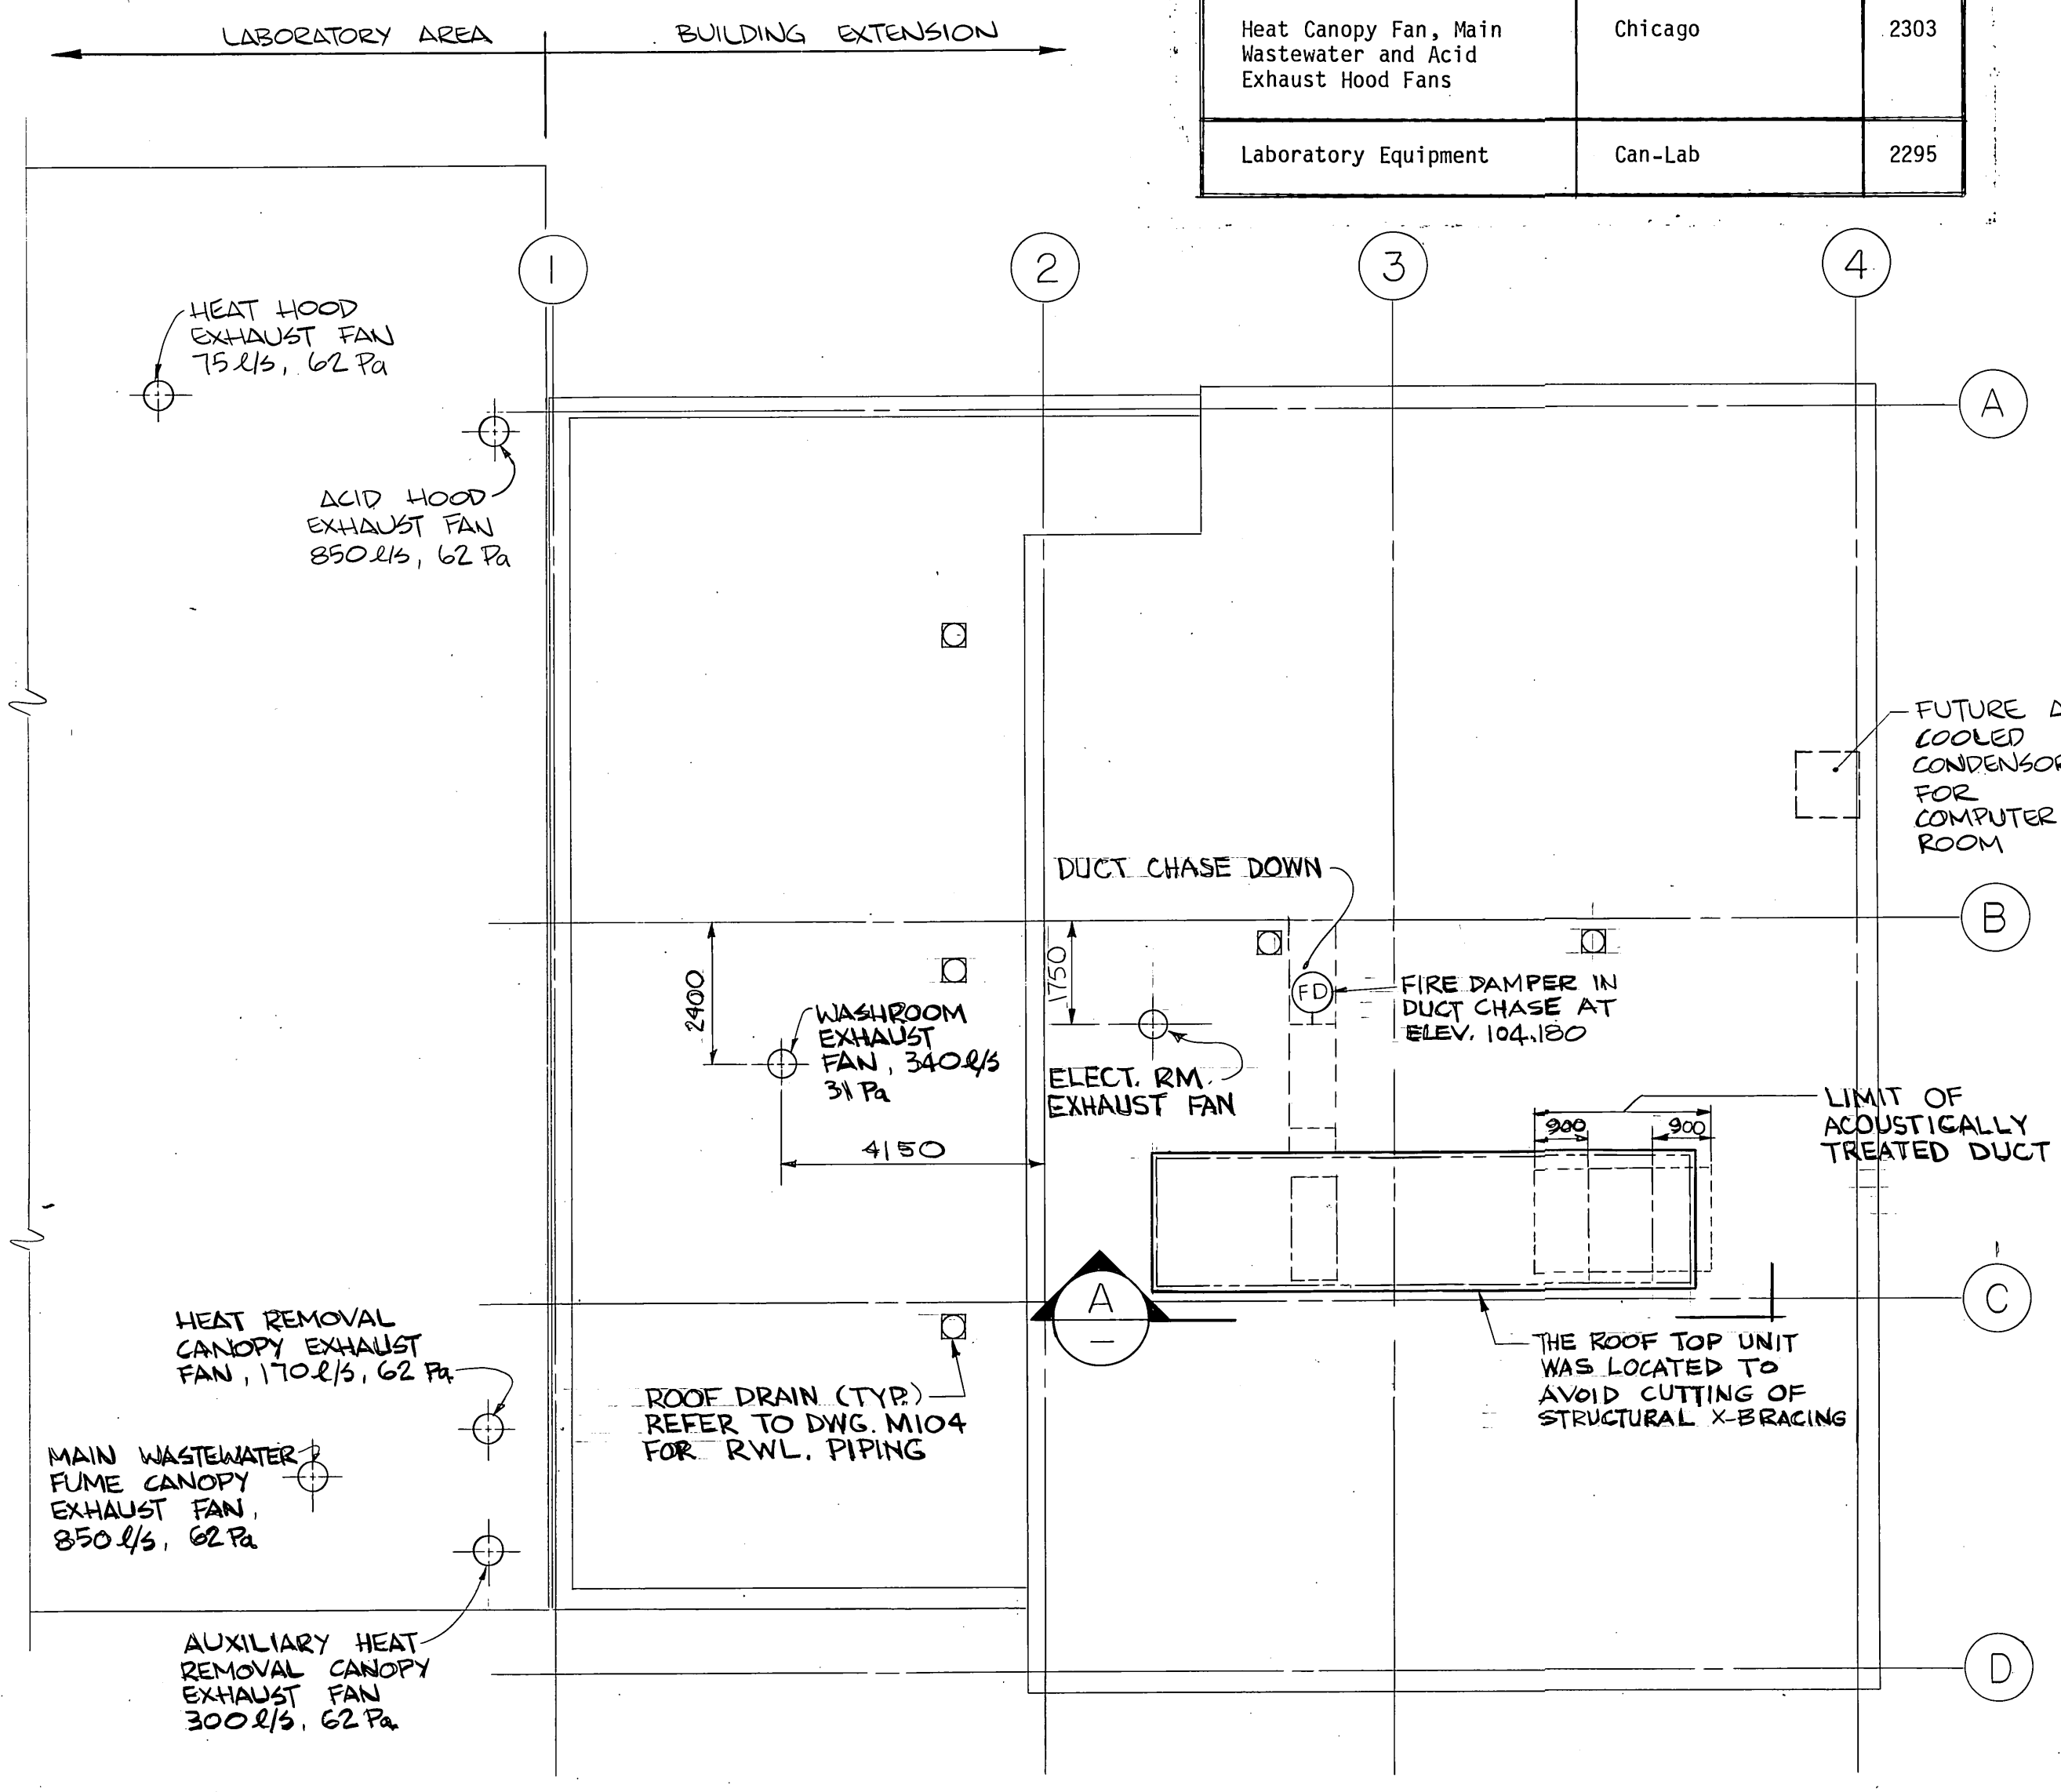

ROOF PLAN
1:100

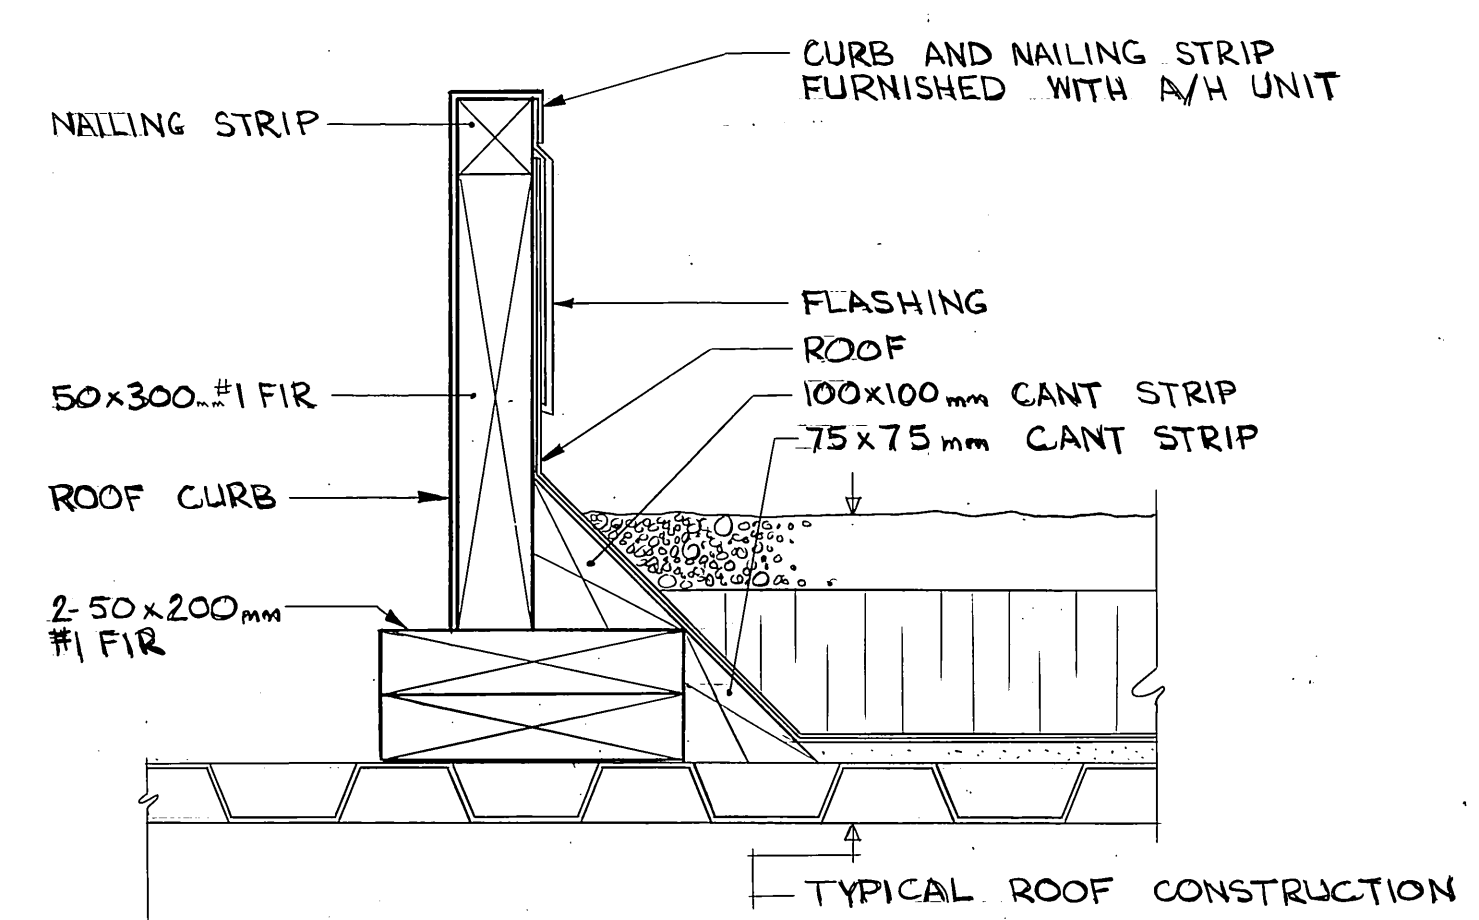

AIR HANDLING UNIT CURB DETAIL
1:5

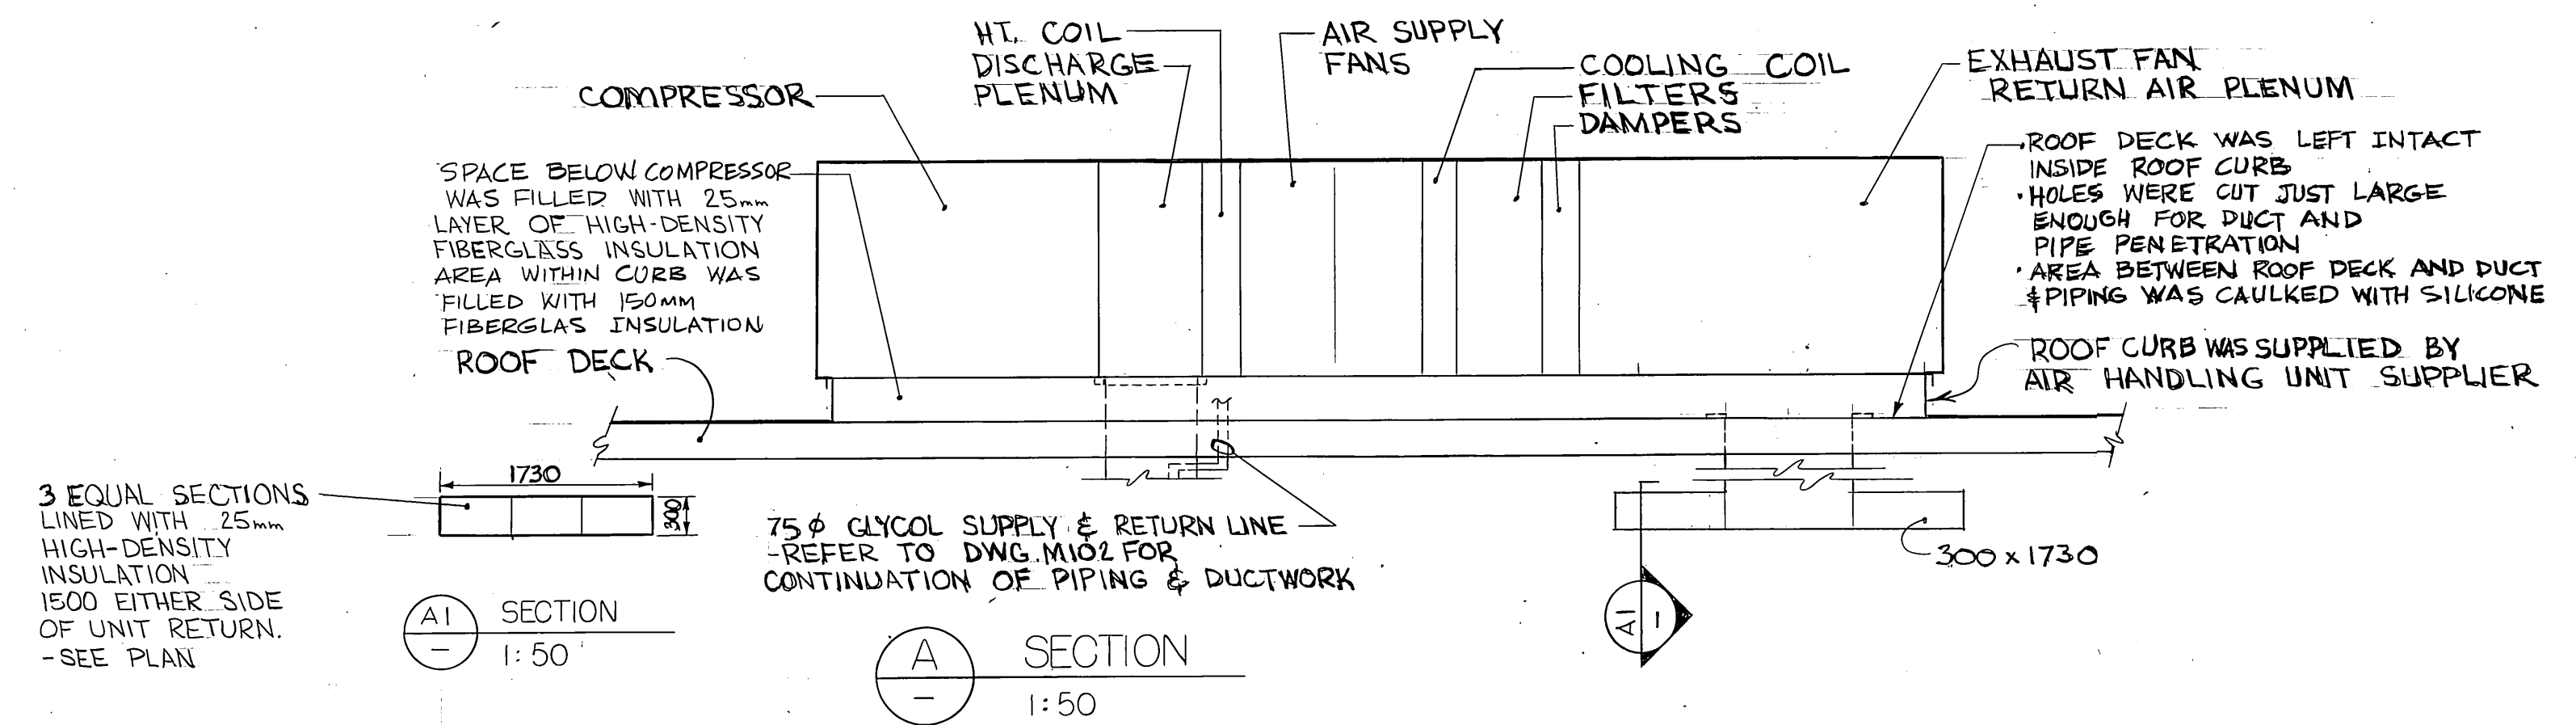


SECTION A
1:50

METRIC
WHOLE NUMBERS INDICATE MILLIMETRES
DECIMALIZED NUMBERS INDICATE METRES

REVISED AS CONSTRUCTED
DATE FEB. 14/84 BY CSA
CHECKED BY CALEJANI

NO.	REVISIONS	DATE	APP.
1	ISSUED FOR TENDER	82-05-10	
0	ISSUED FOR CLIENT REVIEW	82-01-15	

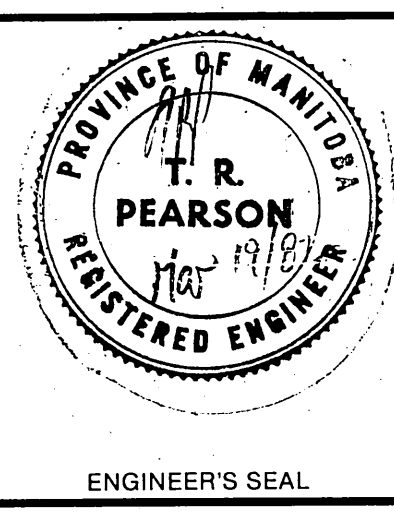

W.L. WARDROP & ASSOCIATES LTD. MacLAREN ENGINEERS PLANNERS & SCIENTISTS INC.	
DESIGNED BY: A.Y.F.	DRAWN BY: GC
CHECKED BY: JRP	DATE: 82-03-22
APPROVED BY: J. Maguire	DATE: Nov/82

THE CITY OF WINNIPEG
WORKS & OPERATIONS DIVISION
WATERWORKS, WASTE & DISPOSAL DEPARTMENT

NORTH END WATER POLLUTION CONTROL CENTRE SECONDARY TREATMENT EXPANSION MAIN BUILDING EXPANSION ROOF PLAN, EXISTING LAB. VENTILATION AND DETAIL	
RELEASED FOR CONSTRUCTION ON: [Signature]	DATE: 1982-05-07
SCALE: AS SHOWN	DRAWING NO.: NEP-1035

NR11211

800012-11-07-M-103

NEP-1035