




# THE CITY OF WINNIPEG

PUBLIC WORKS DEPARTMENT  
ENGINEERING DIVISION

## KENASTON UNDERPASS PROJECT BID OPPORTUNITY No. 644-2005 PUMPING STATION

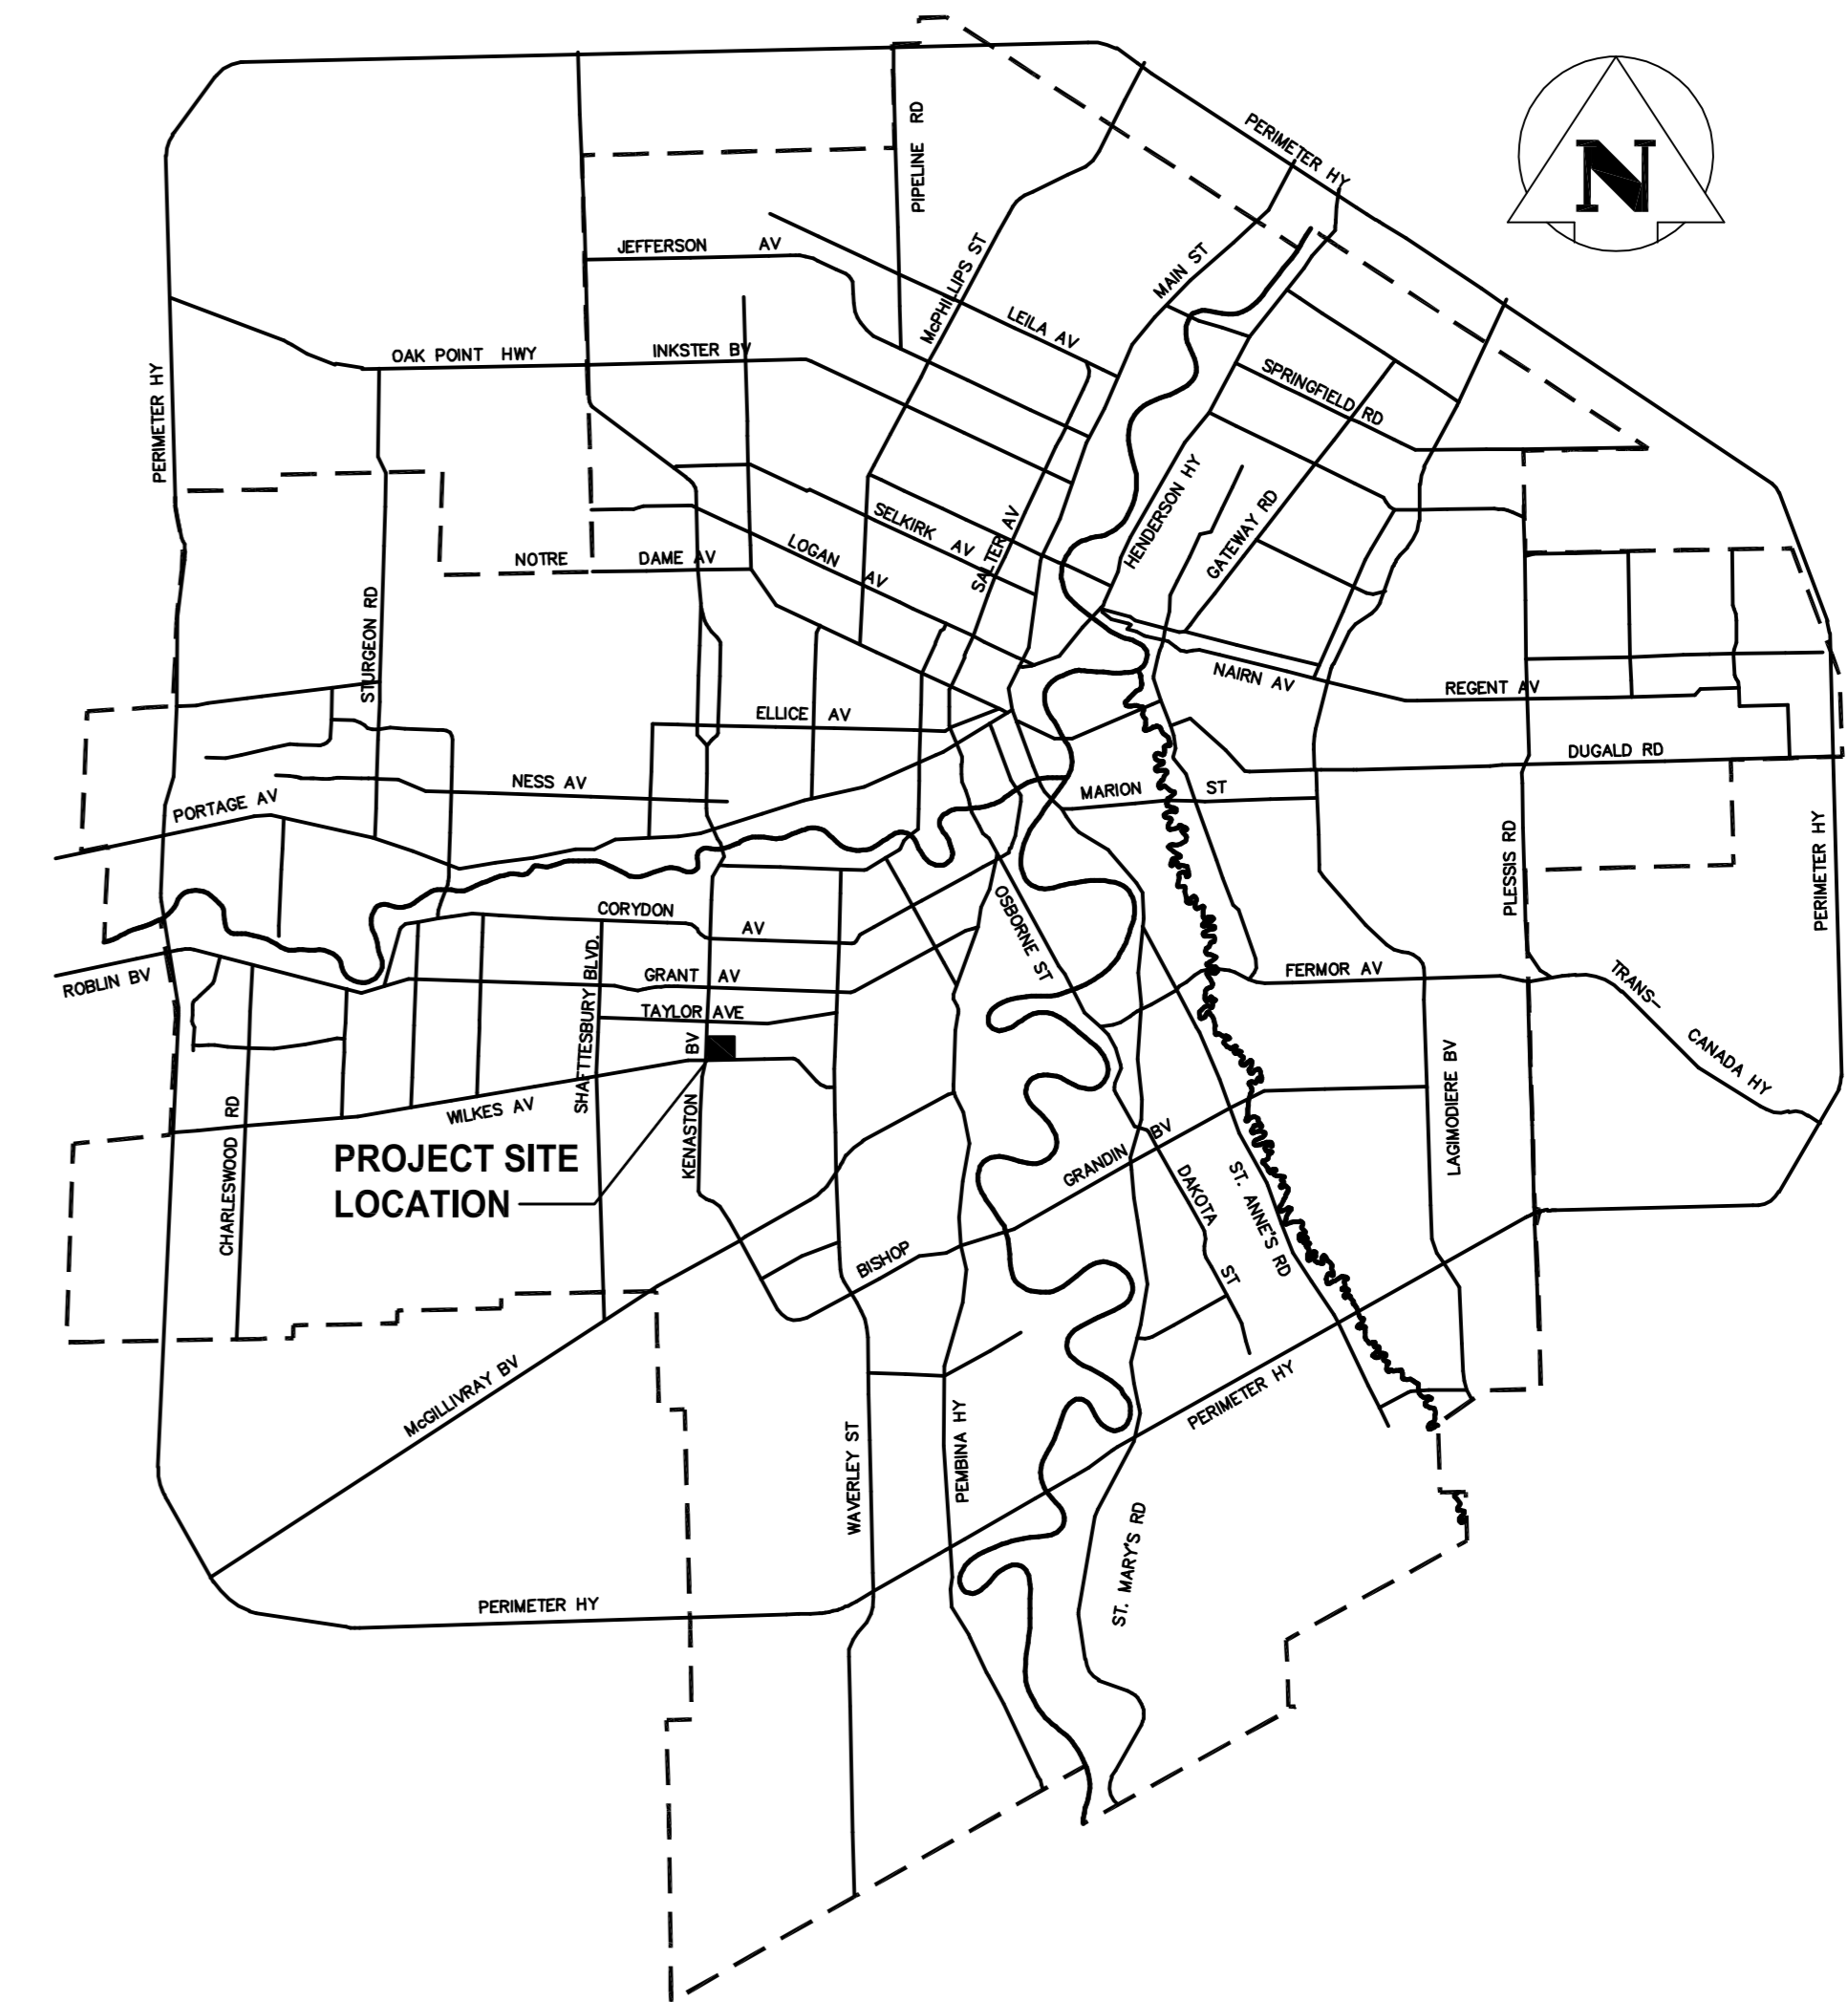

**DRAWING INDEX**

CITY DWG. No.	CONSULTANT DRW. No.	SHEET No.	SHEET TITLE
<b>GENERAL</b>			
P-3258-146	113703042-G05	1 OF 26	COVER & DRAWING LIST
<b>CIVIL</b>			
P-3258-147	113703042-C01	2 OF 26	SITE PLAN
05699	113703042-U23	3 OF 26	FORCEMAIN AND LAND DRAINAGE SEWER - STA. 1+250 TO PUMPING STATION
<b>STRUCTURAL</b>			
P-3258-148	113703042-S19	4 OF 26	STRUCTURAL - FOUNDATION PLAN, MECHANICAL & BAFFLE FLOOR FRAMING PLANS
P-3258-149	113703042-S20	5 OF 26	STRUCTURAL - MAIN FRAMING FLOOR PLAN, ROOF PLAN AND SCHEDULES
P-3258-150	113703042-S21	6 OF 26	STRUCTURAL - DETAILS, SECTIONS & GENERAL NOTES
P-3258-151	113703042-S22	7 OF 26	STRUCTURAL - BUILDING SECTIONS
P-3258-152	113703042-S23	8 OF 26	STRUCTURAL - BUILDING SECTIONS
P-3258-153	113703042-S24	9 OF 26	STRUCTURAL - DETAILS AND SECTIONS
P-3258-154	113703042-S25	10 OF 26	STRUCTURAL - DETAILS AND SECTIONS
<b>ARCHITECTURAL</b>			
P-3258-155	113703042-A01	11 OF 26	ARCHITECTURAL - MAIN FLOOR PLAN AND SECTION
P-3258-156	113703042-A02	12 OF 26	ARCHITECTURAL - BUILDING SECTIONS
P-3258-157	113703042-A03	13 OF 26	ARCHITECTURAL - ROOF AND WALL SECTIONS
P-3258-158	113703042-A04	14 OF 26	ARCHITECTURAL - STAIR DETAILS
P-3258-159	113703042-A05	15 OF 26	ARCHITECTURAL - ELEVATIONS
<b>PLUMBING</b>			
P-3258-160	113703042-P01	16 OF 26	PLUMBING - MAIN FLOOR AND BASEMENT FLOOR PLAN PLUMBING LAYOUTS AND SCHEMATICS
<b>PROCESS</b>			
P-3258-161	113703042-D01	17 OF 26	PROCESS - MAIN FLOOR PLAN, SECTION AND PROCESSING SCHEMATIC
P-3258-162	113703042-D02	18 OF 26	PROCESS - BASEMENT AND WET WELL FLOOR PLANS AND SECTION
P-3258-163	113703042-D03	19 OF 26	PROCESS - MISCELLANEOUS MECHANICAL DETAILS
<b>MECHANICAL</b>			
P-3258-164	113703042-M01	20 OF 26	HVAC - MECHANICAL FLOOR PLAN AND DETAILS
P-3258-165	113703042-M02	21 OF 26	HVAC - MECHANICAL SECTIONS
<b>ELECTRICAL</b>			
P-3258-166	113703042-E03	22 OF 26	ELECTRICAL - SITE PLAN AND MCC DETAILS
P-3258-167	113703042-E04	23 OF 26	ELECTRICAL - FLOOR PLANS AND DETAILS
P-3258-168	113703042-E05	24 OF 26	ELECTRICAL - MISCELLANEOUS CONTROL WIRING DIAGRAMS
P-3258-169	113703042-E06	25 OF 26	ELECTRICAL - MISCELLANEOUS CONTROL WIRING DIAGRAMS
P-3258-170	113703042-S26	26 OF 26	STRUCTURAL - HATCH DETAILS

3 REVISION NUMBER



**Stantec Consulting Ltd.**

WINNIPEG

MANITOBA

RELEASED FOR CONSTRUCTION BY:

DATE:

CONSULTANT DRAWING No.

113703042-G05

CITY DRAWING No.

P-3258-146-R3

CAD FILE DRAWING No.

KU-COVER.dwg