


**THIRD FLOOR PLAN**  
1:100

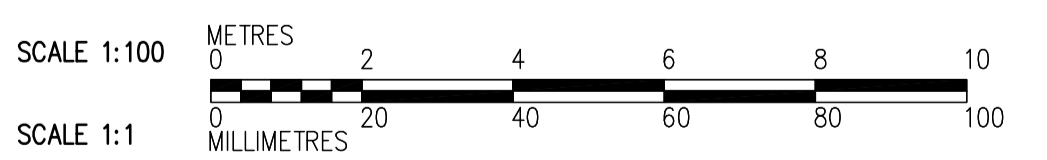

<p><b>Certificate of Authorization</b> CH2M Hill Canada Limited (ON) No. 1441 Expiry: April 30, 2006</p>	<p>Frederickson Cooper ARCHITECTS</p>		<p>A Tyco International Ltd. Company</p>		ENGINEER'S SEAL ORIGINAL SIGNED BY D. KRUGER 2005/10/28	<p><b>THE CITY OF WINNIPEG</b> WATER AND WASTE DEPARTMENT ENGINEERING DIVISION</p> <p>WATER TREATMENT PLANT</p> <p>FOUNDATIONS AND CONCRETE STRUCTURES 1</p> <p>STRUCTURAL RAW WATER PUMP STATION AREA THIRD FLOOR PLAN</p>	CITY FILE NUMBER
	DESIGNED BY: EL CHECKED BY: AP		DRAWN BY: RL APPROVED BY: AHL		SHEET OF		
	SCALE: 1:100		RELEASED FOR CONSTRUCTION BY: R. SOROKOWSKI DATE: 2005/07/08		CITY DRAWING NUMBER		
	NO. REVISIONS DATE BY		DATE: 2005/07/08 DATE: 2005/10/28		CONSULTANT DRAWING NO. WI-S0131		