


LOWER ROOF PLAN
1:300

FOUNDATIONS AND CONCRETE
STRUCTURES 1 CONTRACT

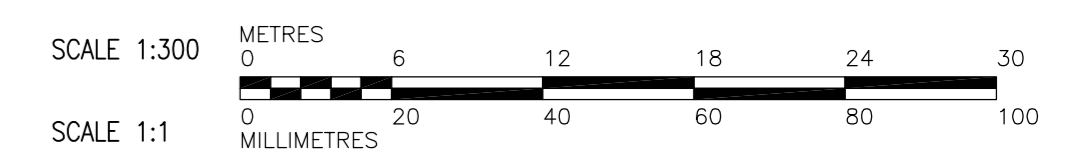

 Certificate of Authorization CH2M Hill Canada Limited (ON) No. 1441 Expiry: April 30, 2006	B.M. ELEV.	 Frederickson Cooper ARCHITECTS	 A Tyco International Ltd. Company	ENGINEER'S SEAL	 THE CITY OF WINNIPEG WATER AND WASTE DEPARTMENT ENGINEERING DIVISION WATER TREATMENT PLANT FOUNDATIONS AND CONCRETE STRUCTURES 1 STRUCTURAL OVERALL BUILDING ROOF FRAMING AND CONTRACT LIMIT PLAN	CITY FILE NUMBER
				DESIGNED BY: JC		CHECKED BY: AP
		DRAWN BY: MS	APPROVED BY: DJT	2005/10/28		CITY DRAWING NUMBER
	00 ISSUED FOR TENDER 05/10/28 JC	SCALE: 1:300	RELEASED FOR CONSTRUCTION BY: R. SOROKOWSKI	CONSULTANT DRAWING NO. WB-SB140		1-060B-A-38140-001-000
NO. REVISIONS	DATE BY	DATE 2005/09/21	DATE 2005/10/28			