



24.366

24.366/PLOT SCALE=1:1

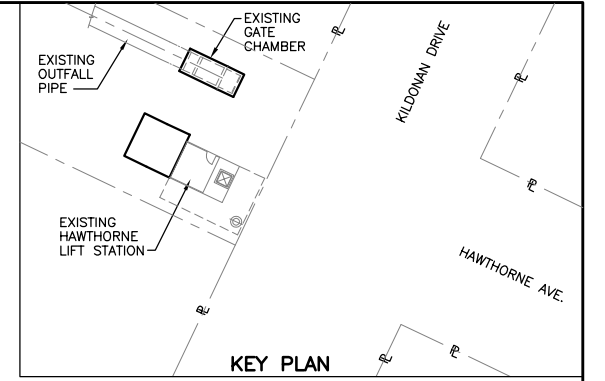

A	26/10/05	ISSUED FOR PUMP SUPPLY TENDER	RED
NO.	D / M / Y	DESCRIPTION	BY
REVISIONS / ISSUE			
A. SECTION LETTER OR DETAIL NUMBER			
B. DRAWING WHERE SECTION OR DETAIL IS DRAWN			
OR			
DRAWING WHERE SECTION OR DETAIL WAS INDICATED			
- SECTION OR DETAIL SHOWN ON SAME DRAWING			
A B			A -
KGS GROUP CONSULTING ENGINEERS & PROJECT MANAGERS			
WINNIPEG (204) 896-1209 THUNDER BAY (807) 345-2233			
CLIENT:			
THE CITY OF WINNIPEG WATER AND WASTE DEPARTMENT			
PROJECT:			
HAWTHORNE FPS UPGRADE			
DWG. DESCRIPTION:			
SITE PLAN			
ENG. STAMP	DESIGNED BY: RED	DRAWN BY: VJH	
	CHECKED BY: RED	CHECKED BY:	
APPROVED:			
SCALE:	AS NOTED	DATE:	JUNE 2005
KGS DWG. NO.	05-0107-13		M1
CLIENT DWG. NO.			REV: A

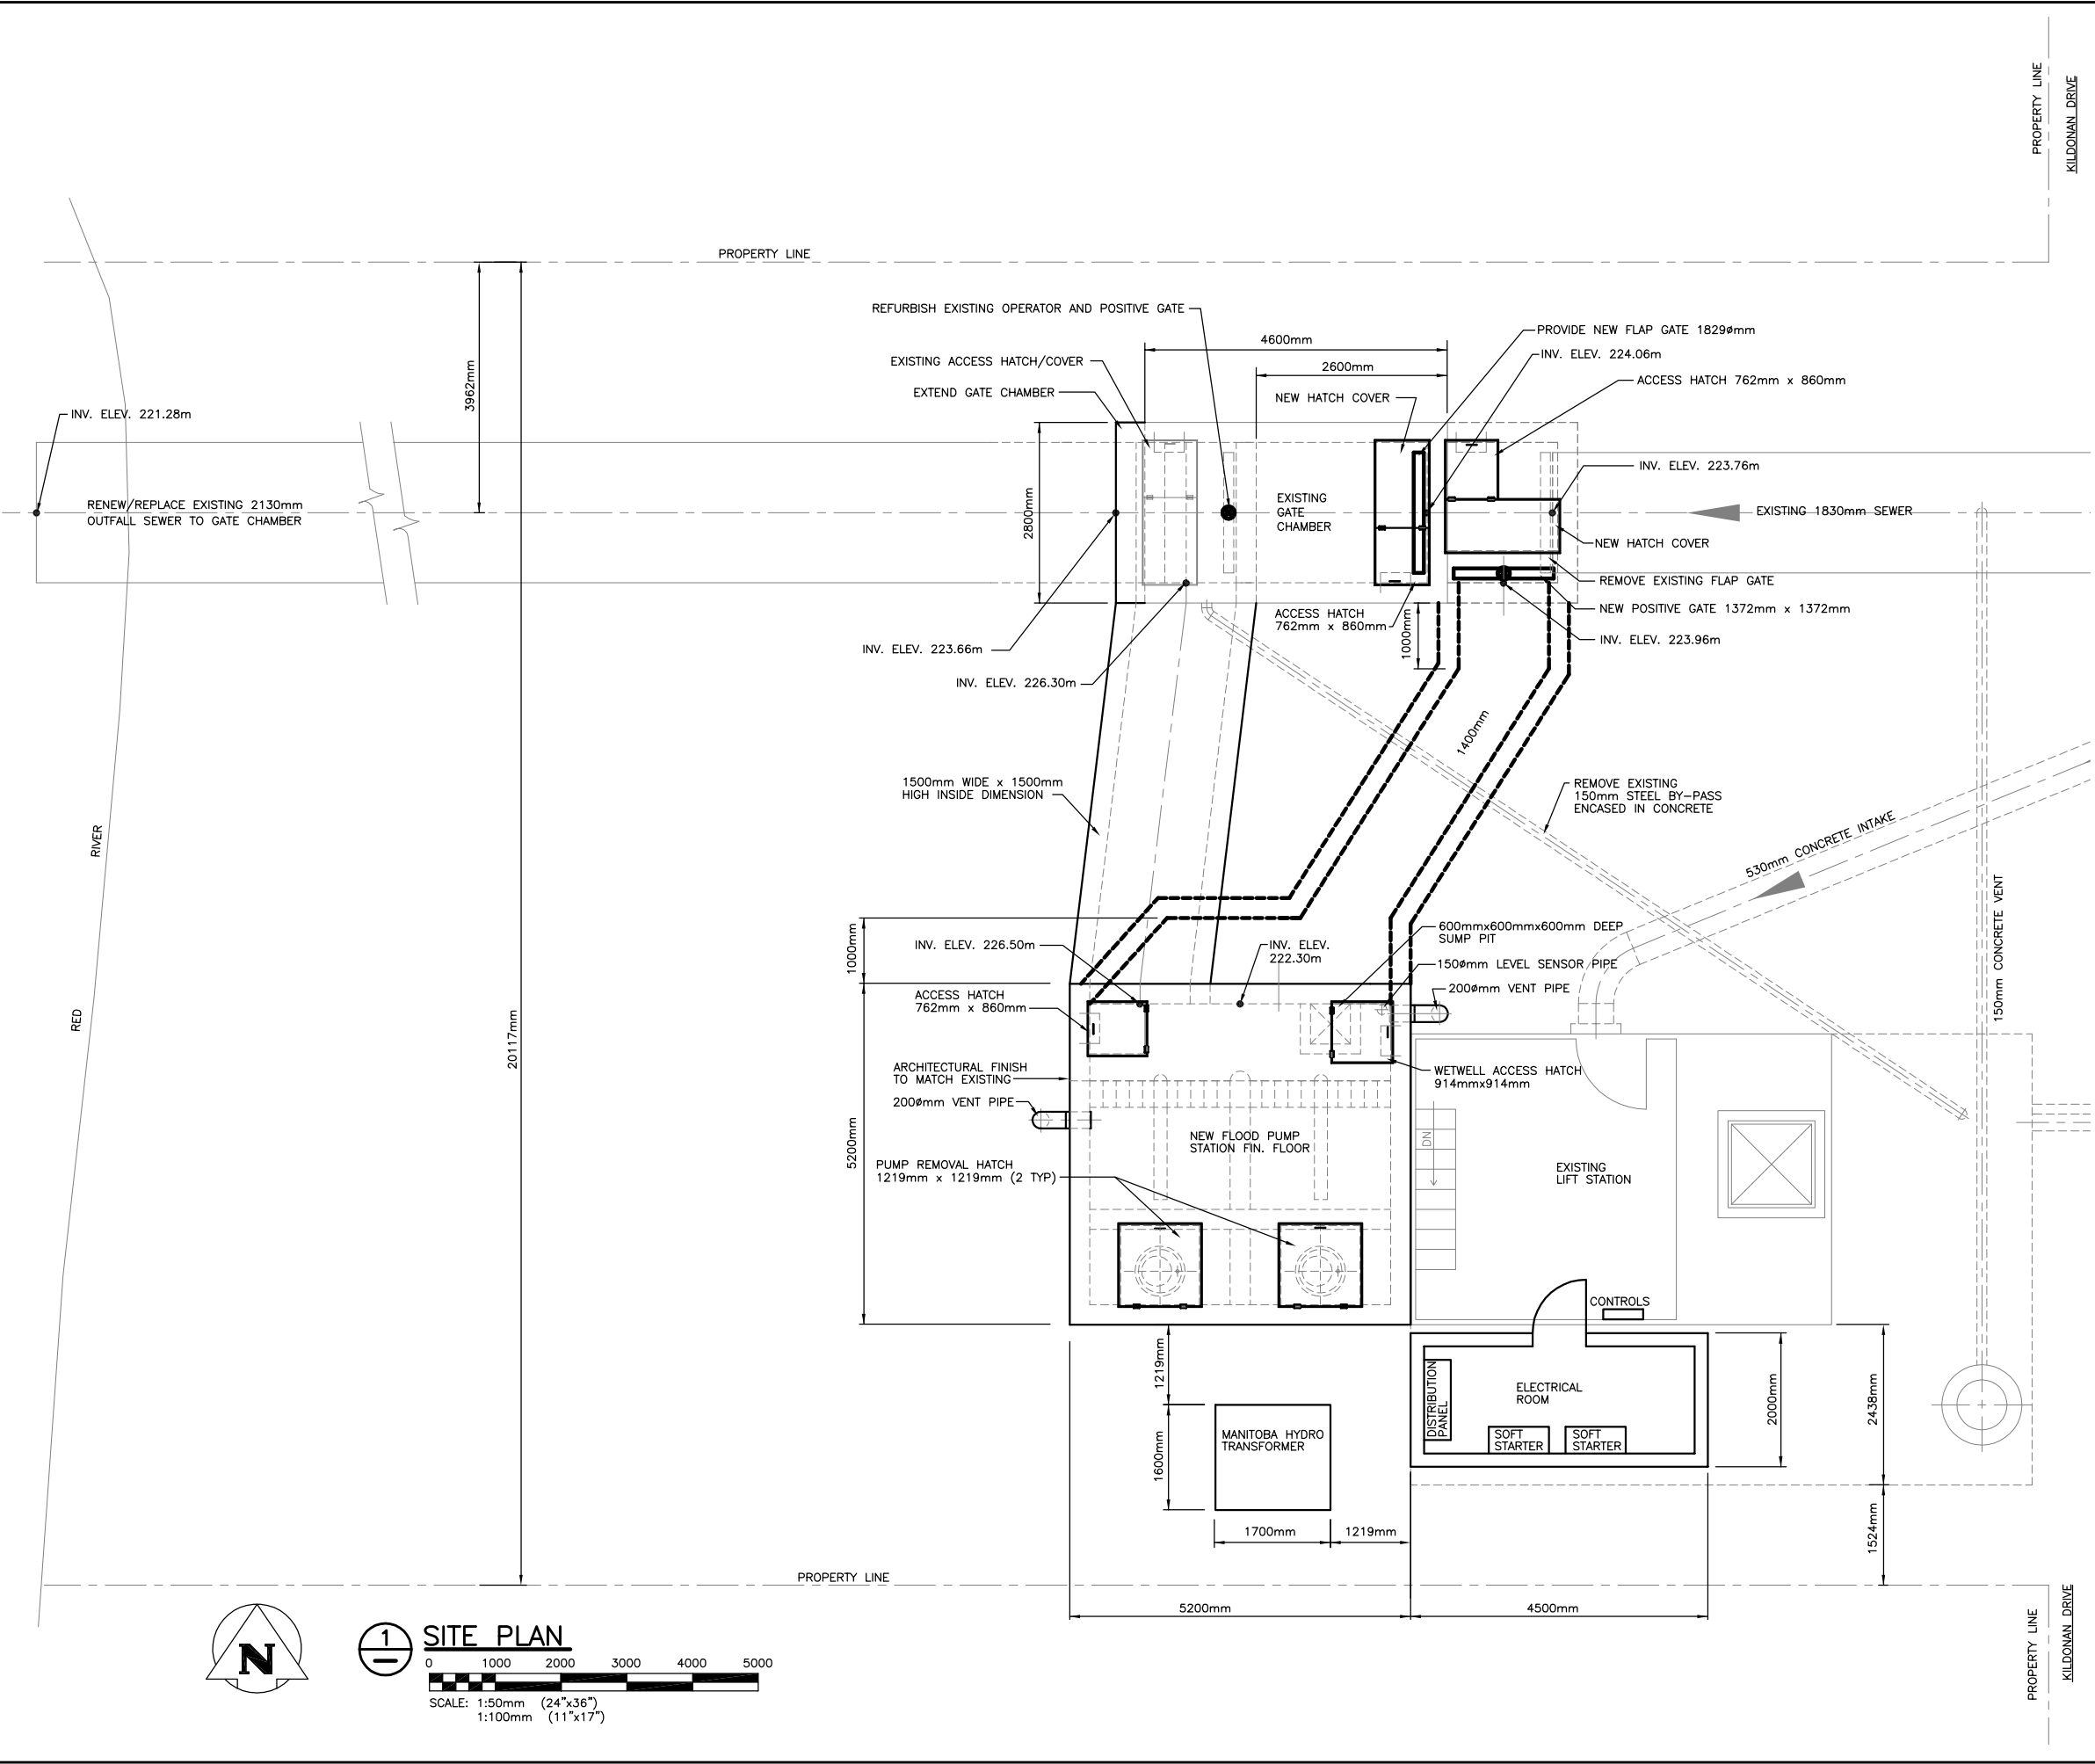