

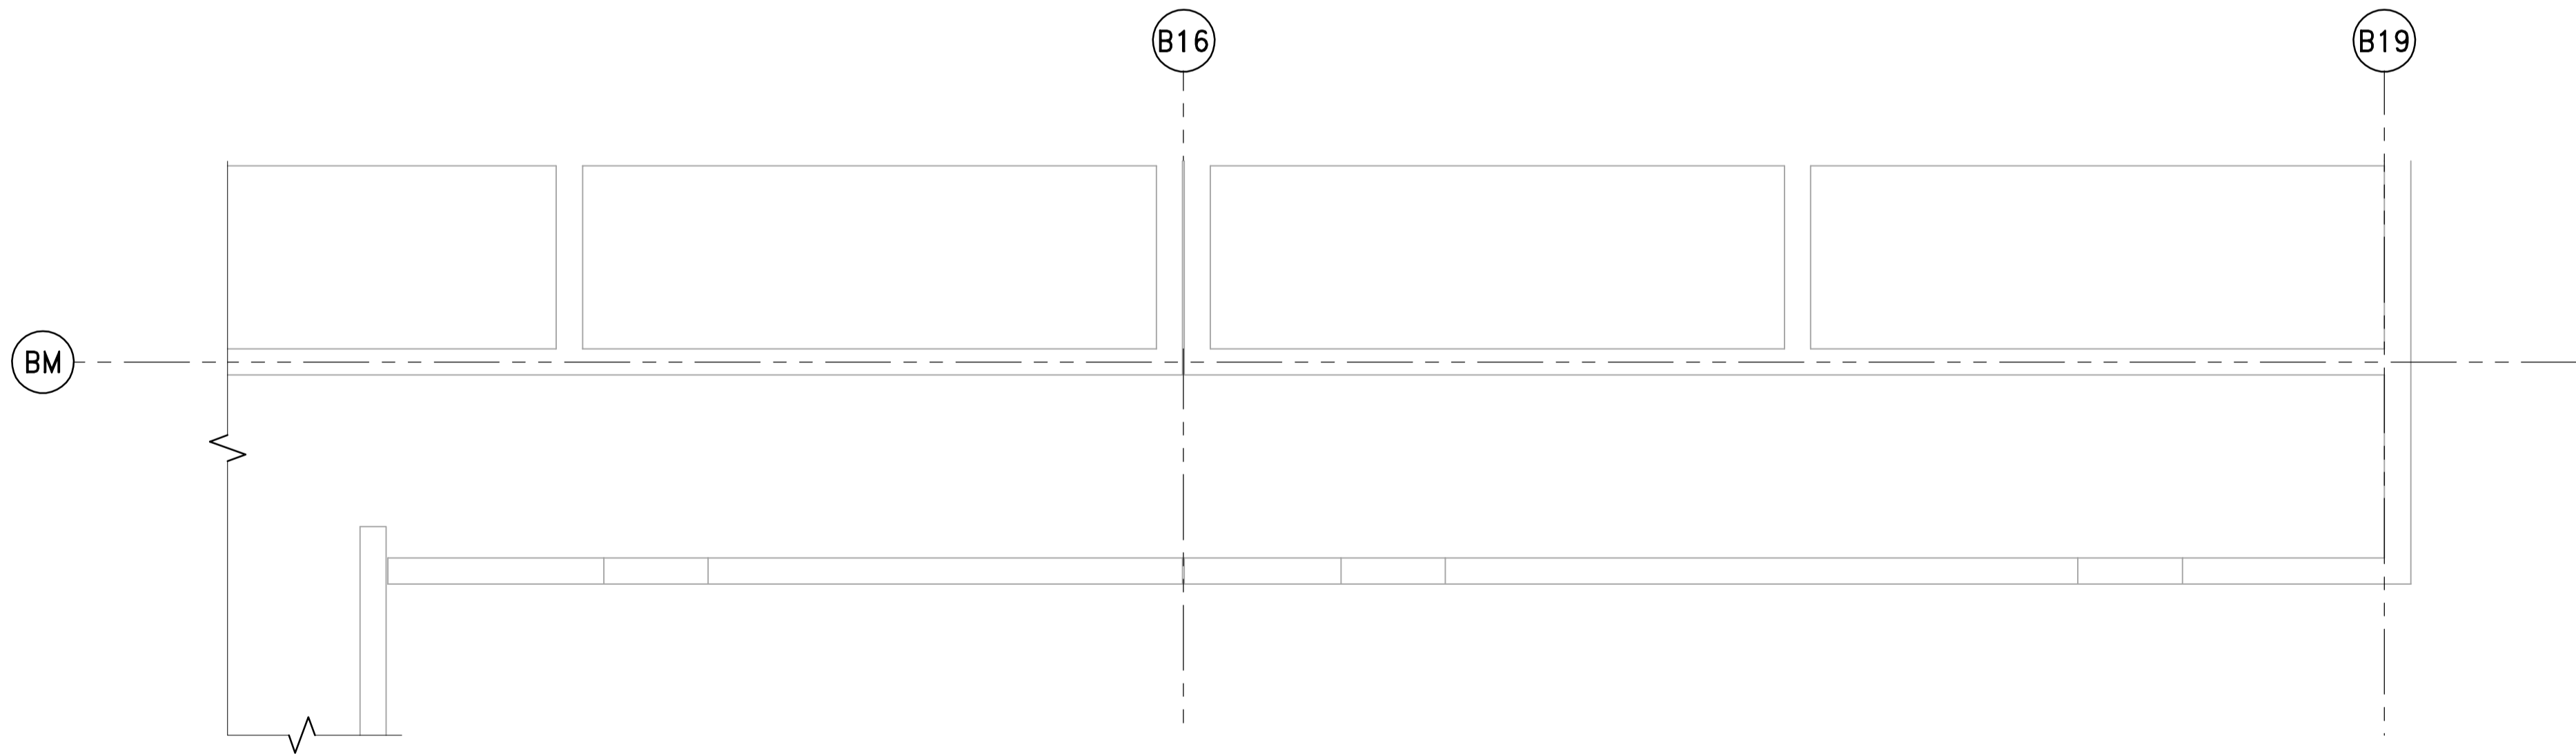


SECOND FLOOR PLAN
1:100

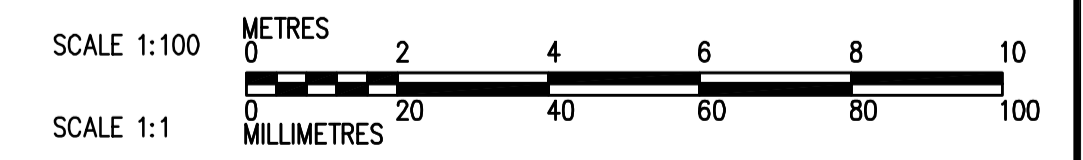

SECOND FLOOR PLAN (CONTINUATION)
1:100

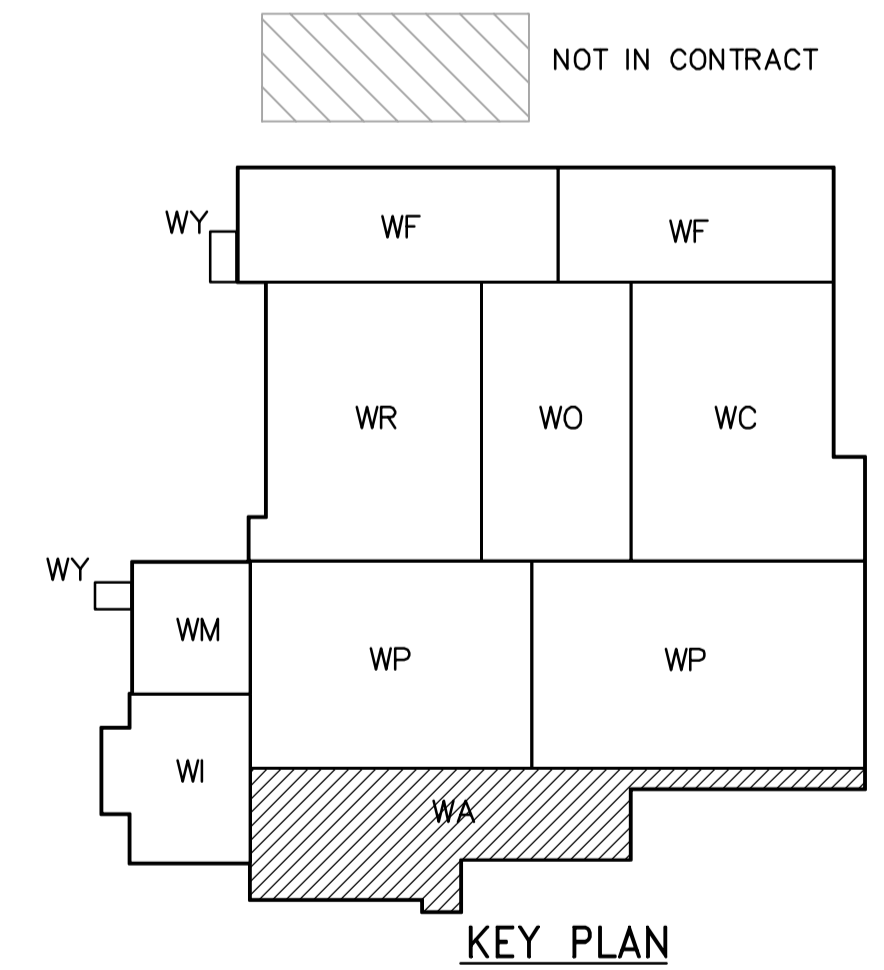

 APEGN Certificate of Authorization CH2M HILL Canada Ltd. No. 1441 Expiry: April 30, 2007	B.M. ELEV.	 Frederickson Cooper ARCHITECTS	 A Terra International Ltd. Company	ENGINEER'S SEAL ORIGINAL SIGNED BY D.K. CUDDINGTON 2006/02/06	 THE CITY OF WINNIPEG WATER AND WASTE DEPARTMENT ENGINEERING DIVISION WATER TREATMENT PLANT ADMINISTRATION MECHANICAL AND ELECTRICAL PLUMBING PIPE EMBEDS ADMINISTRATION AREA SECOND FLOOR PLAN	CITY FILE NUMBER											
	<table border="1"> <tr> <td>01</td> <td>742-2005 ADDENDUM 3</td> <td>06/05/05</td> <td>SW</td> </tr> <tr> <td>00</td> <td>ISSUED FOR TENDER</td> <td>2006/02/03</td> <td>SW</td> </tr> <tr> <td>NO.</td> <td>REVISIONS</td> <td>DATE</td> <td>BY</td> </tr> </table>	01	742-2005 ADDENDUM 3	06/05/05		SW	00	ISSUED FOR TENDER	2006/02/03	SW	NO.	REVISIONS	DATE	BY	DESIGNED BY: JZ/SW CHECKED BY: DL DRAWN BY: JMcP APPROVED BY: DJT SCALE: 1:100 RELEASED FOR CONSTRUCTION BY: R. SOROKOWSKI	CONSULTANT DRAWING NO. WA-H9122	SHEET OF
	01	742-2005 ADDENDUM 3	06/05/05	SW													
	00	ISSUED FOR TENDER	2006/02/03	SW													
NO.	REVISIONS	DATE	BY														
DATE: 2005/07/15 DATE: 2006/02/08	WA-H9122	CITY DRAWING NUMBER 1-0601A-A-H9122-001-01D															