
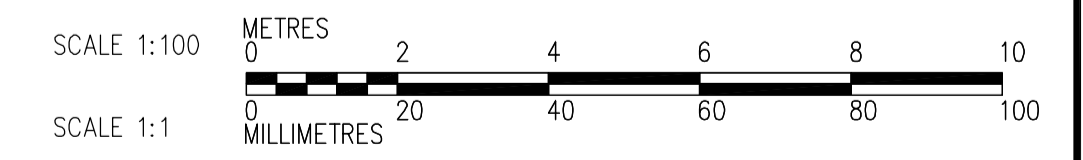


NOTES:
 1. ALL 120V RECEPTICAL IS FED FROM LP-H31.
 2. LUMINAIR FED FROM LP-C11

ROOF POWER AND LIGHTING PLAN
 1:100

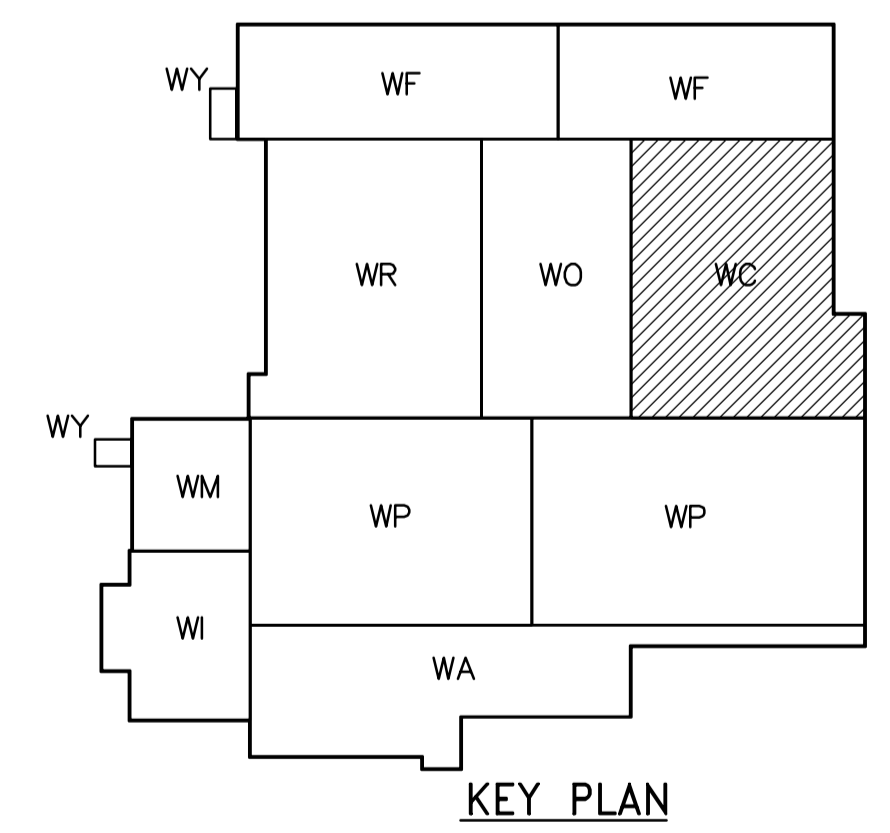

APECA
 Certificate of Authorization
 CH2M HILL Canada Ltd.
 No. 1441 Expiry: April 30, 2007

B.M.	ELEV.

NO.	REVISIONS	DATE	BY
01	742-2005 ADDENDUM 3	06/05/05	LL
00	ISSUED FOR TENDER	06/03/29	LL

CH2MHILL
 Frederickson Cooper
 ARCHITECTS

EarthTech
 A Tyco International Ltd. Company

DESIGNED BY: LL	CHECKED BY: ND
DRAWN BY: TL	APPROVED BY: AHL
SCALE: 1:100	RELEASED FOR CONSTRUCTION BY: R. SOROKOWSKI

ENGINEER'S SEAL
 ORIGINAL SIGNED BY
 L.D. LLEWELLYN
 2006/03/29
 CONSULTANT DRAWING NO.
 WC-E0147

THE CITY OF WINNIPEG
 WATER AND WASTE DEPARTMENT
 ENGINEERING DIVISION

CITY FILE NUMBER
 SHEET OF
 CITY DRAWING NUMBER
 1-0601C-A-E0147-001-01D

WATER TREATMENT PLANT
 CHEMICAL FEED SYSTEMS
 MECHANICAL AND ELECTRICAL

ELECTICAL
 CHEMICAL AREA
 ROOF POWER AND LIGHTING PLAN