


2 DETAIL  
WC-M9111 1:50

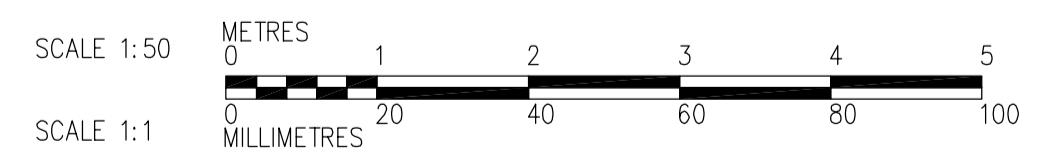

 <b>APEGN</b> Certificate of Authorization CH2M HILL Canada Ltd. No. 1441 Expiry: April 30, 2007	B.M. ELEV.	 Frederickson Cooper ARCHITECTS	 A Terra International Ltd. Company	ENGINEER'S SEAL  ORIGINAL SIGNED BY J.W. SINCLAIR  2006/02/06	 <b>THE CITY OF WINNIPEG</b> WATER AND WASTE DEPARTMENT ENGINEERING DIVISION					
	<table border="1" style="width:100%; border-collapse: collapse;"> <tr> <td style="width:50%;">01 742-2005 ADDENDUM 3 06/05/05 KS</td> <td style="width:50%;">DESIGNED BY KS CHECKED BY NW</td> </tr> <tr> <td>00 ISSUED FOR TENDER 2006/02/03 KS</td> <td>DRAWN BY YFS APPROVED BY DJT</td> </tr> <tr> <td>NO. REVISIONS DATE BY DATE 2005/10/14 DATE 2006/02/08</td> <td>SCALE: 1:50 RELEASED FOR CONSTRUCTION BY: R. SOROKOWSKI</td> </tr> </table>	01 742-2005 ADDENDUM 3 06/05/05 KS	DESIGNED BY KS CHECKED BY NW	00 ISSUED FOR TENDER 2006/02/03 KS	DRAWN BY YFS APPROVED BY DJT	NO. REVISIONS DATE BY DATE 2005/10/14 DATE 2006/02/08	SCALE: 1:50 RELEASED FOR CONSTRUCTION BY: R. SOROKOWSKI	CONSULTANT DRAWING NO. WC-M9402	WATER TREATMENT PLANT CHEMICAL FEED SYSTEMS MECHANICAL AND ELECTRICAL	CITY FILE NUMBER SHEET OF CITY DRAWING NUMBER 1-0601C-A-M9402-001-01D
	01 742-2005 ADDENDUM 3 06/05/05 KS	DESIGNED BY KS CHECKED BY NW								
00 ISSUED FOR TENDER 2006/02/03 KS	DRAWN BY YFS APPROVED BY DJT									
NO. REVISIONS DATE BY DATE 2005/10/14 DATE 2006/02/08	SCALE: 1:50 RELEASED FOR CONSTRUCTION BY: R. SOROKOWSKI									
PROCESS MECHANICAL PIPE EMBEDS POLYMER AREA SECOND FLOOR PLAN DETAIL										