



PARTIAL FIRST FLOOR PLAN
1:100

LOWER LEVEL PLAN
1:100

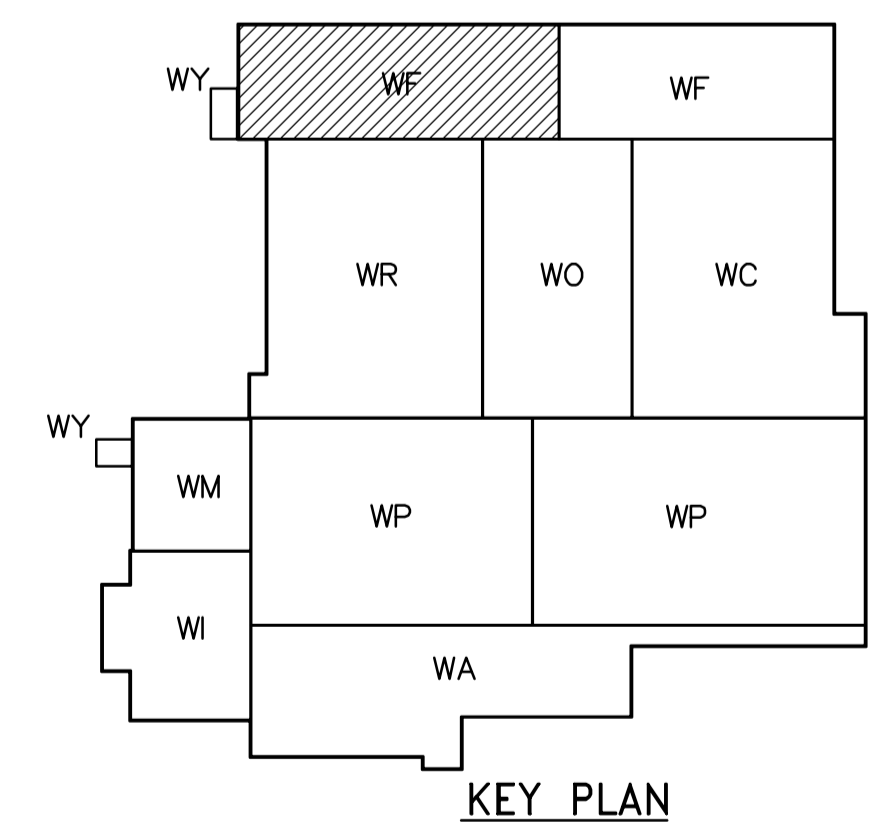

KEY PLAN

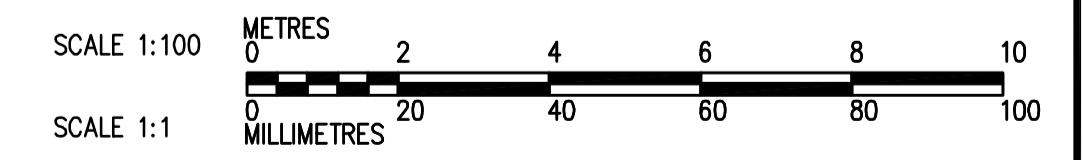

<p>APEGN Certificate of Authorization CH2M HILL Canada Ltd. No. 1441 Expiry: April 30, 2007</p>	<p>Frederickson Cooper ARCHITECTS</p>		<p>EarthTech A Tyco International Ltd. Company</p>		ENGINEER'S SEAL ORIGINAL SIGNED BY D.K. CUDDINGTON 2006/02/06	<p>THE CITY OF WINNIPEG WATER AND WASTE DEPARTMENT ENGINEERING DIVISION</p>	WATER TREATMENT PLANT FILTRATION MECHANICAL AND ELECTRICAL	CITY FILE NUMBER SHEET OF
	DESIGNED BY JZ/SW DRAWN BY JMcP		CHECKED BY DL APPROVED BY DJT		CONSULTANT DRAWING NO. WF-H9104		PLUMBING PIPE EMBEDS FILTRATION AREA 1 LOWER LEVEL PLAN	CITY DRAWING NUMBER 1-0601F-A-H9104-001-02D
	SCALE: 1:100		RELEASED FOR CONSTRUCTION BY: R. SOROKOWSKI				DATE 2005/08/02	DATE 2006/02/08
	NO. REVISIONS DATE BY		B.M. ELEV.					