




LOWER LEVEL PLAN
1:100

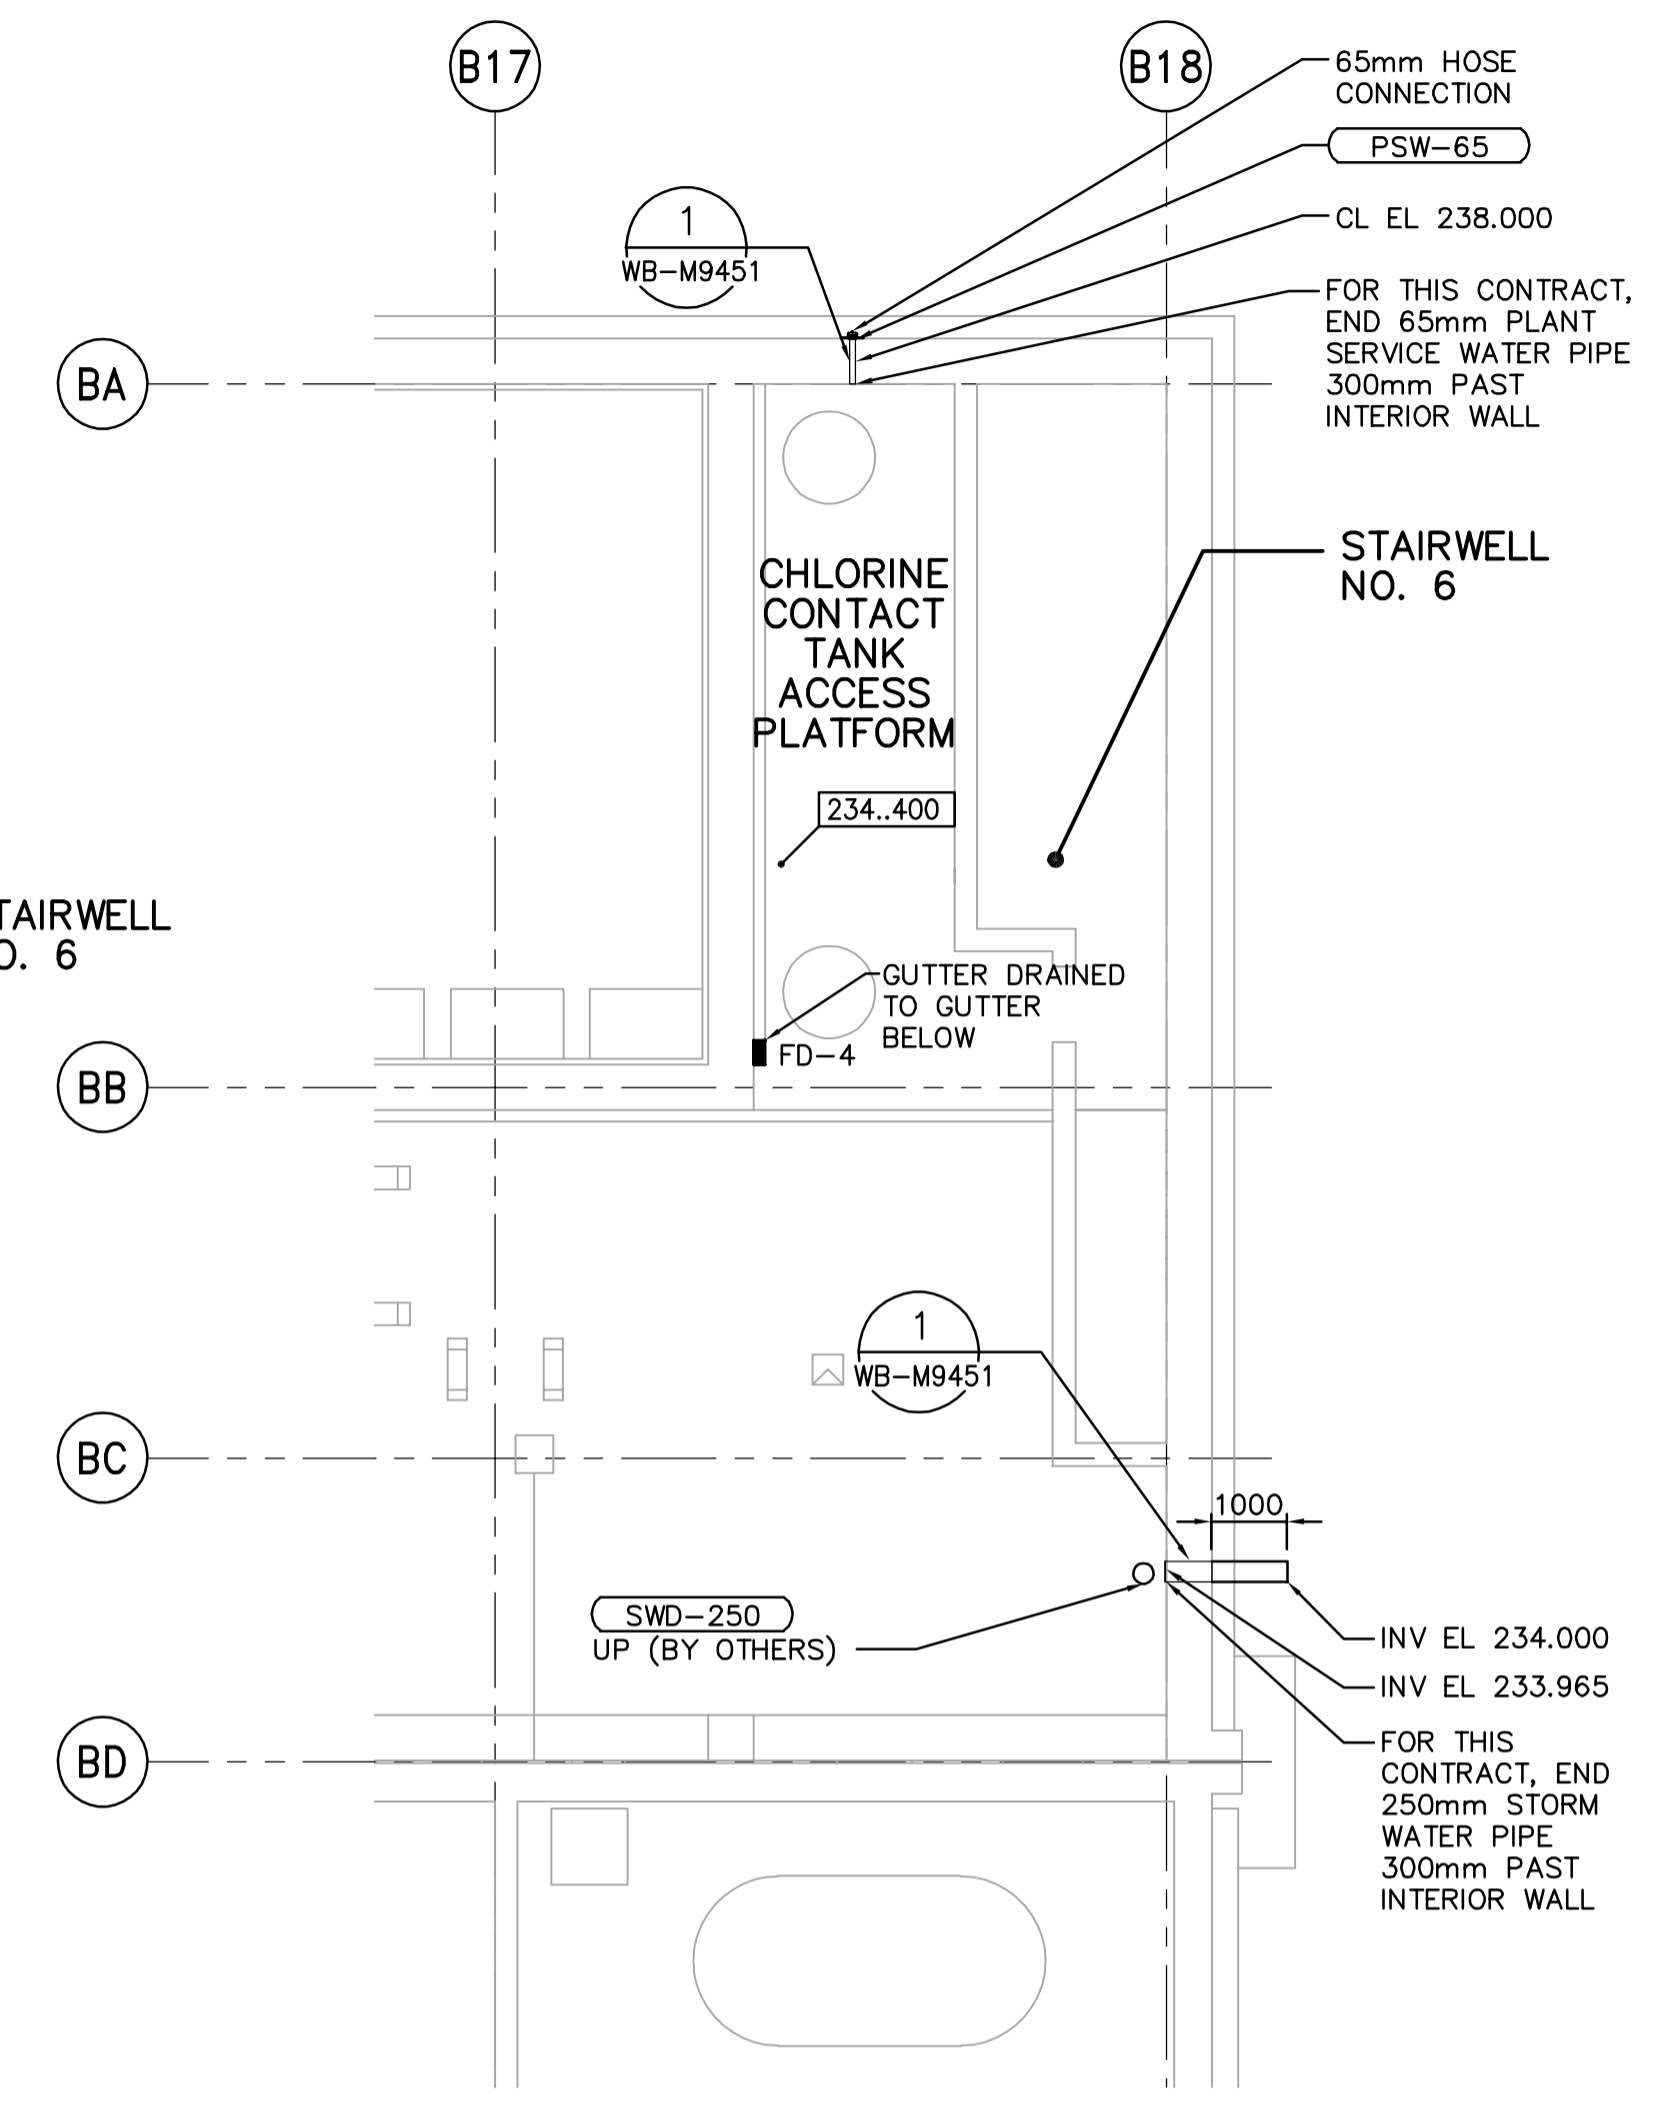


PARTIAL FIRST FLOOR PLAN
1:100

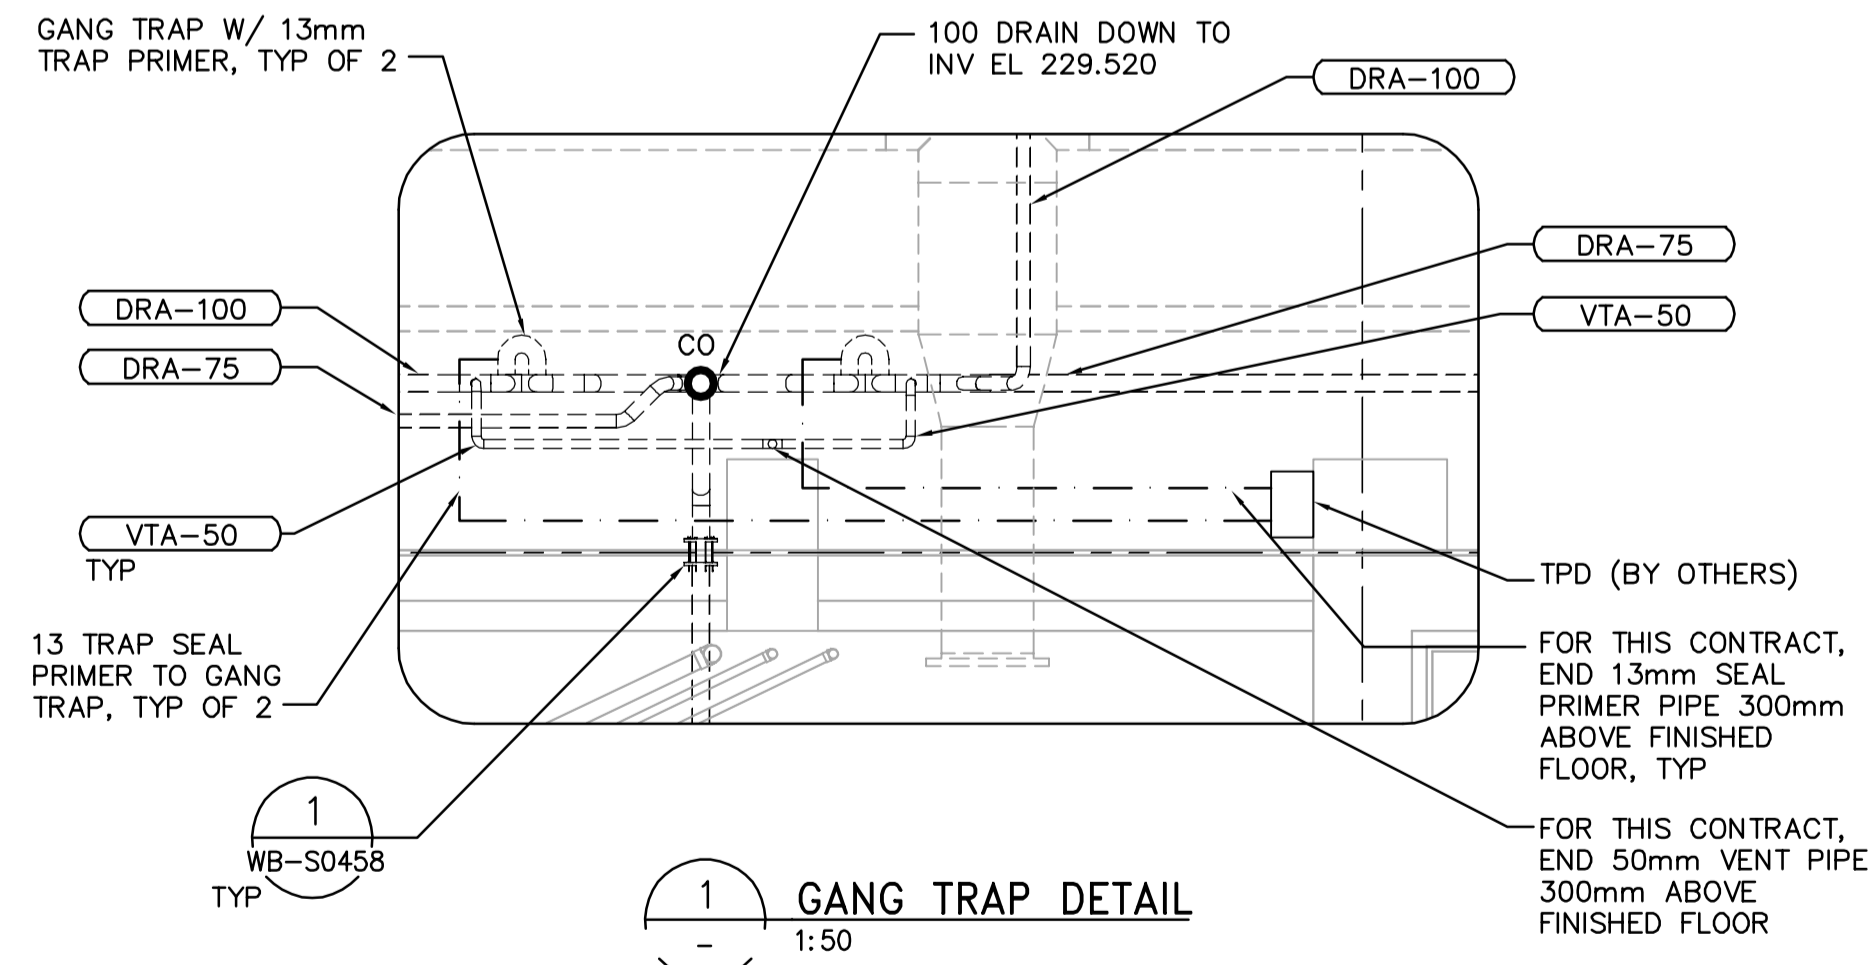

GANG TRAP DETAIL
1:50

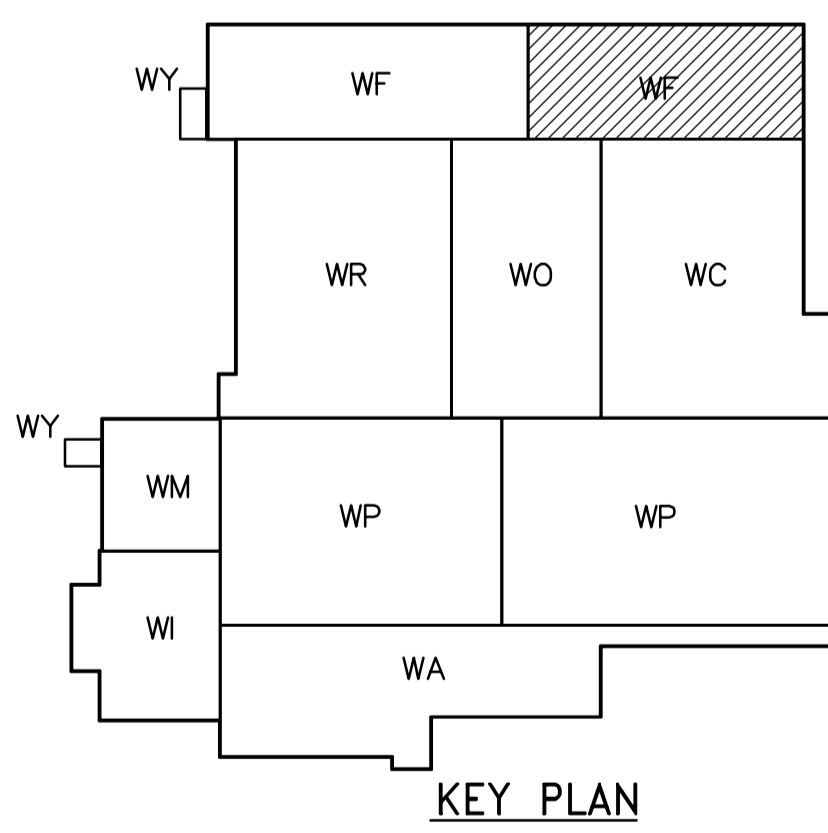

KEY PLAN

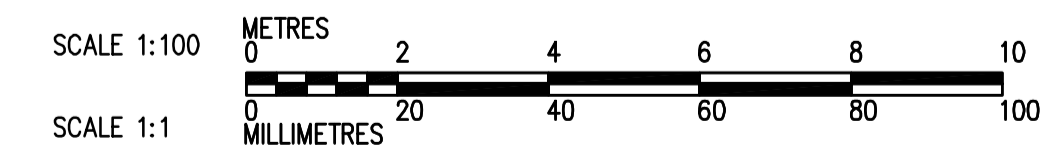

<p>APEGN Certificate of Authorization CH2M HILL Canada Ltd. No. 1441 Expiry: April 30, 2007</p>	<p>B.M. ELEV.</p> <table border="1"> <tr><td> </td><td> </td><td> </td></tr> <tr><td> </td><td> </td><td> </td></tr> <tr><td> </td><td> </td><td> </td></tr> <tr><td> </td><td> </td><td> </td></tr> </table>													<p>Frederickson Cooper ARCHITECTS</p>	<p>A Terra International Ltd. Company</p>	ENGINEER'S SEAL	<p>THE CITY OF WINNIPEG WATER AND WASTE DEPARTMENT ENGINEERING DIVISION</p>
DESIGNED BY JZ/SW	CHECKED BY DL	ORIGINAL SIGNED BY D.K. CUDDINGTON	CITY FILE NUMBER														
DRAWN BY JMcP	APPROVED BY DJT	2006/02/06	SHEET OF														
SCALE: 1:100	RELEASED FOR CONSTRUCTION BY: R. SOROKOWSKI	CONSULTANT DRAWING NO. WF-H9105	CITY DRAWING NUMBER 1-0601F-A-H9105-001-01D														
NO. REVISIONS	DATE BY	DATE 2005/08/02	DATE 2006/02/08	<p>PLUMBING PIPE EMBEDS FILTRATION AREA 2 LOWER LEVEL PLAN</p>													