
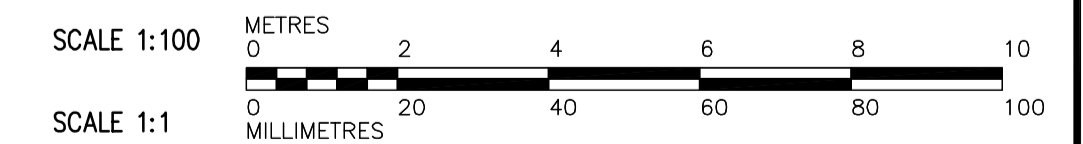


PLAN AT ELEVATION 245.000
1:100

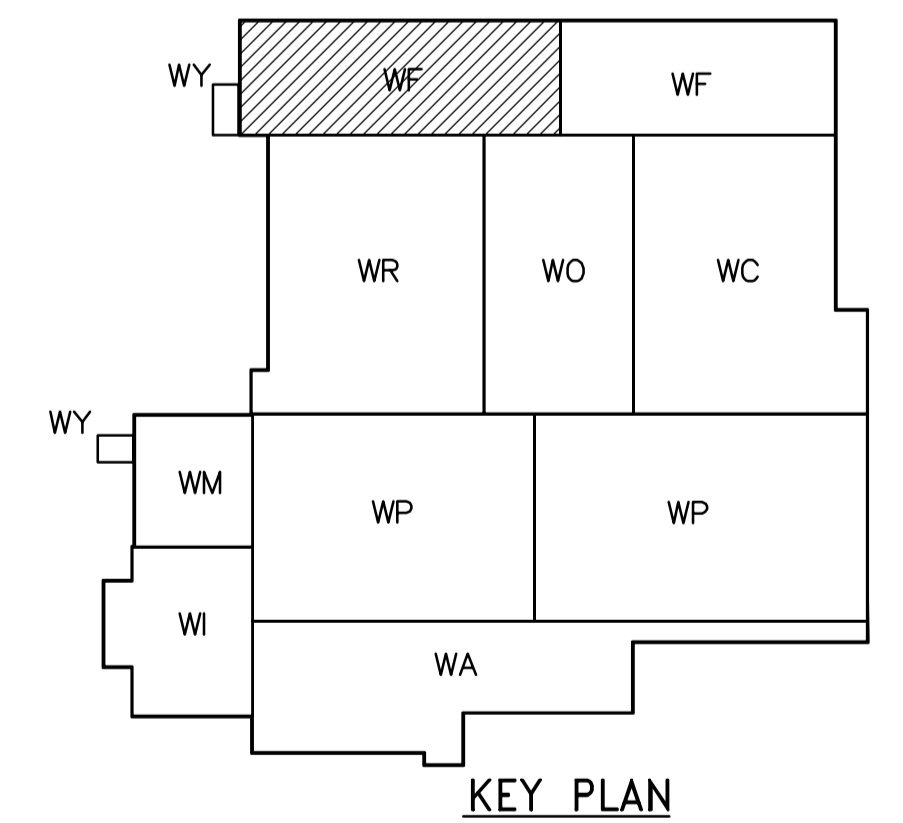

 APEGN Certificate of Authorization CH2M HILL Canada Ltd. No. 1441 Expiry: April 30, 2007	 Frederickson Cooper ARCHITECTS	 A Terra International Ltd. Company	ENGINEER'S SEAL ORIGINAL SIGNED BY P. WOBMA 2006/02/06	 THE CITY OF WINNIPEG WATER AND WASTE DEPARTMENT ENGINEERING DIVISION	CITY FILE NUMBER SHEET OF
	DESIGNED BY TB/PW CHECKED BY LS DRAWN BY TAR/EK APPROVED BY DJT			WATER TREATMENT PLANT FILTRATION MECHANICAL AND ELECTRICAL	CITY DRAWING NUMBER 1-0601F-A-M9131-001-01D
	SCALE: 1:100 RELEASED FOR CONSTRUCTION BY: R. SOROKOWSKI			PROCESS MECHANICAL PIPE EMBEDS FILTRATION AREA 1 THIRD FLOOR PLAN	
	INO. REVISIONS DATE BY DATE 2005/07/08 DATE 2006/02/08			CONSULTANT DRAWING NO. WF-M9131	