




LOWER LEVEL PLAN
1:50

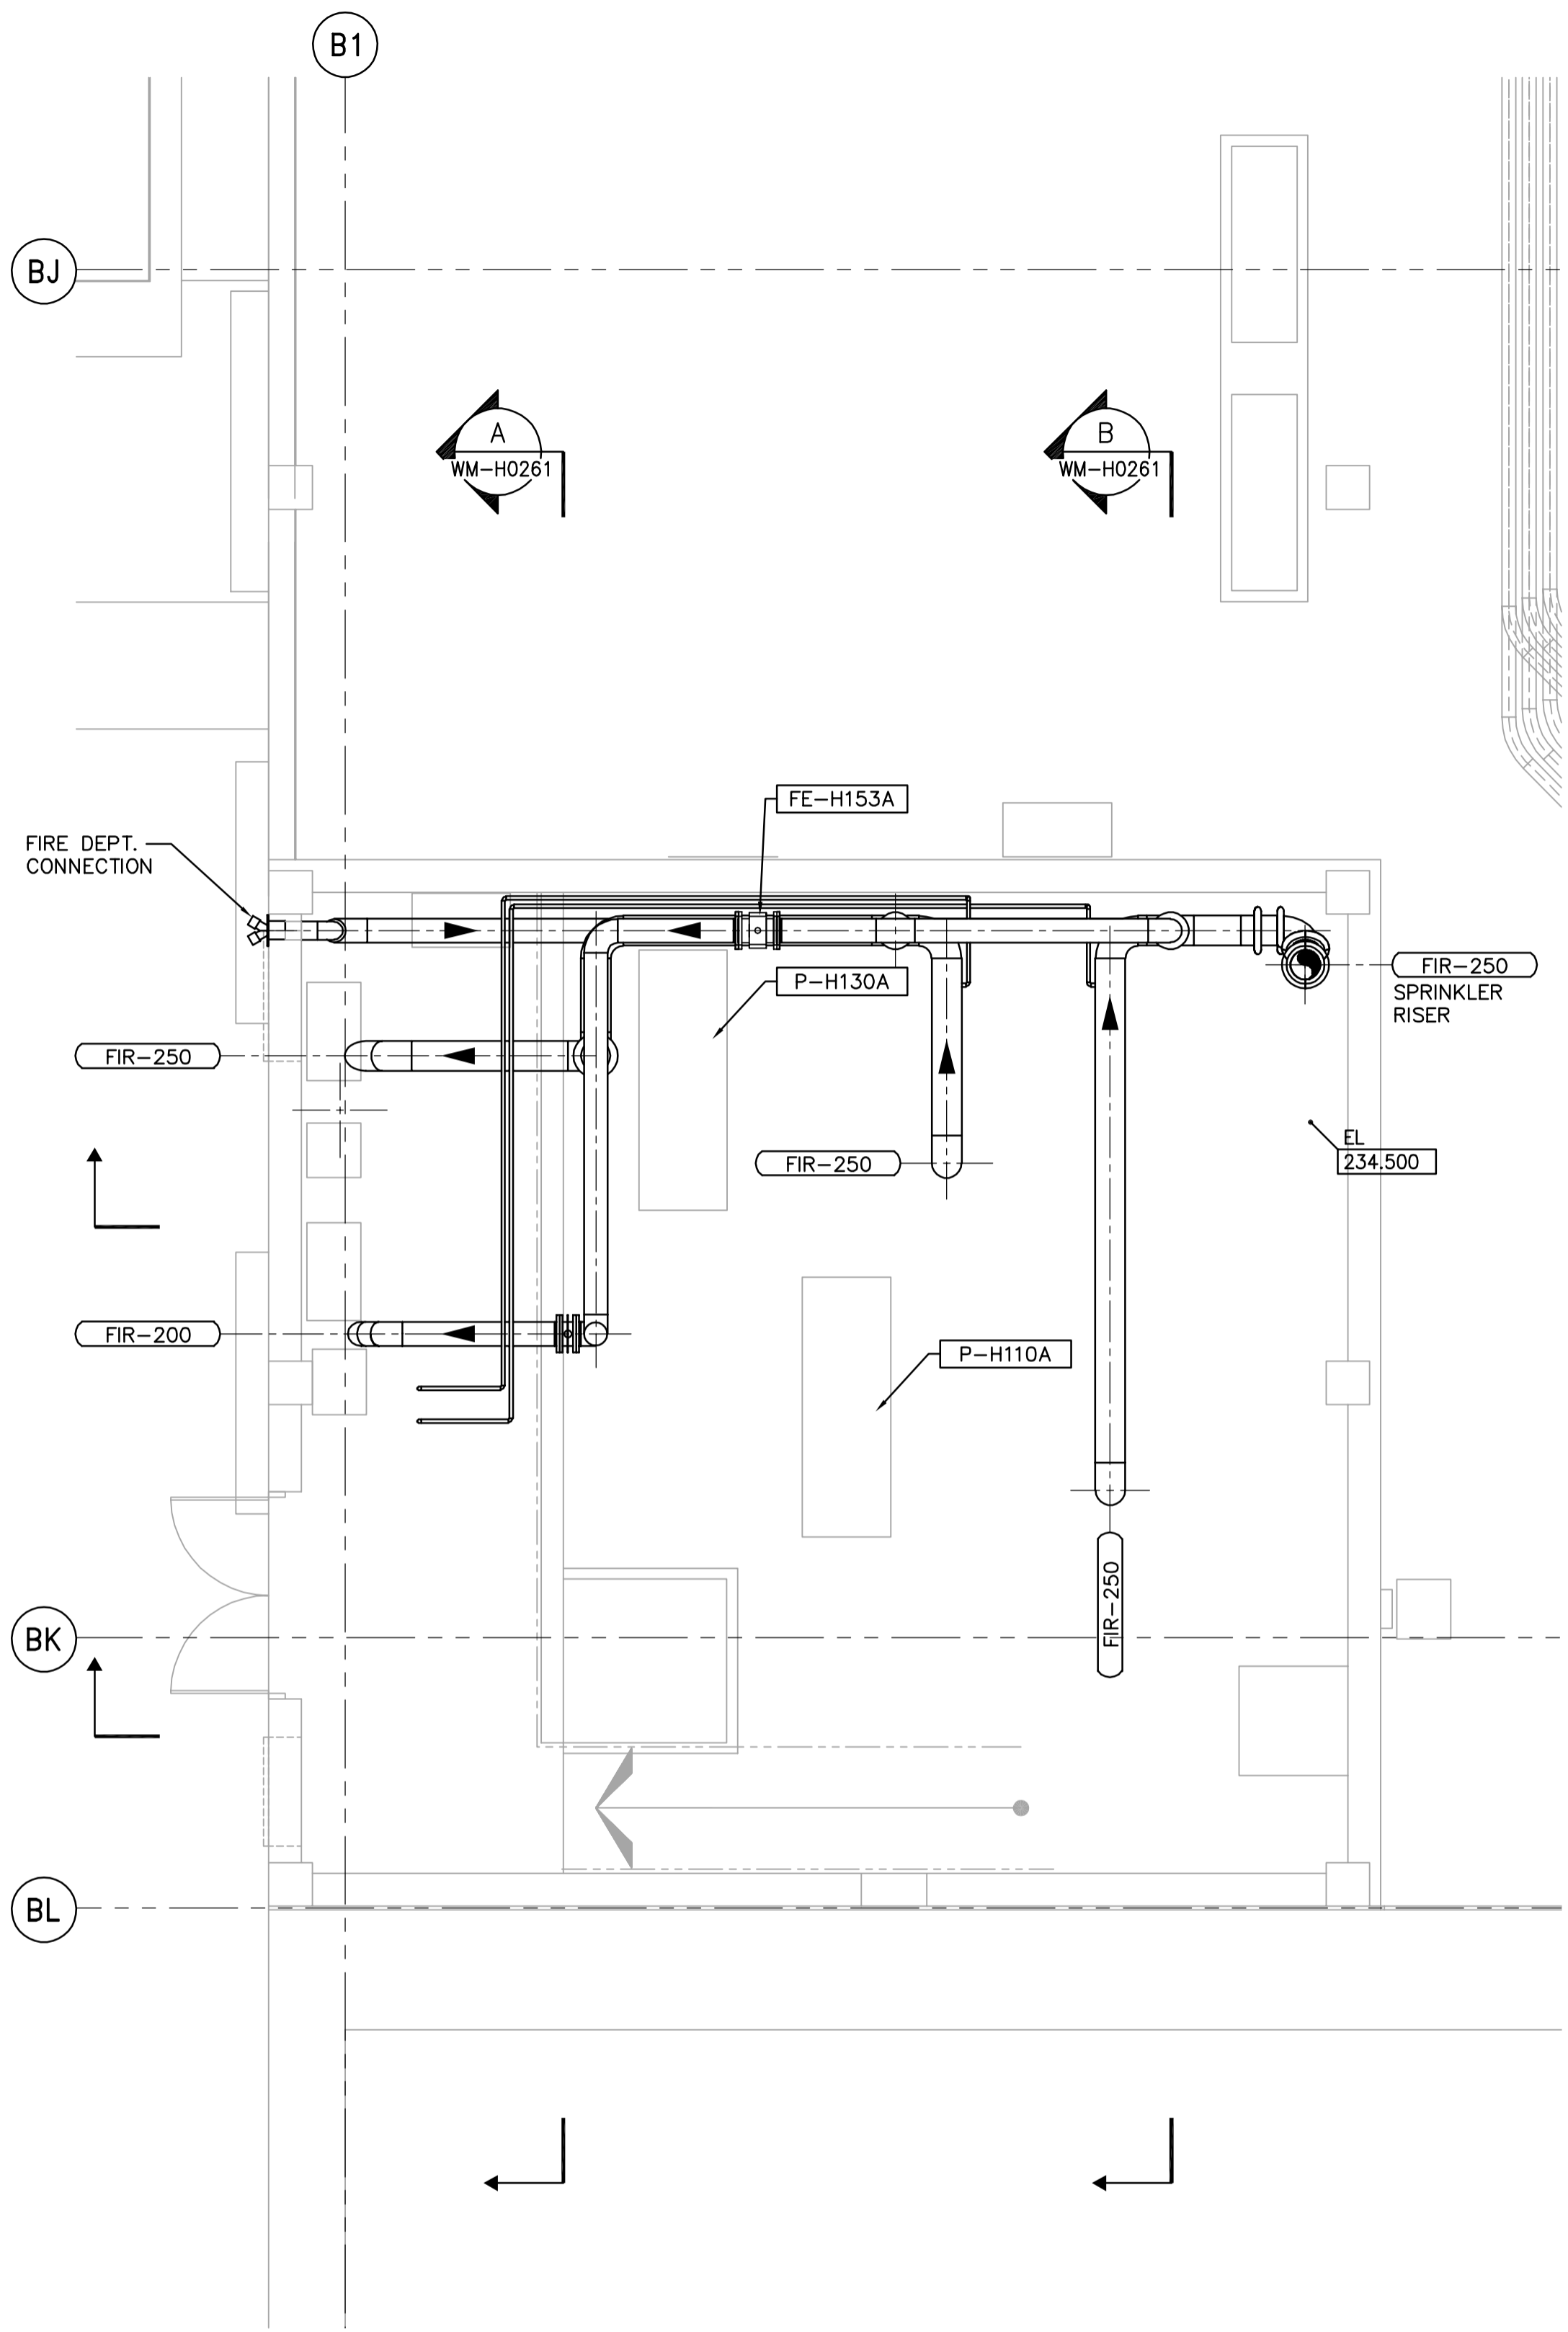

FIRST FLOOR PLAN
1:50

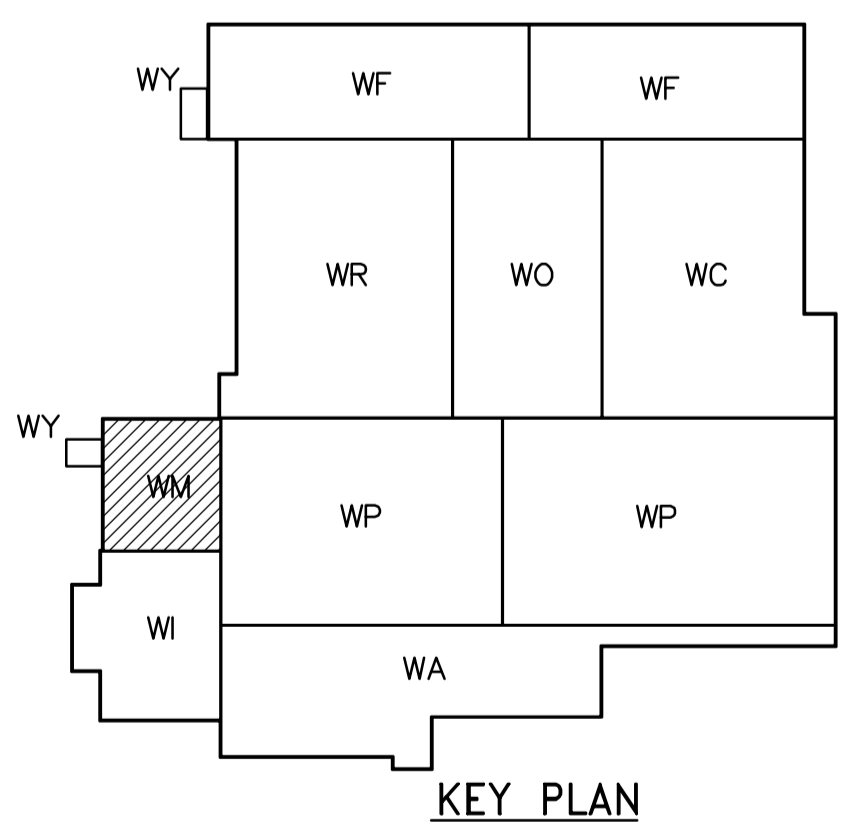

KEY PLAN

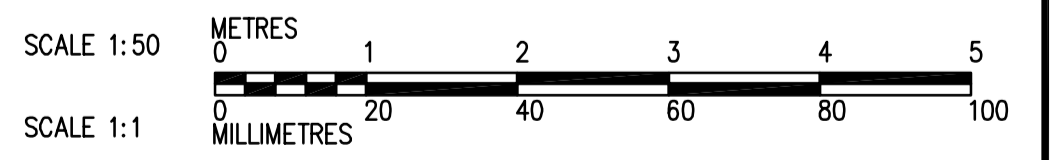

 Certificate of Authorization CH2M HILL Canada Ltd. No. 1441 Expiry: April 30, 2007	B.M. ELEV.		 Frederickson Cooper ARCHITECTS		 A You International Ltd. Company		ENGINEER'S SEAL ORIGINAL SIGNED BY D.K. CUDDINGTON 2006/03/29		 THE CITY OF WINNIPEG WATER AND WASTE DEPARTMENT ENGINEERING DIVISION	
	DESIGNED BY DKC DRAWN BY JMcP		CHECKED BY SW APPROVED BY AHL		SCALE: 1:50		RELEASED FOR CONSTRUCTION BY: R. SOROKOWSKI		WATER TREATMENT PLANT GENERAL PLANT SERVICES/MISCELLANEOUS MECHANICAL AND ELECTRICAL	
	NO. REVISIONS DATE BY		DATE 2006/01/06 DATE 2006/03/29		CONSULTANT DRAWING NO. WM-H0113		FIRE PROTECTION FIRE PUMP ROOM LOWER LEVEL AND FIRST FLOOR PLANS			
									CITY FILE NUMBER SHEET OF CITY DRAWING NUMBER 1-0601M-A-H0113-001-01D	