

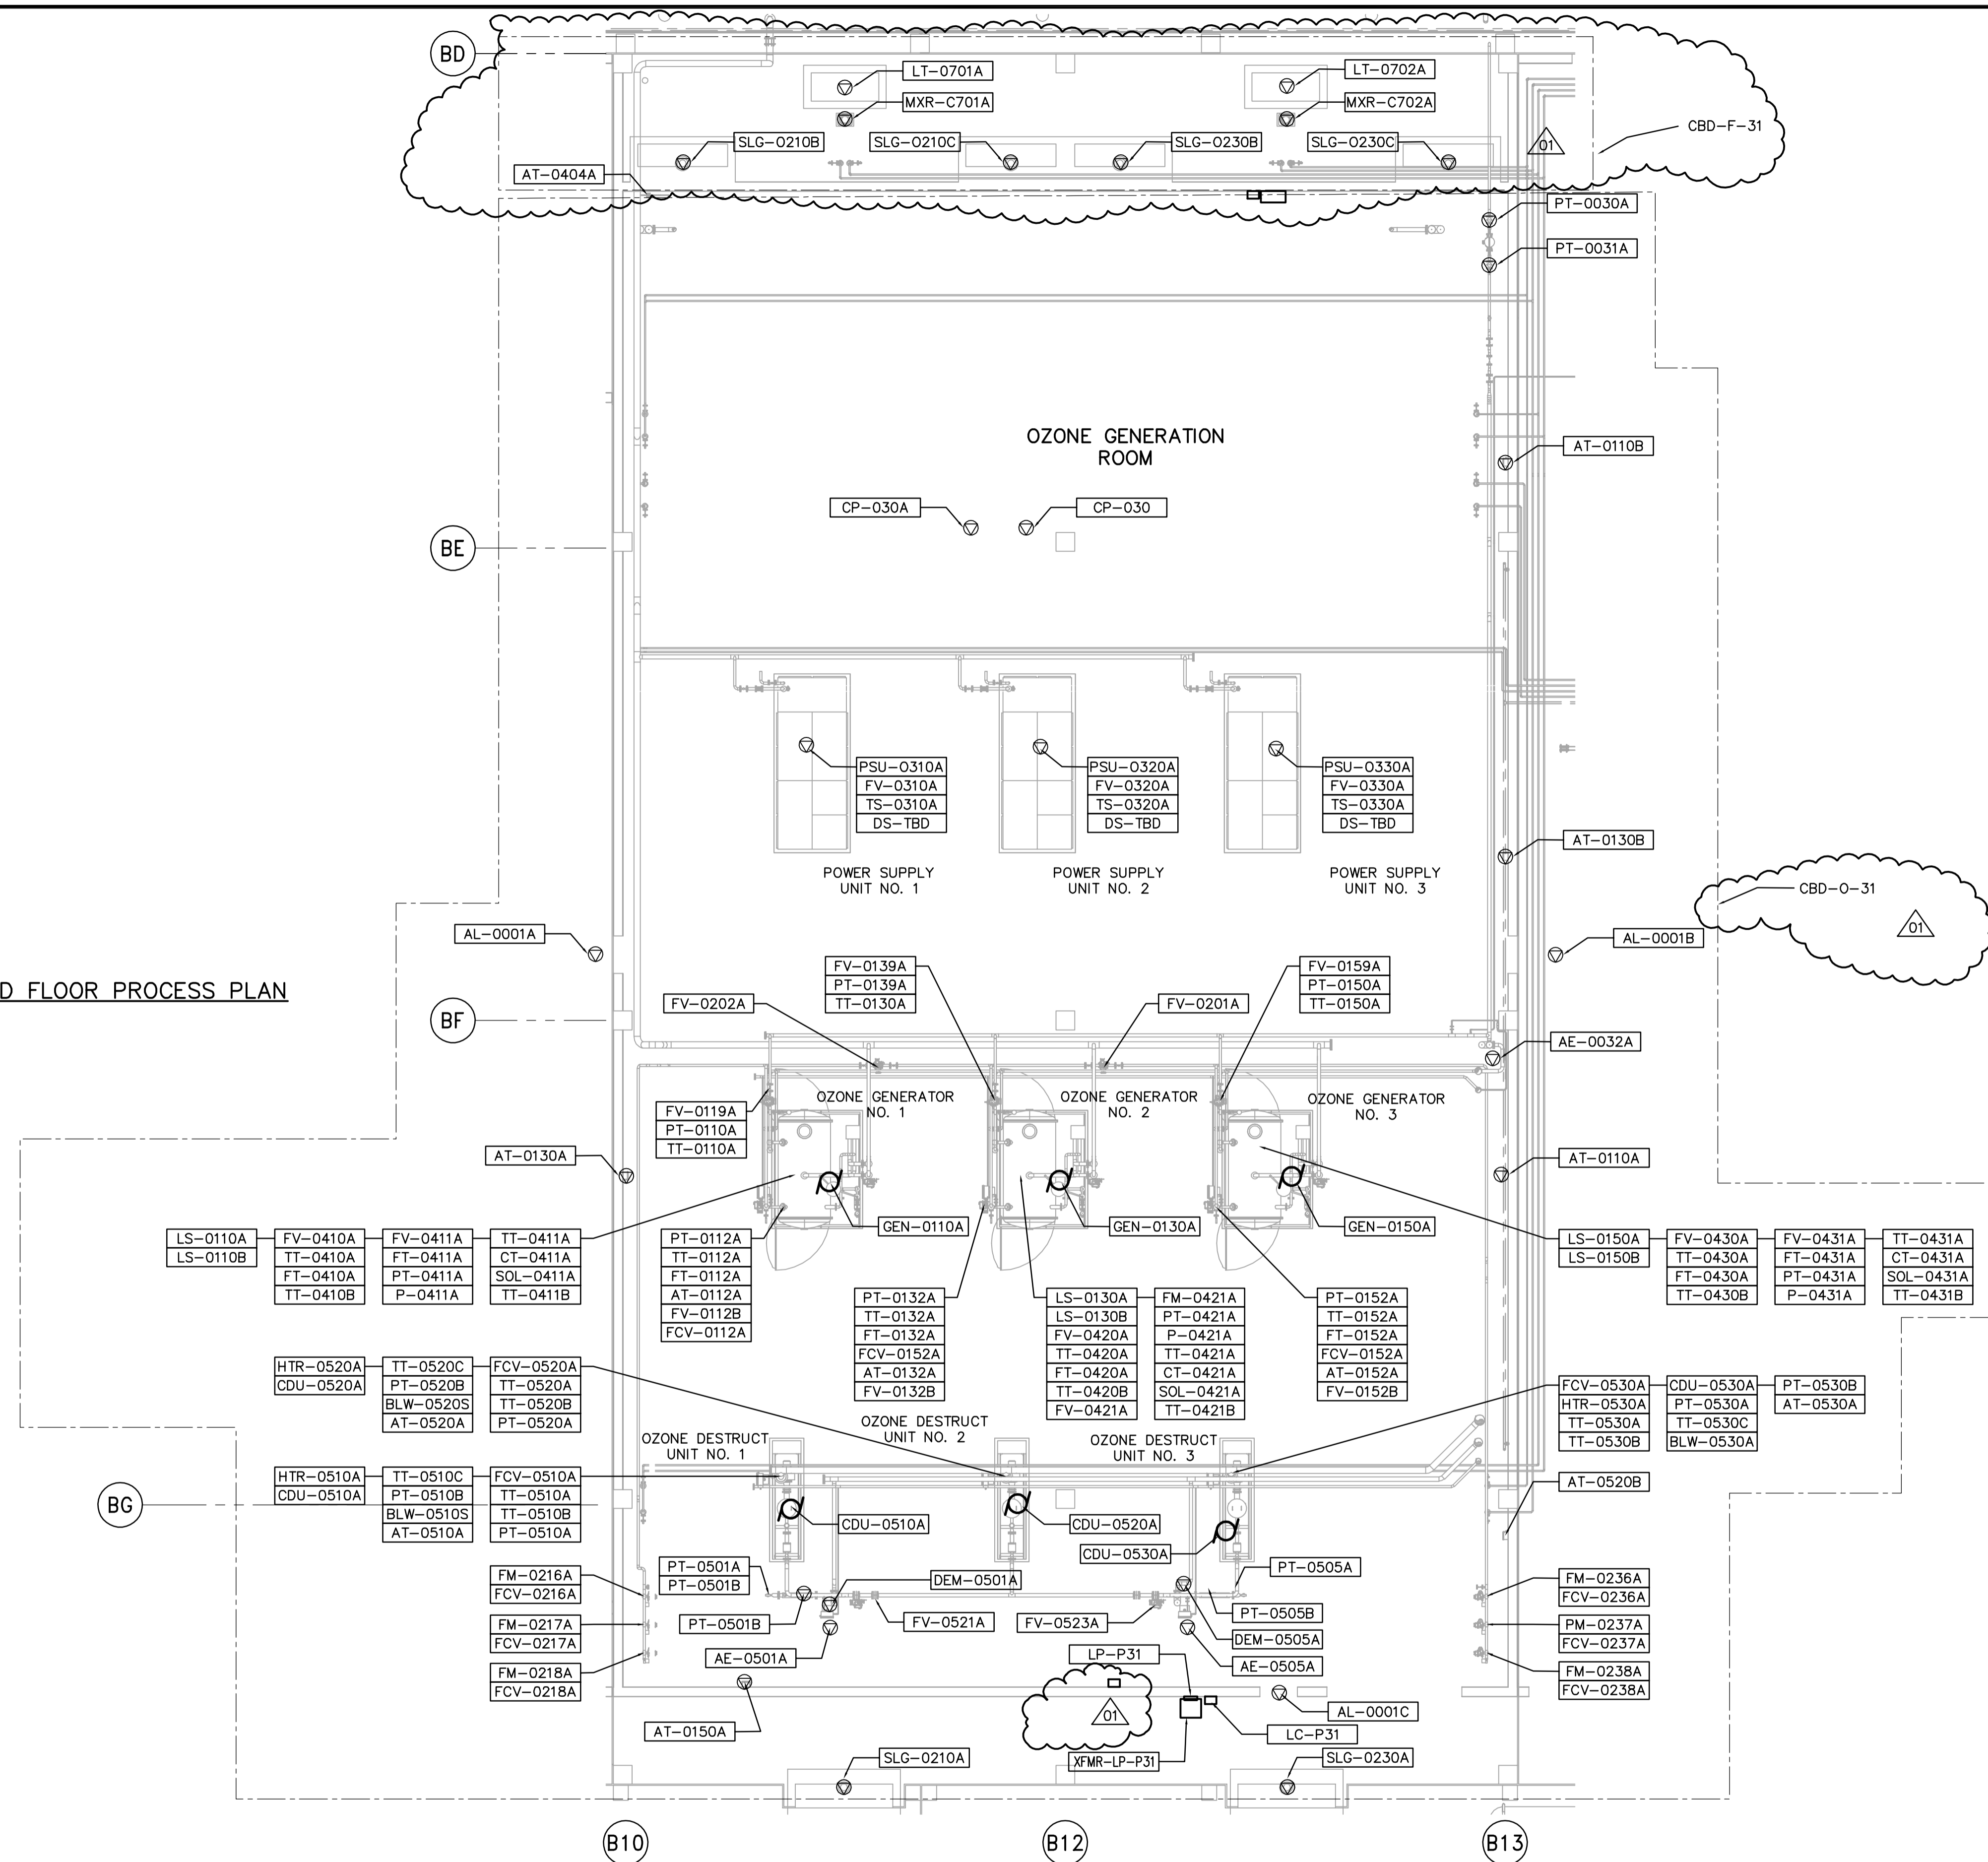


THIRD FLOOR PROCESS PLAN
1:100

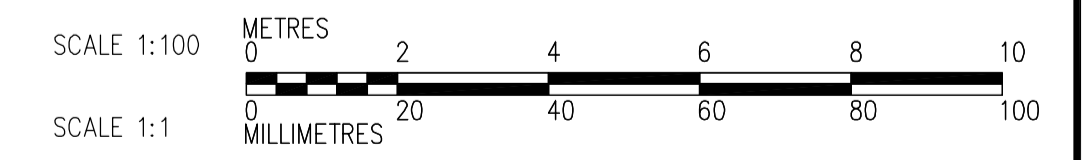

NOTES:
1. SEE MCC 4A & 4B SINGLE LINE DIAGRAMS AND PANEL SCHEDULES DP-H31 & DP-H32 FOR 600V POWER DISTRIBUTION.

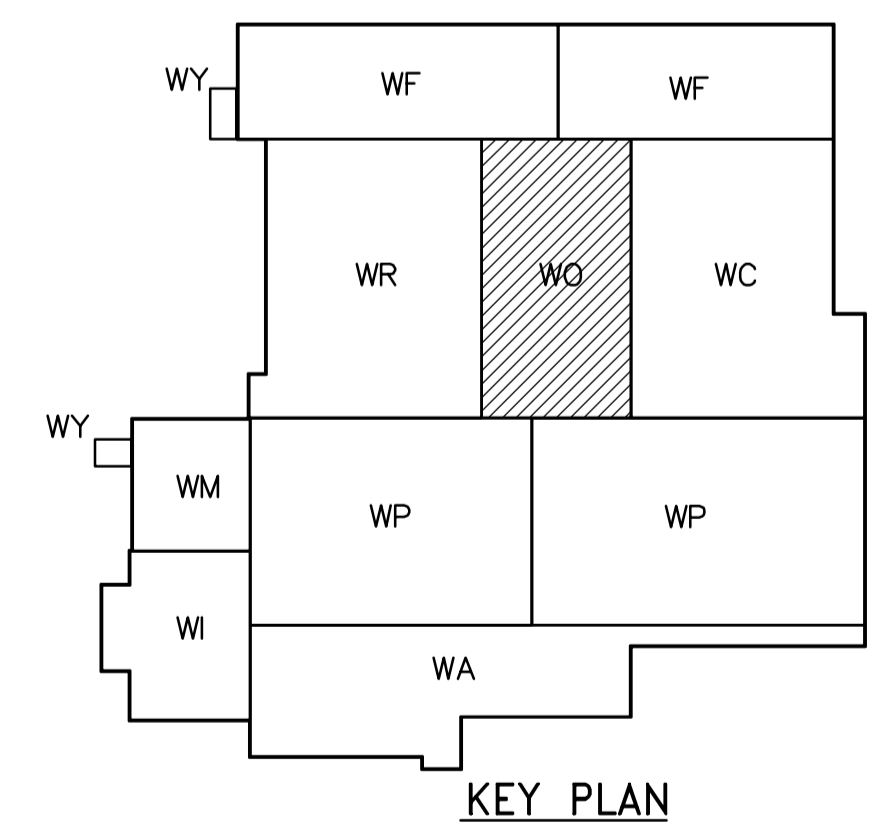

 APEGN Certificate of Authorization CH2M HILL Canada Ltd. No. 1441 Expiry: April 30, 2007	B.M. ELEV.	 Frederickson Cooper ARCHITECTS	 A Yeo International Ltd. Company	ENGINEER'S SEAL ORIGINAL SIGNED BY L.D. LLEWELLYN 2006/03/29	 THE CITY OF WINNIPEG WATER AND WASTE DEPARTMENT ENGINEERING DIVISION WATER TREATMENT PLANT OZONE MECHANICAL AND ELECTRICAL ELECTRICAL OZONATION AREA THIRD FLOOR PROCESS PLAN	CITY FILE NUMBER
	DESIGNED BY LL CHECKED BY ND DRAWN BY TL APPROVED BY AHL	CONSULTANT DRAWING NO. WO-E0132	SHEET OF			
	SCALE: 1:100 RELEASED FOR CONSTRUCTION BY: R. SOROKOWSKI DATE 2006/03/29	CITY DRAWING NUMBER 1-06010-A-E0132-001-01D				