
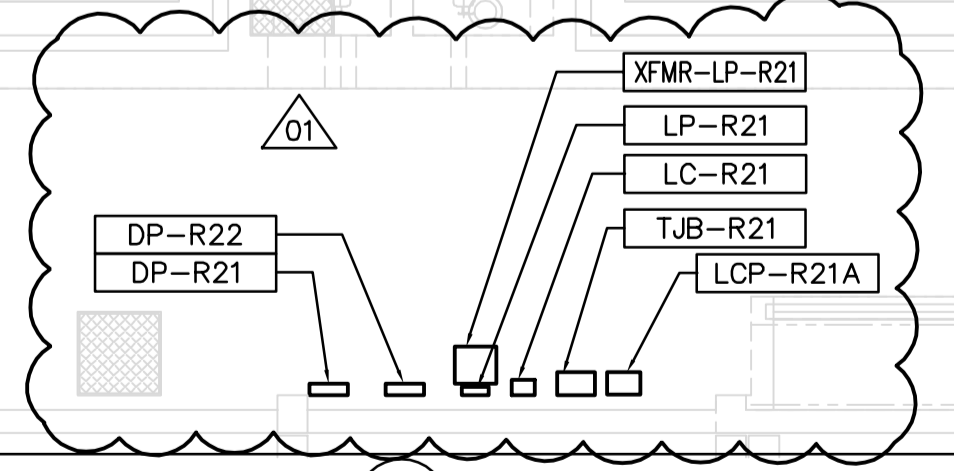
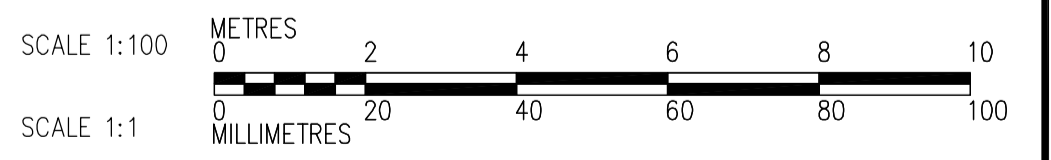


NOTES:  
1. SEE PANEL SCHEDULES DP-R21 & DP-R22 FOR 600V POWER DISTRIBUTION

SECOND FLOOR PROCESS PLAN  
1:100

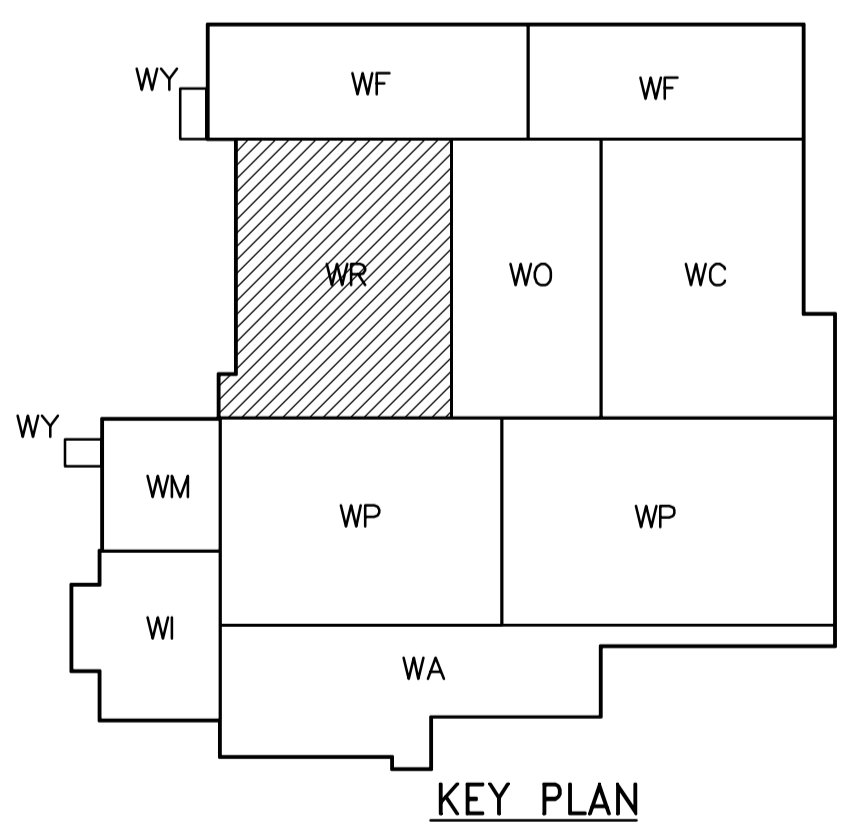

<p><b>APEGN</b> Certificate of Authorization CH2M HILL Canada Ltd. No. 1441 Expiry: April 30, 2007</p>	B.M. ELEV.	<p>Frederickson Cooper ARCHITECTS</p>	<p>EarthTech A Yoo International Ltd. Company</p>	ENGINEER'S SEAL	<p><b>THE CITY OF WINNIPEG</b> WATER AND WASTE DEPARTMENT ENGINEERING DIVISION</p>													
				DESIGNED BY LL		CHECKED BY ND	ORIGINAL SIGNED BY L.D. LLEWELLYN											
		DRAWN BY TL	APPROVED BY AHL	2006/03/29		WATER TREATMENT PLANT RESIDUALS HANDLING MECHANICAL AND ELECTRICAL												
	<table border="1"> <tr> <td>01</td> <td>742-2005 ADDENDUM 3</td> <td>06/05/05</td> <td>LL</td> </tr> <tr> <td>00</td> <td>ISSUED FOR TENDER</td> <td>06/03/29</td> <td>LL</td> </tr> </table>	01	742-2005 ADDENDUM 3	06/05/05		LL	00	ISSUED FOR TENDER	06/03/29	LL	SCALE: 1:100	RELEASED FOR CONSTRUCTION BY: R. SOROKOWSKI	CONSULTANT DRAWING NO. WR-E0122	<table border="1"> <tr> <td>CITY FILE NUMBER</td> <td></td> </tr> <tr> <td>SHEET OF</td> <td></td> </tr> <tr> <td>CITY DRAWING NUMBER</td> <td>1-0601R-A-E0122-001-01D</td> </tr> </table>	CITY FILE NUMBER		SHEET OF	
01	742-2005 ADDENDUM 3	06/05/05	LL															
00	ISSUED FOR TENDER	06/03/29	LL															
CITY FILE NUMBER																		
SHEET OF																		
CITY DRAWING NUMBER	1-0601R-A-E0122-001-01D																	