



PLAN VIEW AT ELEVATION 239.000  
1:50

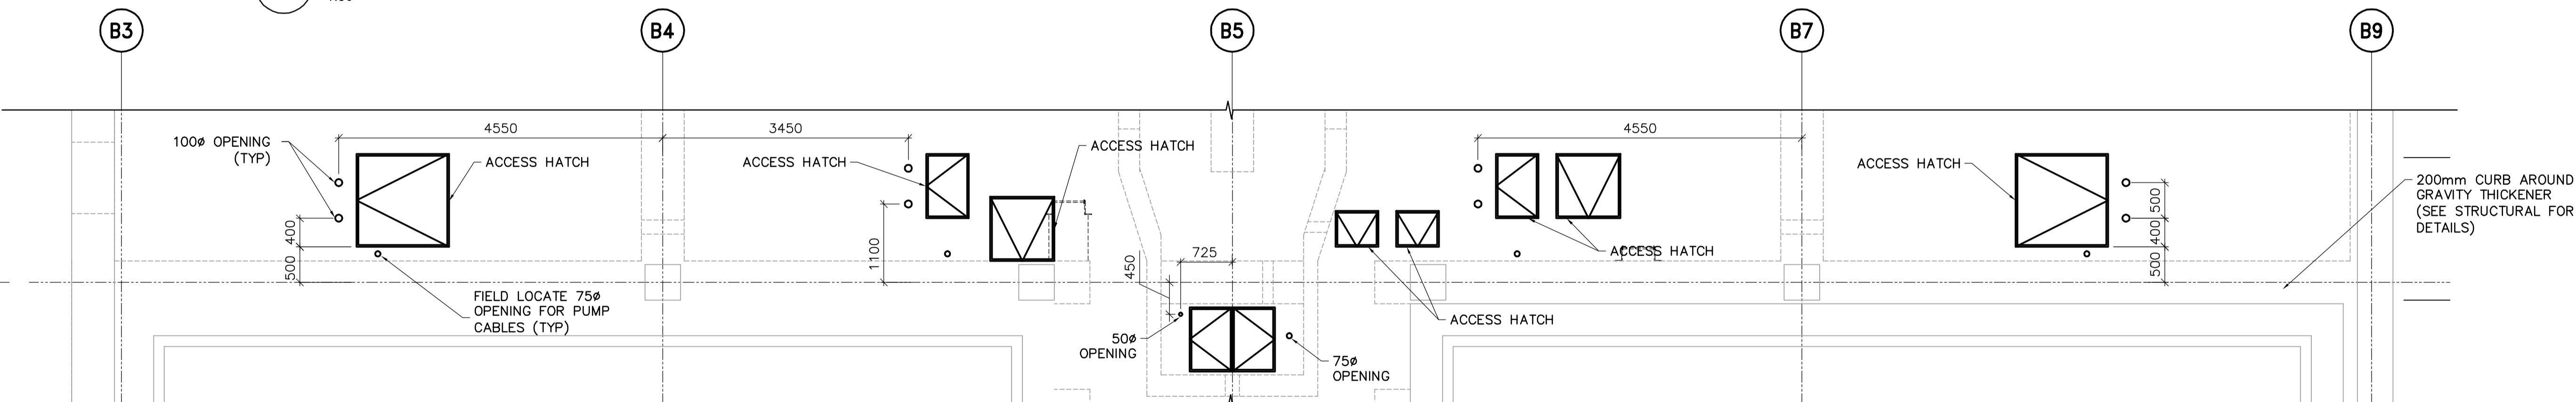

PLAN VIEW AT ELEVATION 239.410  
1:50

FOR CONTINUATION  
SEE DWG WR-M9112

FOR CONTINUATION  
SEE DWG WR-M9123

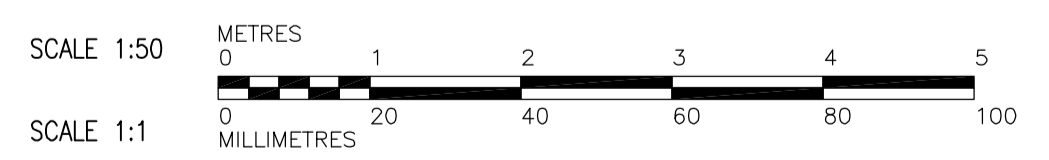

**APECA**  
Certificate of Authorization  
Earth Tech Canada Inc.  
No. 730 Expiry: April 30, 2007

B.M. ELEV.			
DESIGNED BY	SM	CHECKED BY	SRB
DRAWN BY	JBC	APPROVED BY	DJT
SCALE:	1:50		
NO.	REVISIONS	DATE	BY
01	742-2005 ADDENDUM 3	06/05/03	LAE
00	ISSUED FOR TENDER	06/02/03	JBC
DATE	2005/09/29	DATE	2006/02/07

**CH2M HILL**  
Frederickson Cooper  
ARCHITECTS

**EarthTech**  
A Tyco International Ltd. Company

RELEASSED FOR CONSTRUCTION BY:  
R. SOROKOWSKI

ENGINEER'S SEAL  
ORIGINAL SIGNED BY  
S.R. BILEVICIUS  
2006/02/07  
CONSULTANT DRAWING NO.  
WR-M9113

**THE CITY OF WINNIPEG**  
WATER AND WASTE DEPARTMENT  
ENGINEERING DIVISION

WATER TREATMENT PLANT  
RESIDUALS HANDLING  
FOUNDATIONS AND CONCRETE STRUCTURES

PIPE EMBEDS  
WASHWATER RECOVERY TANKS  
PROCESS PIPING PLAN

CITY FILE NUMBER  
SHEET OF  
CITY DRAWING NUMBER  
1-0601R-A-M9113-001-01D