



# THE CITY OF WINNIPEG

PUBLIC WORKS DEPARTMENT  
ENGINEERING DIVISION


## KENASTON UNDERPASS PROJECT BID OPPORTUNITY No. 83-2005

### STERLING LYON PARKWAY (EAST) ROAD WORKS, LDS AND MISCELLANEOUS UNDERGROUND WORKS

#### DRAWING INDEX

P-3258-01	113703042-G00	COVER & DRAWING LIST
P-3258-02	113703042-G01	SITE PLAN - LIMITS OF WORKS
P-3258-03	113703042-H01	HORIZONTAL GEOMETRY - NORTH AND SOUTH CONTROL LINE
<u>KENASTON BOULEVARD</u>		
P-3258-04	113703042-H02	HORIZONTAL GEOMETRY - STA 0+685.069 TO STA 1+062.085
<u>STERLING LYON PARKWAY</u>		
P-3258-05	113703042-H03	HORIZONTAL GEOMETRY - KENASTON BOULEVARD TO STA 2+750
P-3258-06	113703042-H04	HORIZONTAL GEOMETRY - STA 2+750 TO STA 3+025
P-3258-07	113703042-H05	HORIZONTAL GEOMETRY - STA 3+025 TO STA 3+325
P-3258-08	113703042-H06	HORIZONTAL GEOMETRY - STA 3+325 TO STA 3+625
P-3258-09	113703042-H07	HORIZONTAL GEOMETRY - STA 3+625 TO STA 3+975
P-3258-10	113703042-H08	HORIZONTAL GEOMETRY - STA 3+975 TO STA 4+252
<u>WILKES AVENUE / VICTOR LEWIS DRIVE</u>		
P-3258-11	113703042-H09	HORIZONTAL GEOMETRY - STA 0+412.583 TO STA 0+663.044
P-3258-12	113703042-G02	PAVEMENT DRAWING KEY PLAN
<u>KENASTON BOULEVARD</u>		
P-3258-13	113703042-T01	HORIZONTAL AND VERTICAL ALIGNMENT - STA 0+685.069 TO STA 1+062.085
<u>STERLING LYON PARKWAY</u>		
P-3258-14	113703042-T02	HORIZONTAL AND VERTICAL ALIGNMENT - KENASTON BOULEVARD TO 2+750
P-3258-15	113703042-T03	HORIZONTAL AND VERTICAL ALIGNMENT - STA 2+750 TO STA 3+025
P-3258-16	113703042-T04	HORIZONTAL AND VERTICAL ALIGNMENT - STA 3+025 TO STA 3+325
P-3258-17	113703042-T05	HORIZONTAL AND VERTICAL ALIGNMENT - STA 3+325 TO STA 3+625
P-3258-18	113703042-T06	HORIZONTAL AND VERTICAL ALIGNMENT - STA 3+625 TO STA 3+900
P-3258-19	113703042-T07	HORIZONTAL AND VERTICAL ALIGNMENT - STA 3+900 TO STA 4+150
P-3258-20	113703042-T08	HORIZONTAL AND VERTICAL ALIGNMENT - STA 4+150 TO STA 4+337.197
<u>WILKES AVENUE / VICTOR LEWIS DRIVE</u>		
P-3258-21	113703042-T09	HORIZONTAL AND VERTICAL ALIGNMENT - INTERSECTION - LEFT TURN LANES
P-3258-22	113703042-T10	INTERSECTION JOINT DETAILS - KENASTON BOULEVARD
P-3258-23	113703042-T11	INTERSECTION JOINT DETAILS - PATRICK WAY
P-3258-24	113703042-T12	INTERSECTION JOINT DETAILS - WHIDDEN GATE
P-3258-25	113703042-T13	INTERSECTION JOINT DETAILS - WILKES AVENUE
<u>KENASTON BOULEVARD</u>		
P-3258-26	113703042-T14	PAVEMENT CROSS SECTIONS AND DETAILS
<u>STERLING LYON PARKWAY</u>		
P-3258-27	113703042-T15	PAVEMENT CROSS SECTIONS
P-3258-28	113703042-T16	PAVEMENT CROSS SECTIONS
<u>WILKES AVENUE / VICTOR LEWIS DRIVE</u>		
P-3258-29	113703042-T17	PAVEMENT CROSS SECTIONS
P-3258-30	113703042-T18	MISCELLANEOUS ROAD DETAILS

<u>KENASTON BOULEVARD</u>		
D-8616	113703042-U01	LAND DRAINAGE SYSTEM - STERLING LYON PARKWAY TO STA 1+075
<u>STERLING LYON PARKWAY</u>		
D-8617	113703042-U02	LAND DRAINAGE SYSTEM - KENASTON BOULEVARD TO STA 2+750
D-8618	113703042-U03	LAND DRAINAGE SYSTEM - STA 2+750 TO STA 3+025
D-8619	113703042-U04	LAND DRAINAGE SYSTEM - STA 3+025 TO STA 3+325
D-8620	113703042-U05	LAND DRAINAGE SYSTEM - STA 3+325 TO STA 3+625
D-8621	113703042-U06	LAND DRAINAGE SYSTEM - STA 3+625 TO STA 3+900
D-8622	113703042-U07	LAND DRAINAGE SYSTEM - STA 3+900 TO STA 4+150
D-8623	113703042-U08	LAND DRAINAGE SYSTEM - STA 4+150 TO VICTOR LEWIS DRIVE
<u>PATRICK WAY</u>		
D-8624	113703042-U09	LAND DRAINAGE SYSTEM - STERLING LYON PARKWAY TO STA 0+705
D-8625	113703042-U10	LAND DRAINAGE SYSTEM - STA 0+705 TO WILKES AVENUE
<u>WILKES AVENUE</u>		
LD-3106	113703042-U11	DITCH REGRADING - KENASTON BOULEVARD DETOUR TO STA 0+325
LD-3107	113703042-U12	DITCH REGRADING - STA 0+325 TO STA 0+625
LD-3108	113703042-U13	DITCH REGRADING - STA 0+625 TO CPR LA RIVIERE SUBDIVISION
LD-3109	113703042-U14	CN CEMENT LEAD RAIL DITCHING AT STERLING LYON PARKWAY
LD-3110	113703042-U15	CPR LA RIVIERE RAIL ROW / HYDRO ROW DITCHING AT STERLING LYON PARKWAY
<u>KENASTON DETOUR</u>		
D-8626	113703042-U16	LAND DRAINAGE SYSTEM - STA 1+075 TO STA 1+300
D-8627	113703042-U17	LAND DRAINAGE SYSTEM - STA 1+300 TO WILKES AVENUE
<u>KENASTON BOULEVARD / DND PROPERTY</u>		
D-8628	113703042-U18	UNDERGROUND UTILITY RELOCATION PLAN
D-8629	113703042-U19	UNDERGROUND UTILITY RELOCATION PLAN
D-8630	113703042-U20	SURFACE WORKS PLAN
D-8631	113703042-U21	MISCELLANEOUS UNDERGROUND DETAILS
D-8632	113703042-U22	MISCELLANEOUS UNDERGROUND DETAILS
P-3258-31	113703042-E01	ELECTRICAL SITE SERVICES
<u>LANDSCAPE WORKS</u>		
P-3258-32	113703042-L01	LANDSCAPE PLAN - KENASTON BOULEVARD TO STA 3+025
P-3258-33	113703042-L02	LANDSCAPE PLAN - STA 3+025 TO 3+625
P-3258-34	113703042-L03	PLANTING BED ENLARGEMENTS - STA 3+025 TO 3+625
P-3258-35	113703042-L04	LANDSCAPE PLAN - STA 3+625 TO VICTOR LEWIS DR./WILKES AVE.
P-3258-36	113703042-L05	PLANTING BED ENLARGEMENTS - STA 3+625 TO STA 3+900
P-3258-37	113703042-L06	LANDSCAPE PLAN - STA 0+550 TO STA 1+150
P-3258-38	113703042-L07	PLANTING & PAVING DETAILS

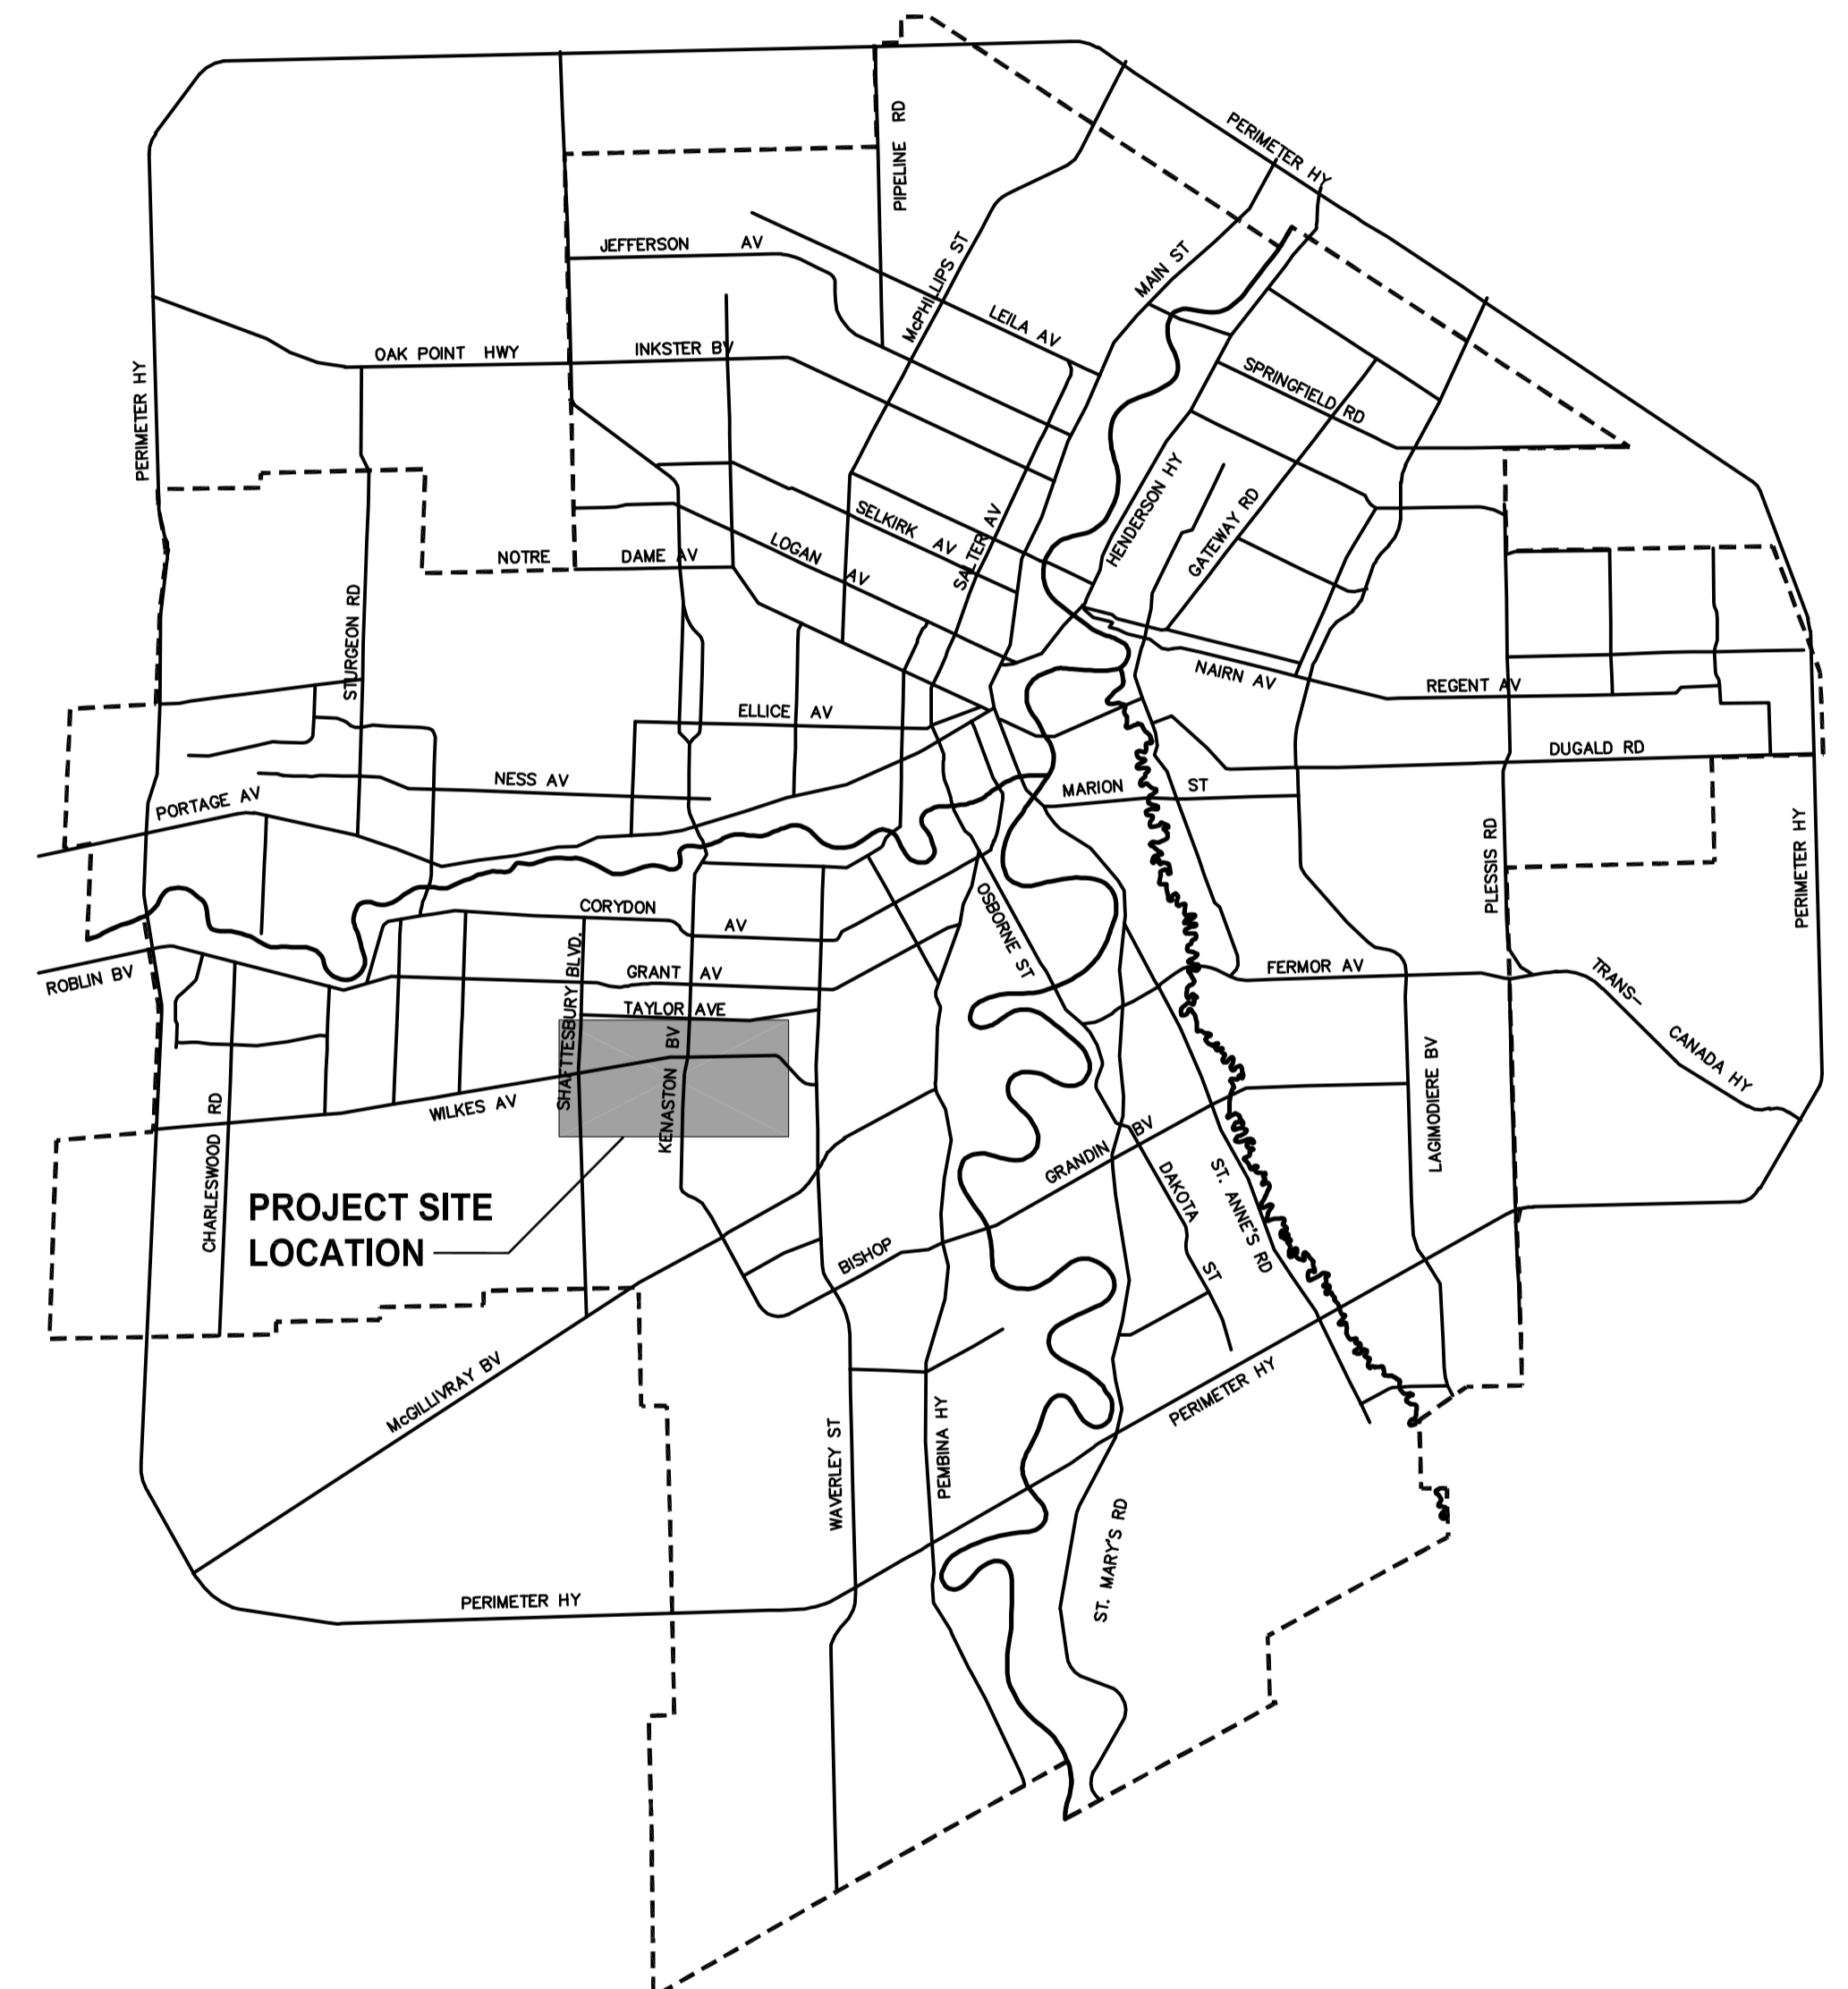

### Stantec Consulting Ltd.

WINNIPEG

MANITOBA



www.umagroup.com

2004 UMA ENGINEERING LTD. ALL RIGHTS RESERVED.

RELEASED FOR CONSTRUCTION BY:  
**R. FINGAS, P.ENG.**  
DATE: 05.03.24

CONSULTANT DRAWING No.  
**113703042-G00**

CITY DRAWING No.  
**P-3258-01**

CAD FILE DRAWING No.  
**ku-cov.dwg**