


**NOTES:**  
 1. CAST-IN-PLACE CONCRETE UPSTANDS BY OTHERS (BO 583-2005) MAY INTERFERE WITH INSTALLATION OF PRECAST DOUBLE TEES ALONG THE GRID LINES (B6) (B10) (B16).  
 COORDINATE WITH CONTRACT ADMINISTRATOR REQUIRED CONSTRUCTION SEQUENCING BEFORE AND AFTER PRECAST INSTALLATION.

SUPPLY AND INSTALLATION OF PRECAST ROOF PANELS BID OPPORTUNITY 171-2006

ROOF FRAMING PLAN  
1:300

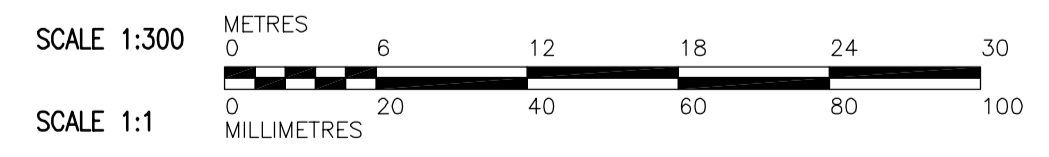

 Certificate of Authorization CH2M HILL Canada Ltd. No. 1441 Expiry: April 30, 2007	 Frederickson Cooper ARCHITECTS	 A 100 International Ltd. Company	ENGINEER'S SEAL	 THE CITY OF WINNIPEG WATER AND WASTE DEPARTMENT ENGINEERING DIVISION	CITY FILE NUMBER
			DESIGNED BY: MH CHECKED BY: AP DRAWN BY: CR APPROVED BY: AHL SCALE: 1:300 RELEASED FOR CONSTRUCTION BY: R. SOROKOWSKI		ORIGINAL SIGNED BY: D. KRUGER 2006/10/11 CONSULTANT DRAWING NO.: WB-S5140
B.M. ELEV.			STRUCTURAL OVERALL BUILDING ROOF FRAMING KEY PLAN		CITY DRAWING NUMBER: 1-0601B-A-S5140-001-000
00 ISSUED FOR TENDER 06/10/11 DK NO. REVISIONS DATE BY		DATE 2006/08/30 DATE 2006/10/11			