






 SUPPLY AND INSTALLATION OF PRECAST ROOF PANELS BID OPPORTUNITY 171-2006

ROOF PLAN
1:300

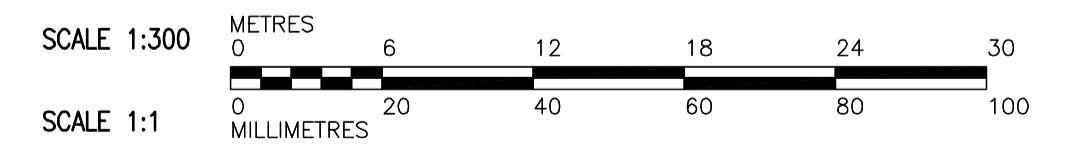

 Certificate of Authorization CH2M HILL Canada Ltd. No. 1441 Expiry: April 30, 2007	B.M. ELEV.	 Frederickson Cooper ARCHITECTS		ENGINEER'S SEAL ORIGINAL SIGNED BY D. KRUGER 2006/10/11	 THE CITY OF WINNIPEG WATER AND WASTE DEPARTMENT ENGINEERING DIVISION WATER TREATMENT PLANT MAIN BUILDING SUPPLY AND INSTALLATION OF PRECAST ROOF PANELS	CITY FILE NUMBER					
	<table border="1"> <tr> <td>00</td> <td>ISSUED FOR TENDER</td> <td>06/10/11</td> <td>DK</td> </tr> <tr> <td>NO.</td> <td>REVISIONS</td> <td>DATE</td> <td>BY</td> </tr> </table>	00	ISSUED FOR TENDER	06/10/11		DK	NO.	REVISIONS	DATE	BY	DESIGNED BY: MH CHECKED BY: AP DRAWN BY: CR APPROVED BY: AHL SCALE: 1:300 RELEASED FOR CONSTRUCTION BY: R. SOROKOWSKI
00	ISSUED FOR TENDER	06/10/11	DK								
NO.	REVISIONS	DATE	BY								