

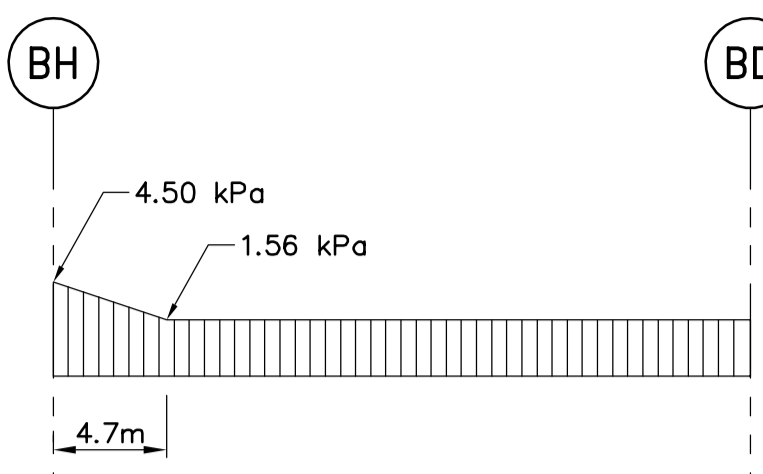


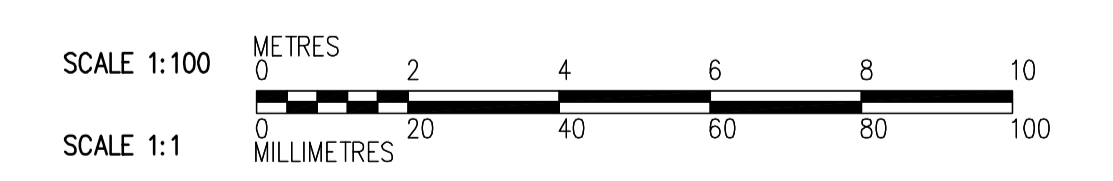

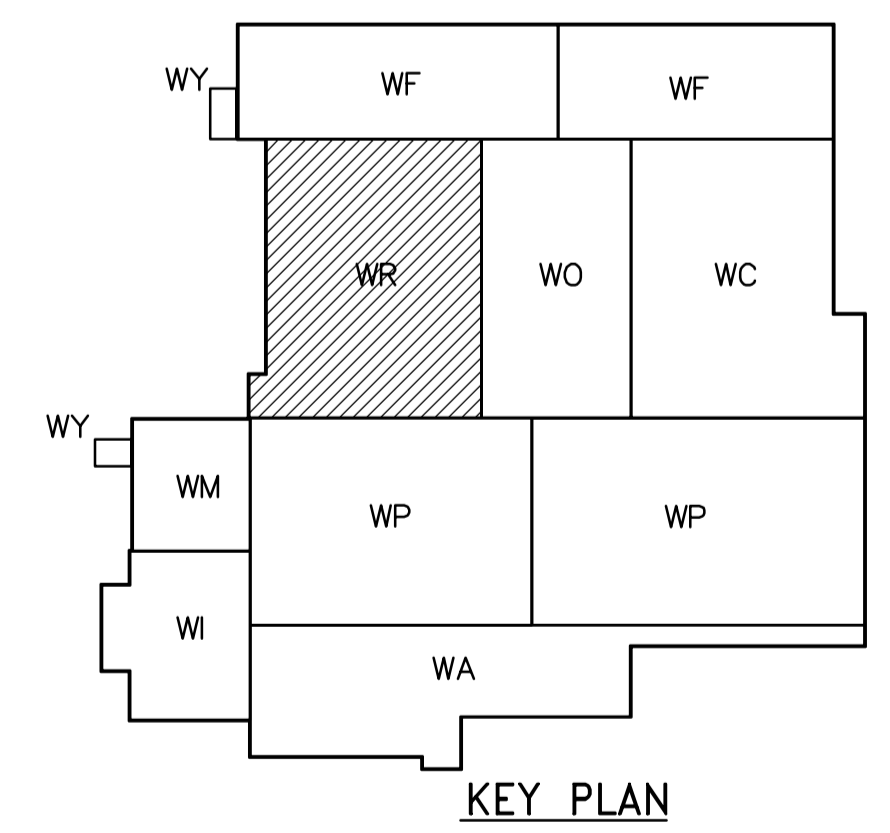

NOTES:

- SPECIFIED SNOW LOAD:

- SPECIFIED SERVICE LOAD = 1 kPa
- SEE DRAWING WB-S5451 FOR PRECAST DETAILS.
- SEE DETAIL 3 TO SUPPORT LIGHT FIXTURES, INSTALLED UNDER SEPARATE CONTRACT.
- PROVIDE 20mm DIA SLEEVES IN ALL DOUBLE TEE STEMS 1200mm C/C.



ROOF PLAN
1:100

 Certificate of Authorization CH2M HILL Canada Ltd. No. 1441 Expiry: April 30, 2007	B.M. ELEV.		 Frederickson Cooper ARCHITECTS	 A 100 International Ltd. Company	ENGINEER'S SEAL	 THE CITY OF WINNIPEG WATER AND WASTE DEPARTMENT ENGINEERING DIVISION		
	DESIGNED BY: MH DRAWN BY: CR				ORIGINAL SIGNED BY: D. KRUGER 2006/10/11		WATER TREATMENT PLANT RESIDUALS HANDLING SUPPLY AND INSTALLATION OF PRECAST ROOF PANELS	
	SCALE: 1:100				CONSULTANT DRAWING NO. WR-S5146			CITY FILE NUMBER SHEET OF
	00 ISSUED FOR TENDER 06/10/11 DK NO. REVISIONS DATE BY				RELEASED FOR CONSTRUCTION BY: R. SOROKOWSKI 2006/08/30			CITY DRAWING NUMBER 1-0601R-A-S5146-001-000