


PLAN 1
 SCALE 1:100
 DEMOLITION

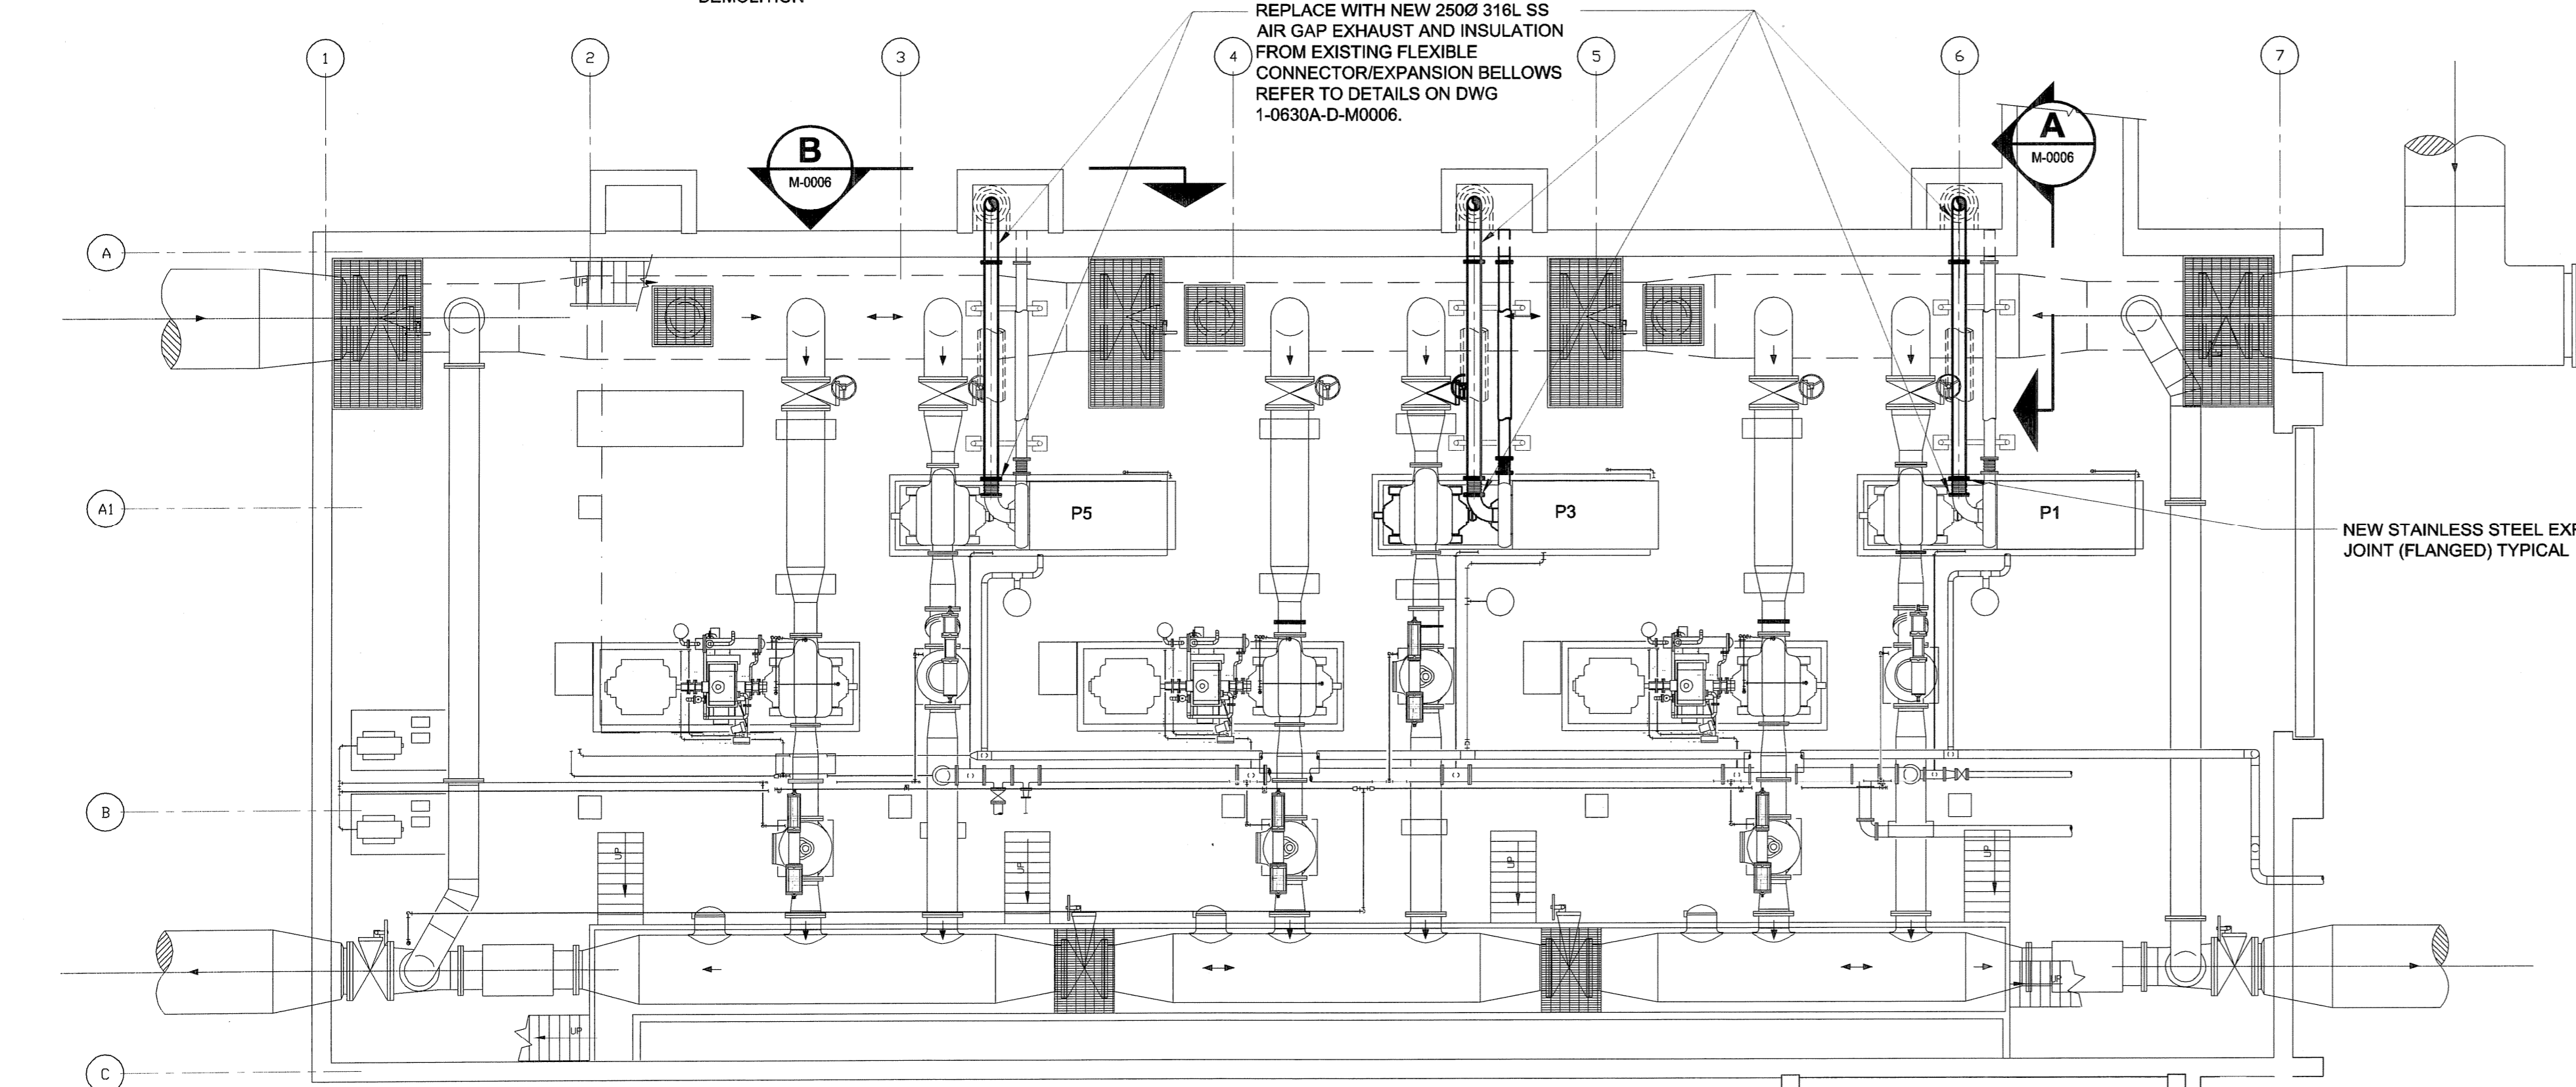

PLAN 2
 SCALE 1:100
 NEW CONSTRUCTION

NOTE:

DRN	CHK	DES	ENG	ICR
AS	CC		BP	
UMA AECOM REVIEW				

IMPORTANT: ASBESTOS NOTIFICATION AND ACKNOWLEDGMENT

Every effort has been made to identify known asbestos containing materials within the areas of the proposed work. As a precautionary measure, where material is encountered by trades and contractors that is suspect or suspicious, the Trade/Contractor/Subcontractor is to contact the Contract Administrator who will have samples taken and tested to confirm its composition.

Ms. Reg. 53-88 (Workplace Health Hazard Regulation), Ms. Reg. 100-88R (Fibrous and Silica Regulation) and associated Guidelines apply to all maintenance and renovation work that may disturb asbestos or suspect asbestos-containing materials in the Workplace. Such regulations and guidelines state that any disturbance of asbestos-containing materials may only be performed by workers or by an outside contractor who have first received the required training in asbestos-related precautions.

WORKING WITH ASBESTOS CAN BE DANGEROUS. INHALING ASBESTOS FIBERS CAN CAUSE VARIOUS TYPES OF LUNG DISEASE INCLUDING CANCER. SMOKING INCREASES THE RISK OF LUNG CANCER FROM ASBESTOS EXPOSURE.


ACKNOWLEDGMENT:

In undertaking the work of this project, we the trade or contractor agree to perform our work in such a manner so as NOT to disturb any asbestos-containing materials without:

- giving notice to the appropriate supervisor, individual manager and/or project coordinator at the Water and Waste Department that known or suspected asbestos-containing material(s) will be disturbed, or
- halting work and giving notice to the Contract Administrator when unforeseen suspected asbestos-containing materials are uncovered during the provisions of services/materials.

APEGM
 Certificate of Authorization
 UMA Engineering Ltd. (MB)
 No. 256 Date: June 15-07

B.M. ELEV.	FIELD BOOK #:	UMA AECOM	
POSTED TO LBIS		© 2006 UMA ENGINEERING LTD. ALL RIGHTS RESERVED.	
DESIGNED BY CAC	CHECKED BY		
DRAWN BY RJP	APPROVED BY		
C ISSUED FOR BID	07/06/15	RJP	
B ISSUED FOR 99% REVIEW	07/05/04	RJP	
A ISSUED FOR 75% REVIEW	07/03/15	RJP	
NO. REVISIONS	DATE	BY	FILENAME: D265-199-00_01-M-0005_RX.dwg

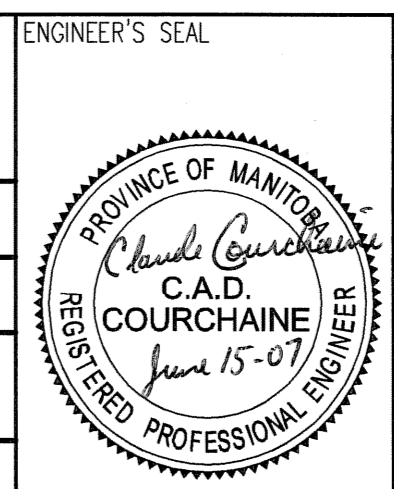

THE CITY OF WINNIPEG
 WATER AND WASTE DEPARTMENT

MCPHILLIPS PUMPING STATION
 Contract No.
 Natural Gas Engine Drives Replacement
 Mechanical - Demolition/New Construction
 PUMP/ENGINE LEVEL FLOOR PLAN

CITY DRAWING NUMBER: 1-0640A-D-M0005
 SHEET: 001
 REV: C
 SIZE: D