


PARTIAL PILE LAYOUT PLAN
1:75

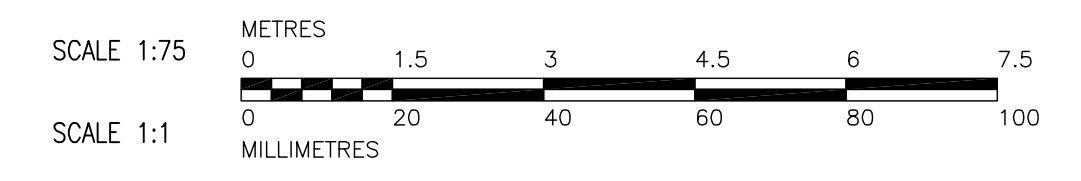

B.M. ELEV.		CH2M HILL Frederickson Cooper ARCHITECTS		EarthTech A Tyco International Ltd. Company		ENGINEER'S SEAL ORIGINAL SIGNED BY A. POCHANART 2007/01/31		THE CITY OF WINNIPEG WATER AND WASTE DEPARTMENT ENGINEERING DIVISION	
DESIGNED BY CG		CHECKED BY AP		DRAWN BY WDB		APPROVED BY AHL		WATER TREATMENT PLANT BULK CHEMICAL BUILDING SODIUM HYPOCHLORITE AND CHEMICAL STORAGE BUILDING	
SCALE: AS NOTED		RELEASED FOR CONSTRUCTION BY: R. SOROKOWSKI		CONSULTANT DRAWING NO. WS-F0100		STRUCTURAL FOUNDATION PLAN - PARTIAL PILE LAYOUT		CITY FILE NUMBER SHEET OF CITY DRAWING NUMBER 1-06018-B-F0100-001-0D	
01	792-2006 ADDENDUM 3	07/03/30	WDB	DATE	2007/01/26	DATE	2007/01/31		
00	ISSUED FOR TENDER	07/01/31	CMF						
NO.	REVISIONS	DATE	BY	DATE	2007/01/26	DATE	2007/01/31		