
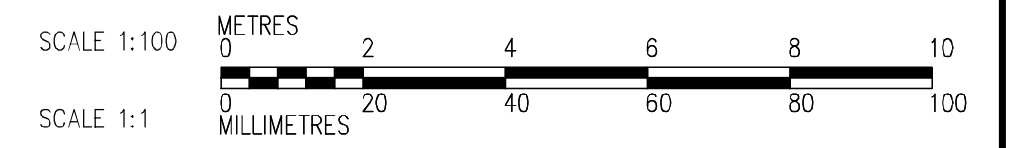


- NOTES:**
- SEE MCC #2A & #2B SINGLE LINE DIAGRAM AND DP-C11 & DP-C12 POWER DISTRIBUTION FOR 600V POWER DISTRIBUTION.
 - ALL 120V AND 208V LOADS ARE FED FROM LP-C11
 - PROVIDE STAIRWELL SMOKE DETECTORS AS SHOWN ON FIRE PROTECTION DRAWINGS

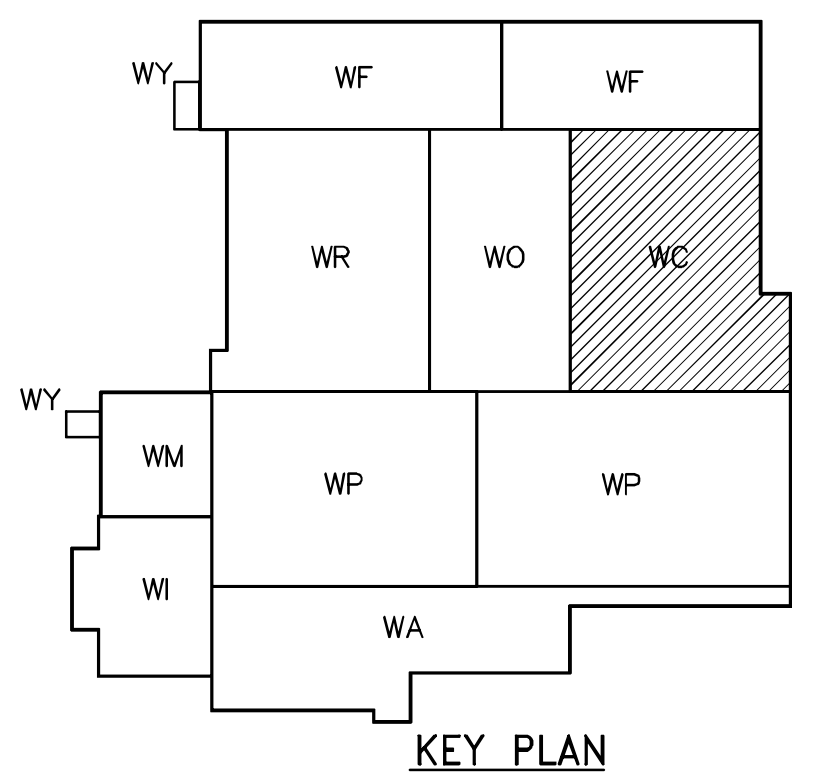

FIRST FLOOR FACILITY PLAN
1:100

CABLE TRAY TAGGING
SEE DETAIL
3
WB-E0455

FOR INFORMATION ONLY - ISSUED WITH
BID OPPORTUNITY 792-2006 - ADDENDUM 5

APEGM
Certificate of Authorization
CH2M HILL Canada Ltd.
No. 1441 Expiry: April 30, 2007

NO.	REVISIONS	DATE	BY
03	ISSUED FOR CONSTRUCTION	06/07/28	LL
02	742-2005 ADDENDUM 5	06/05/19	LL
01	742-2005 ADDENDUM 3	06/05/05	LL
00	ISSUED FOR TENDER	06/03/29	LL

CH2MHILL Frederickson Cooper ARCHITECTS		EarthTech A Tyco International Ltd. Company	
DESIGNED BY: JT	CHECKED BY: ND	DESIGNED BY: JT	CHECKED BY: ND
DRAWN BY: KJ	APPROVED BY: AHL	DRAWN BY: KJ	APPROVED BY: AHL
SCALE: 1:100	RELEASED FOR CONSTRUCTION BY: R. SOROKOWSKI	SCALE: 1:100	RELEASED FOR CONSTRUCTION BY: R. SOROKOWSKI
DATE: 2005/07/08	DATE: 2006/03/29	DATE: 2005/07/08	DATE: 2006/03/29

ENGINEER'S SEAL
ORIGINAL SIGNED BY
L.D. LLEWELLYN
2006/03/29
CONSULTANT DRAWING NO.
WC-E0111

THE CITY OF WINNIPEG
WATER AND WASTE DEPARTMENT
ENGINEERING DIVISION

WATER TREATMENT PLANT
CHEMICAL FEED SYSTEMS
MECHANICAL AND ELECTRICAL

ELECTRICAL
CHEMICAL AREA
FIRST FLOOR FACILITY PLAN

CITY FILE NUMBER
SHEET OF
CITY DRAWING NUMBER
1-0601C-A-E0111-001-030