



4 SOUTH ELEVATION
WJ-B0403 1:30

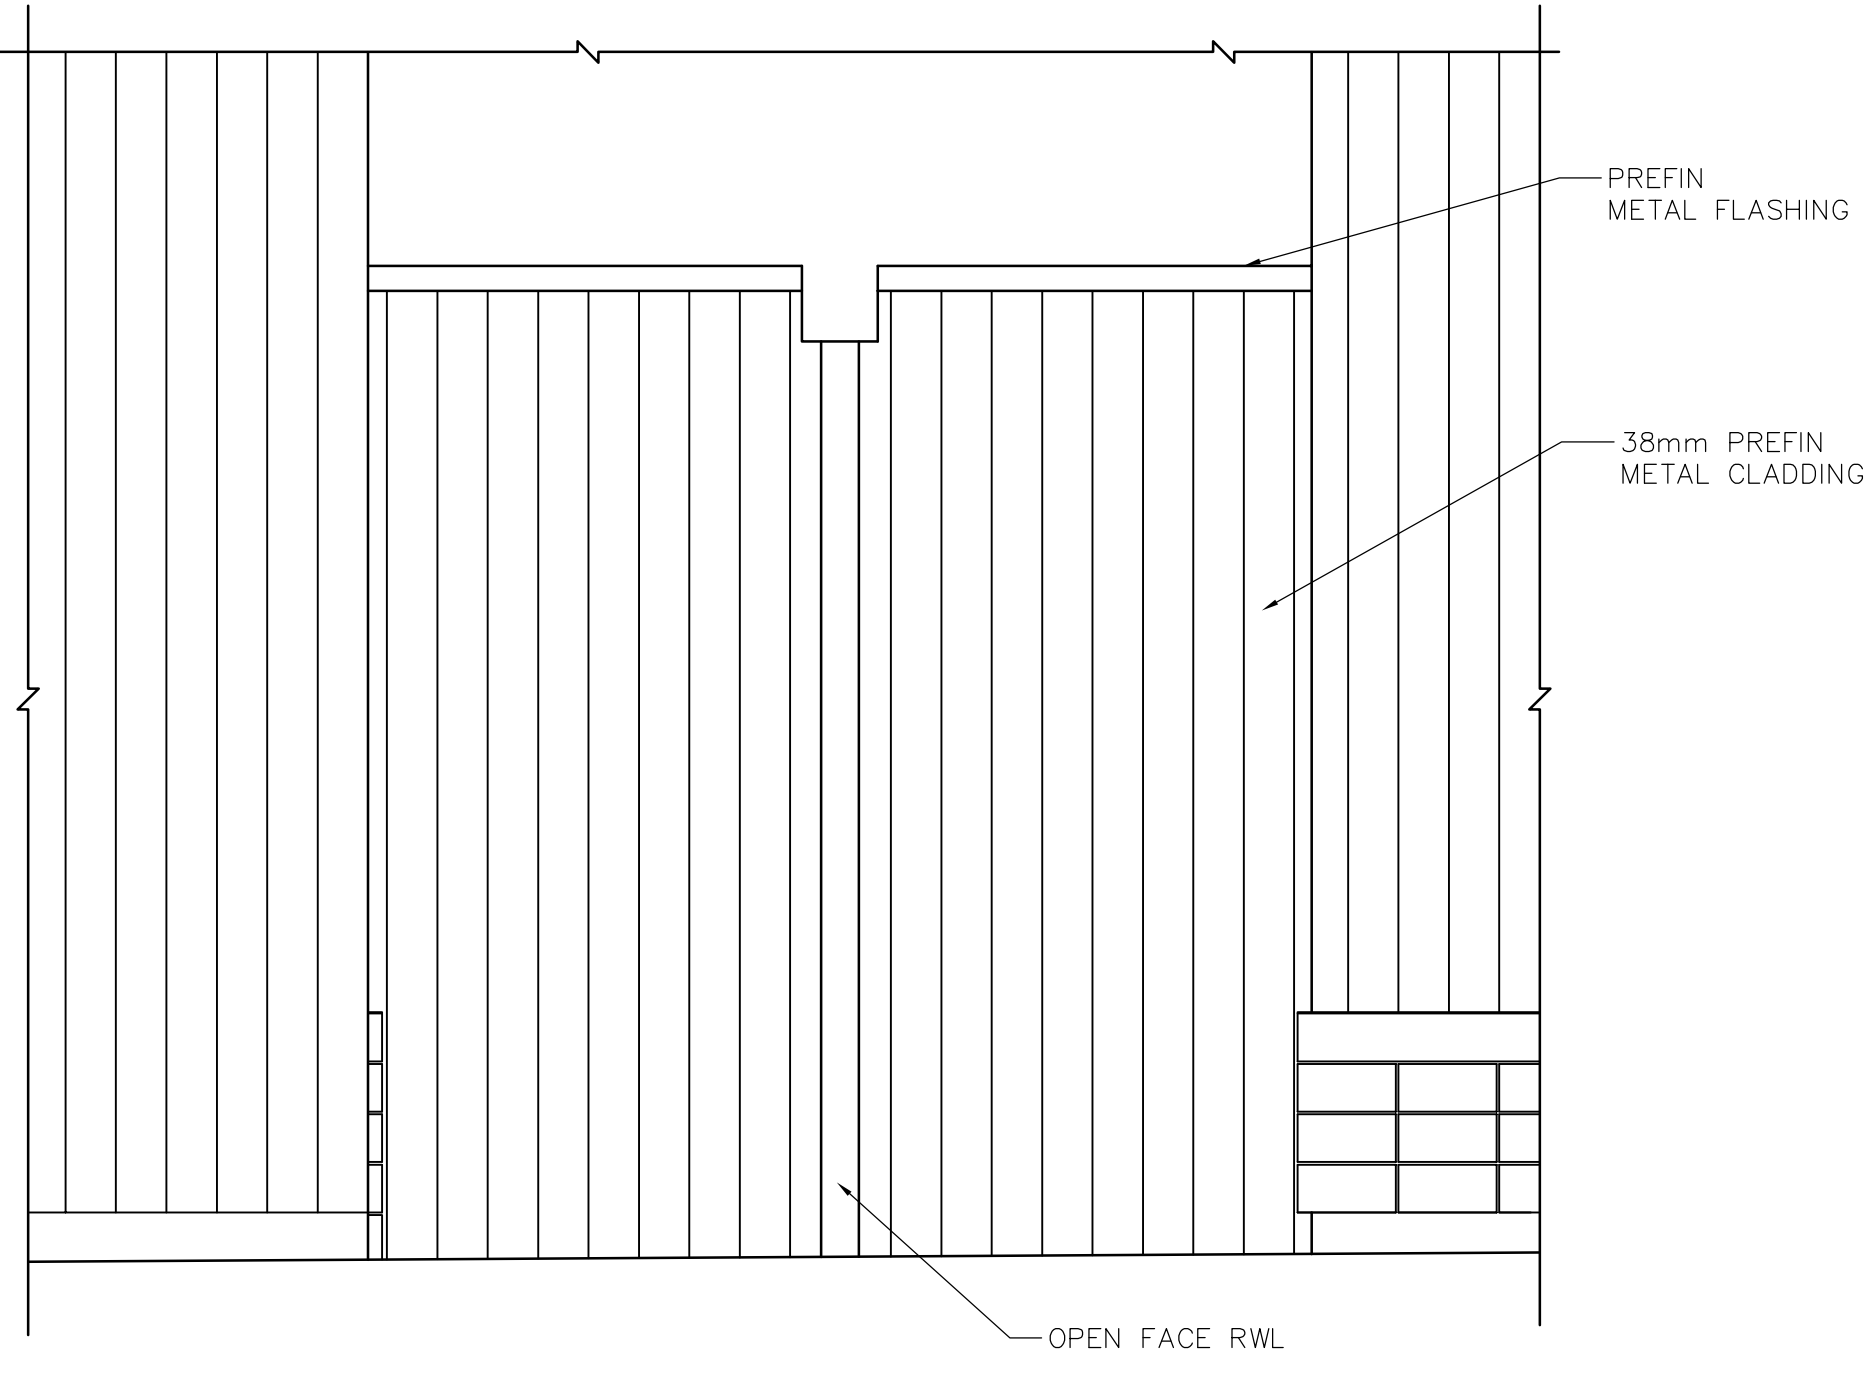


5 NORTH ELEVATION
WJ-B0403 1:30

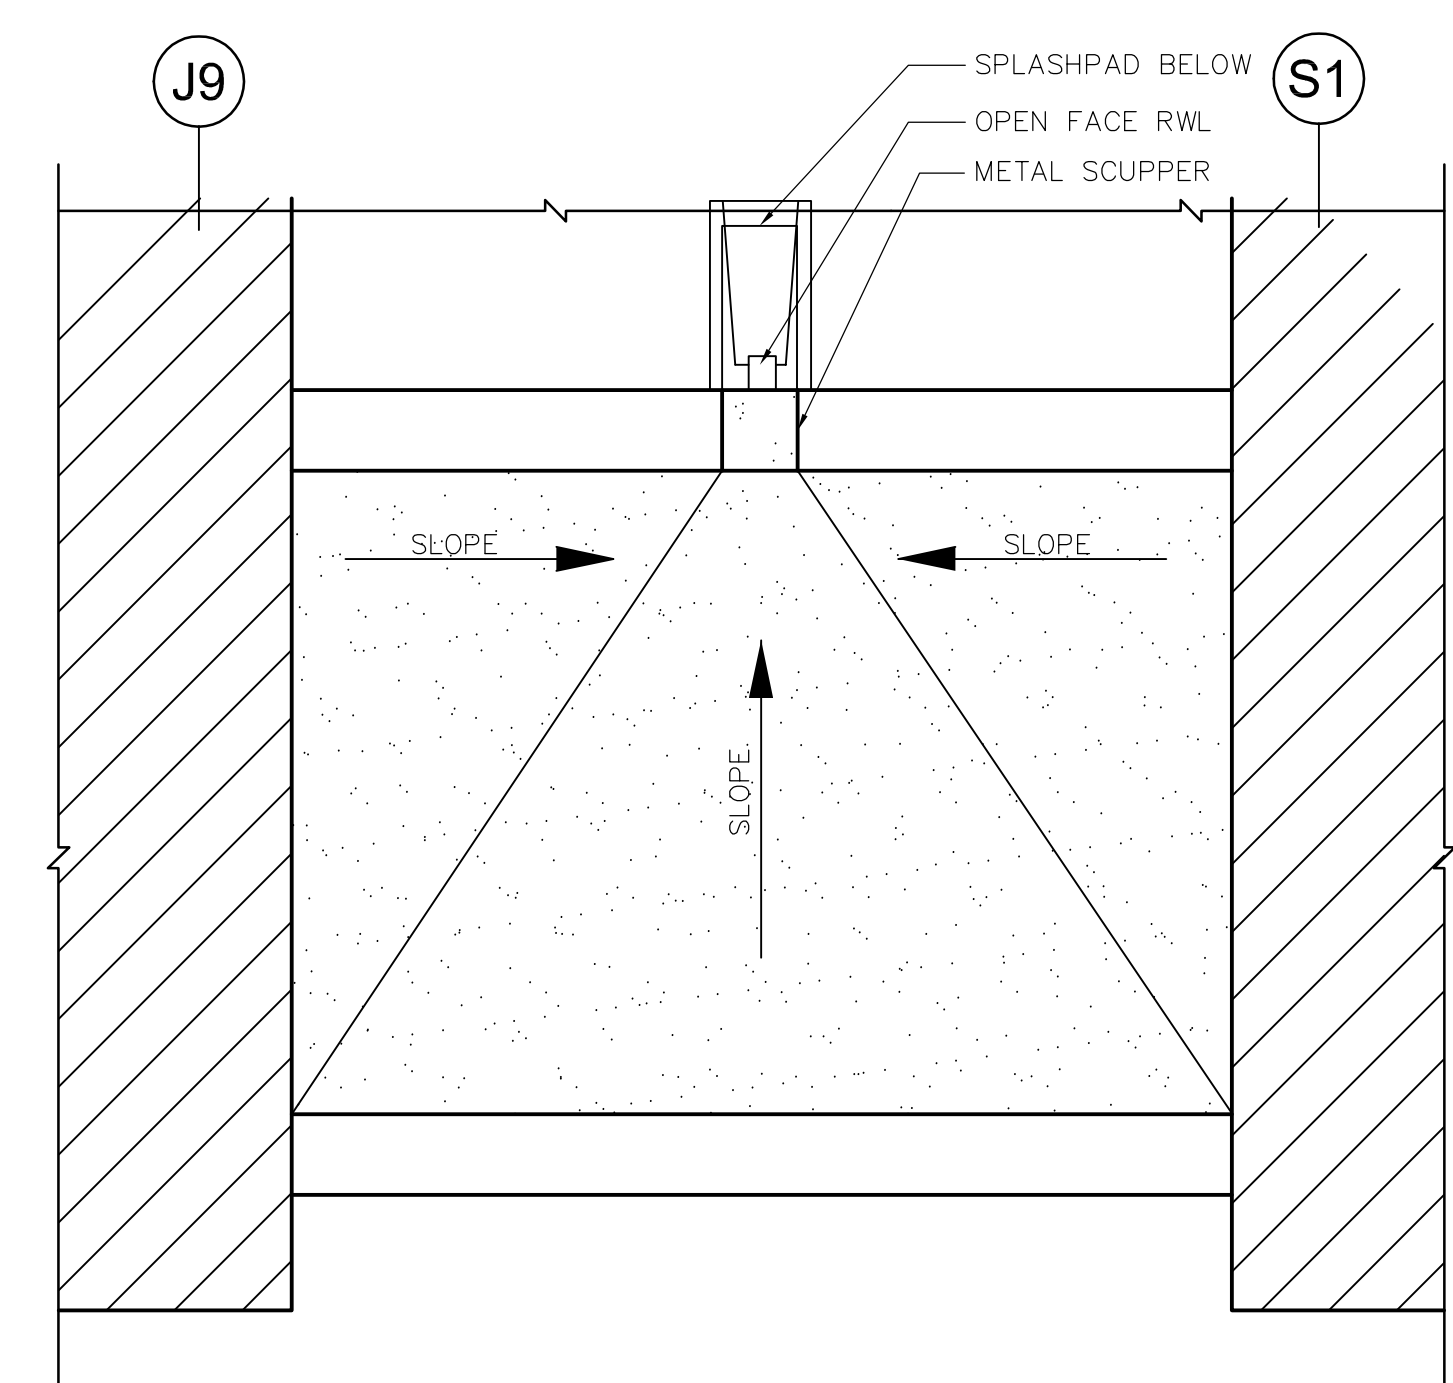


6 ROOF PLAN
WJ-B0403 1:30


ROOF CONSTRUCTION
 2-PLY MOD-BIT ROOFING
 2 LAYERS INSULATION
 OVERLAY-STAGGERED
 TAPERED INSULATION (2%)
 125mm RIGID INSULATION
 AIR/VAPOUR BARRIER
 13mm EXTERIOR GYP BD
 38mm STEEL DECKING
 STEEL STRUCTURE

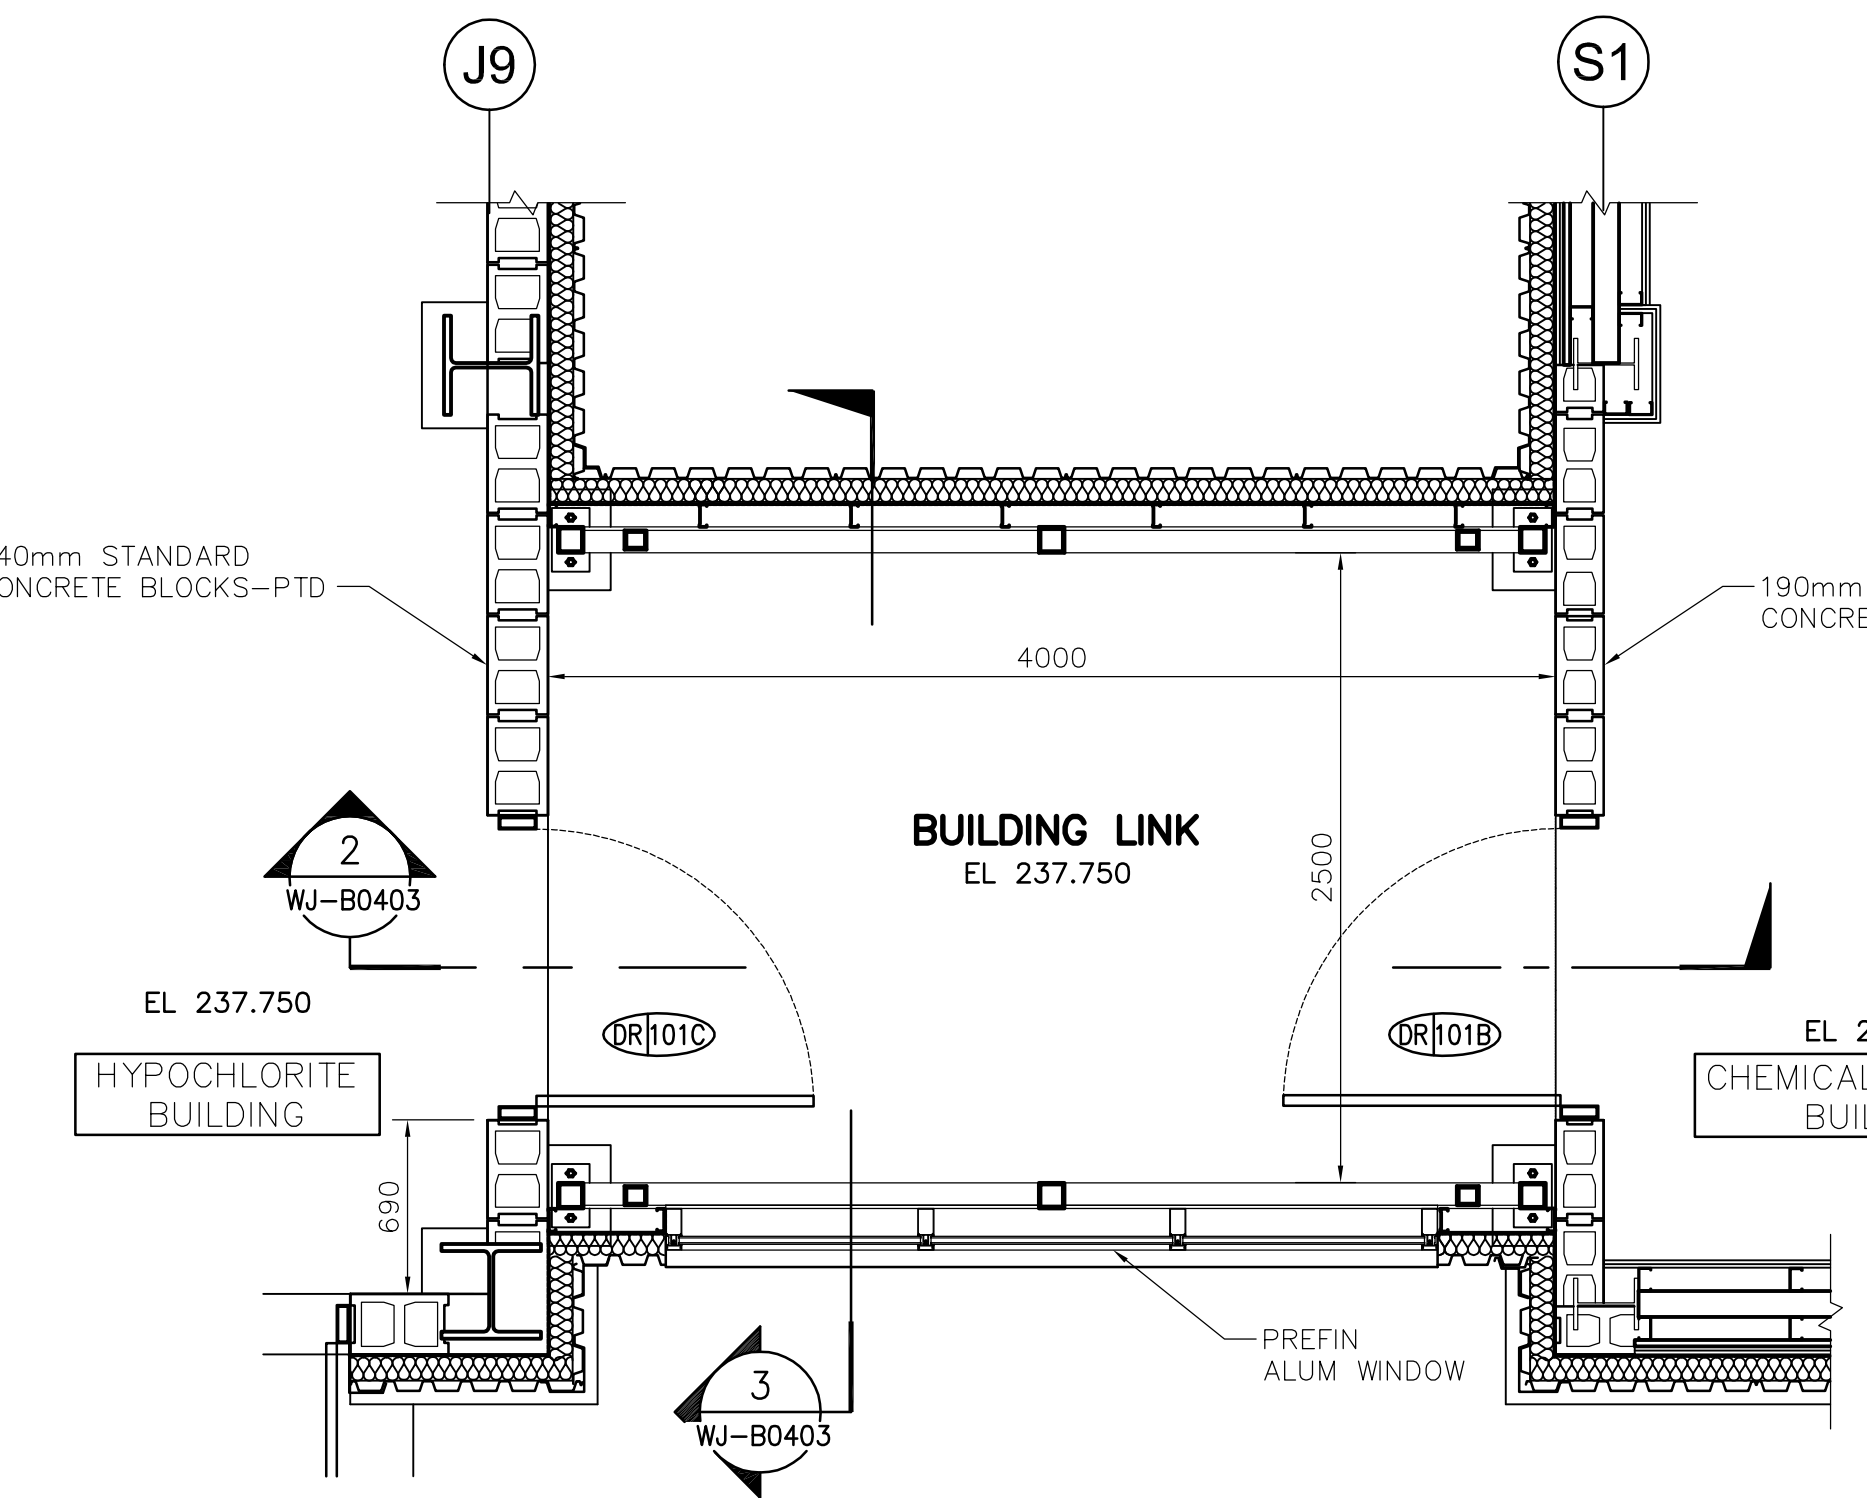

1 FLOOR PLAN
WJ-B0403 1:30

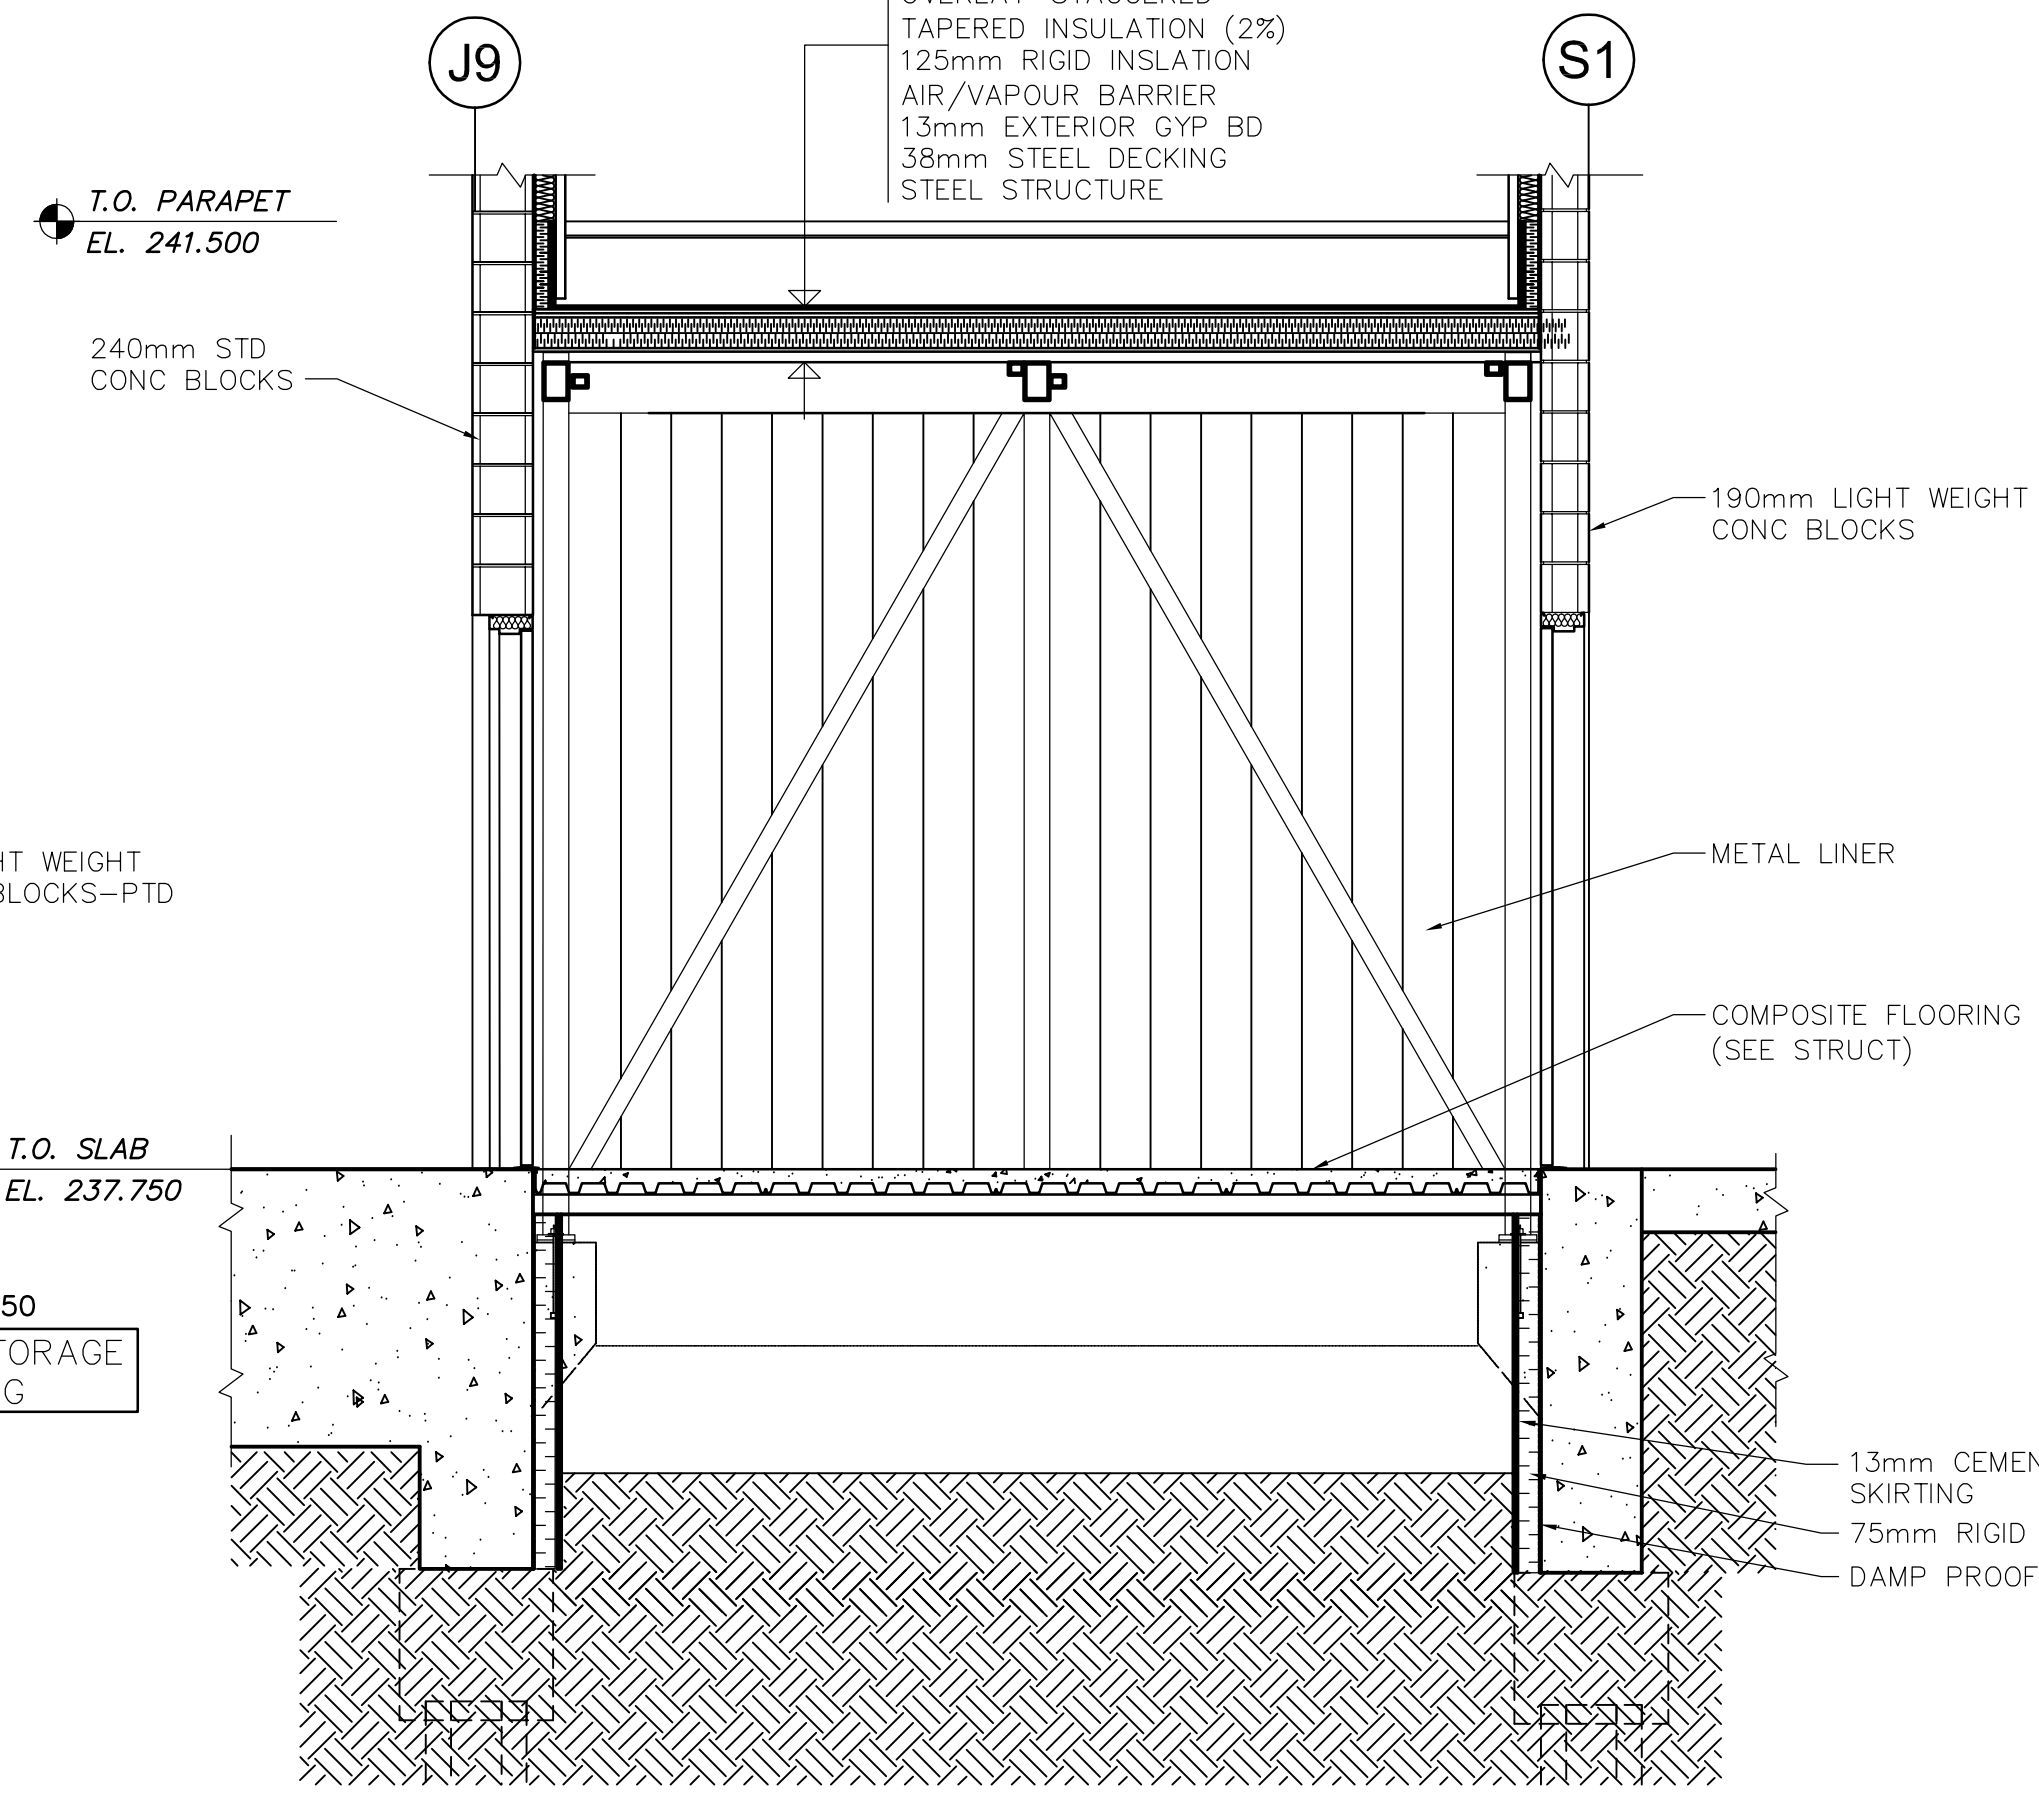

2 SECTION A
WJ-B0403 1:30

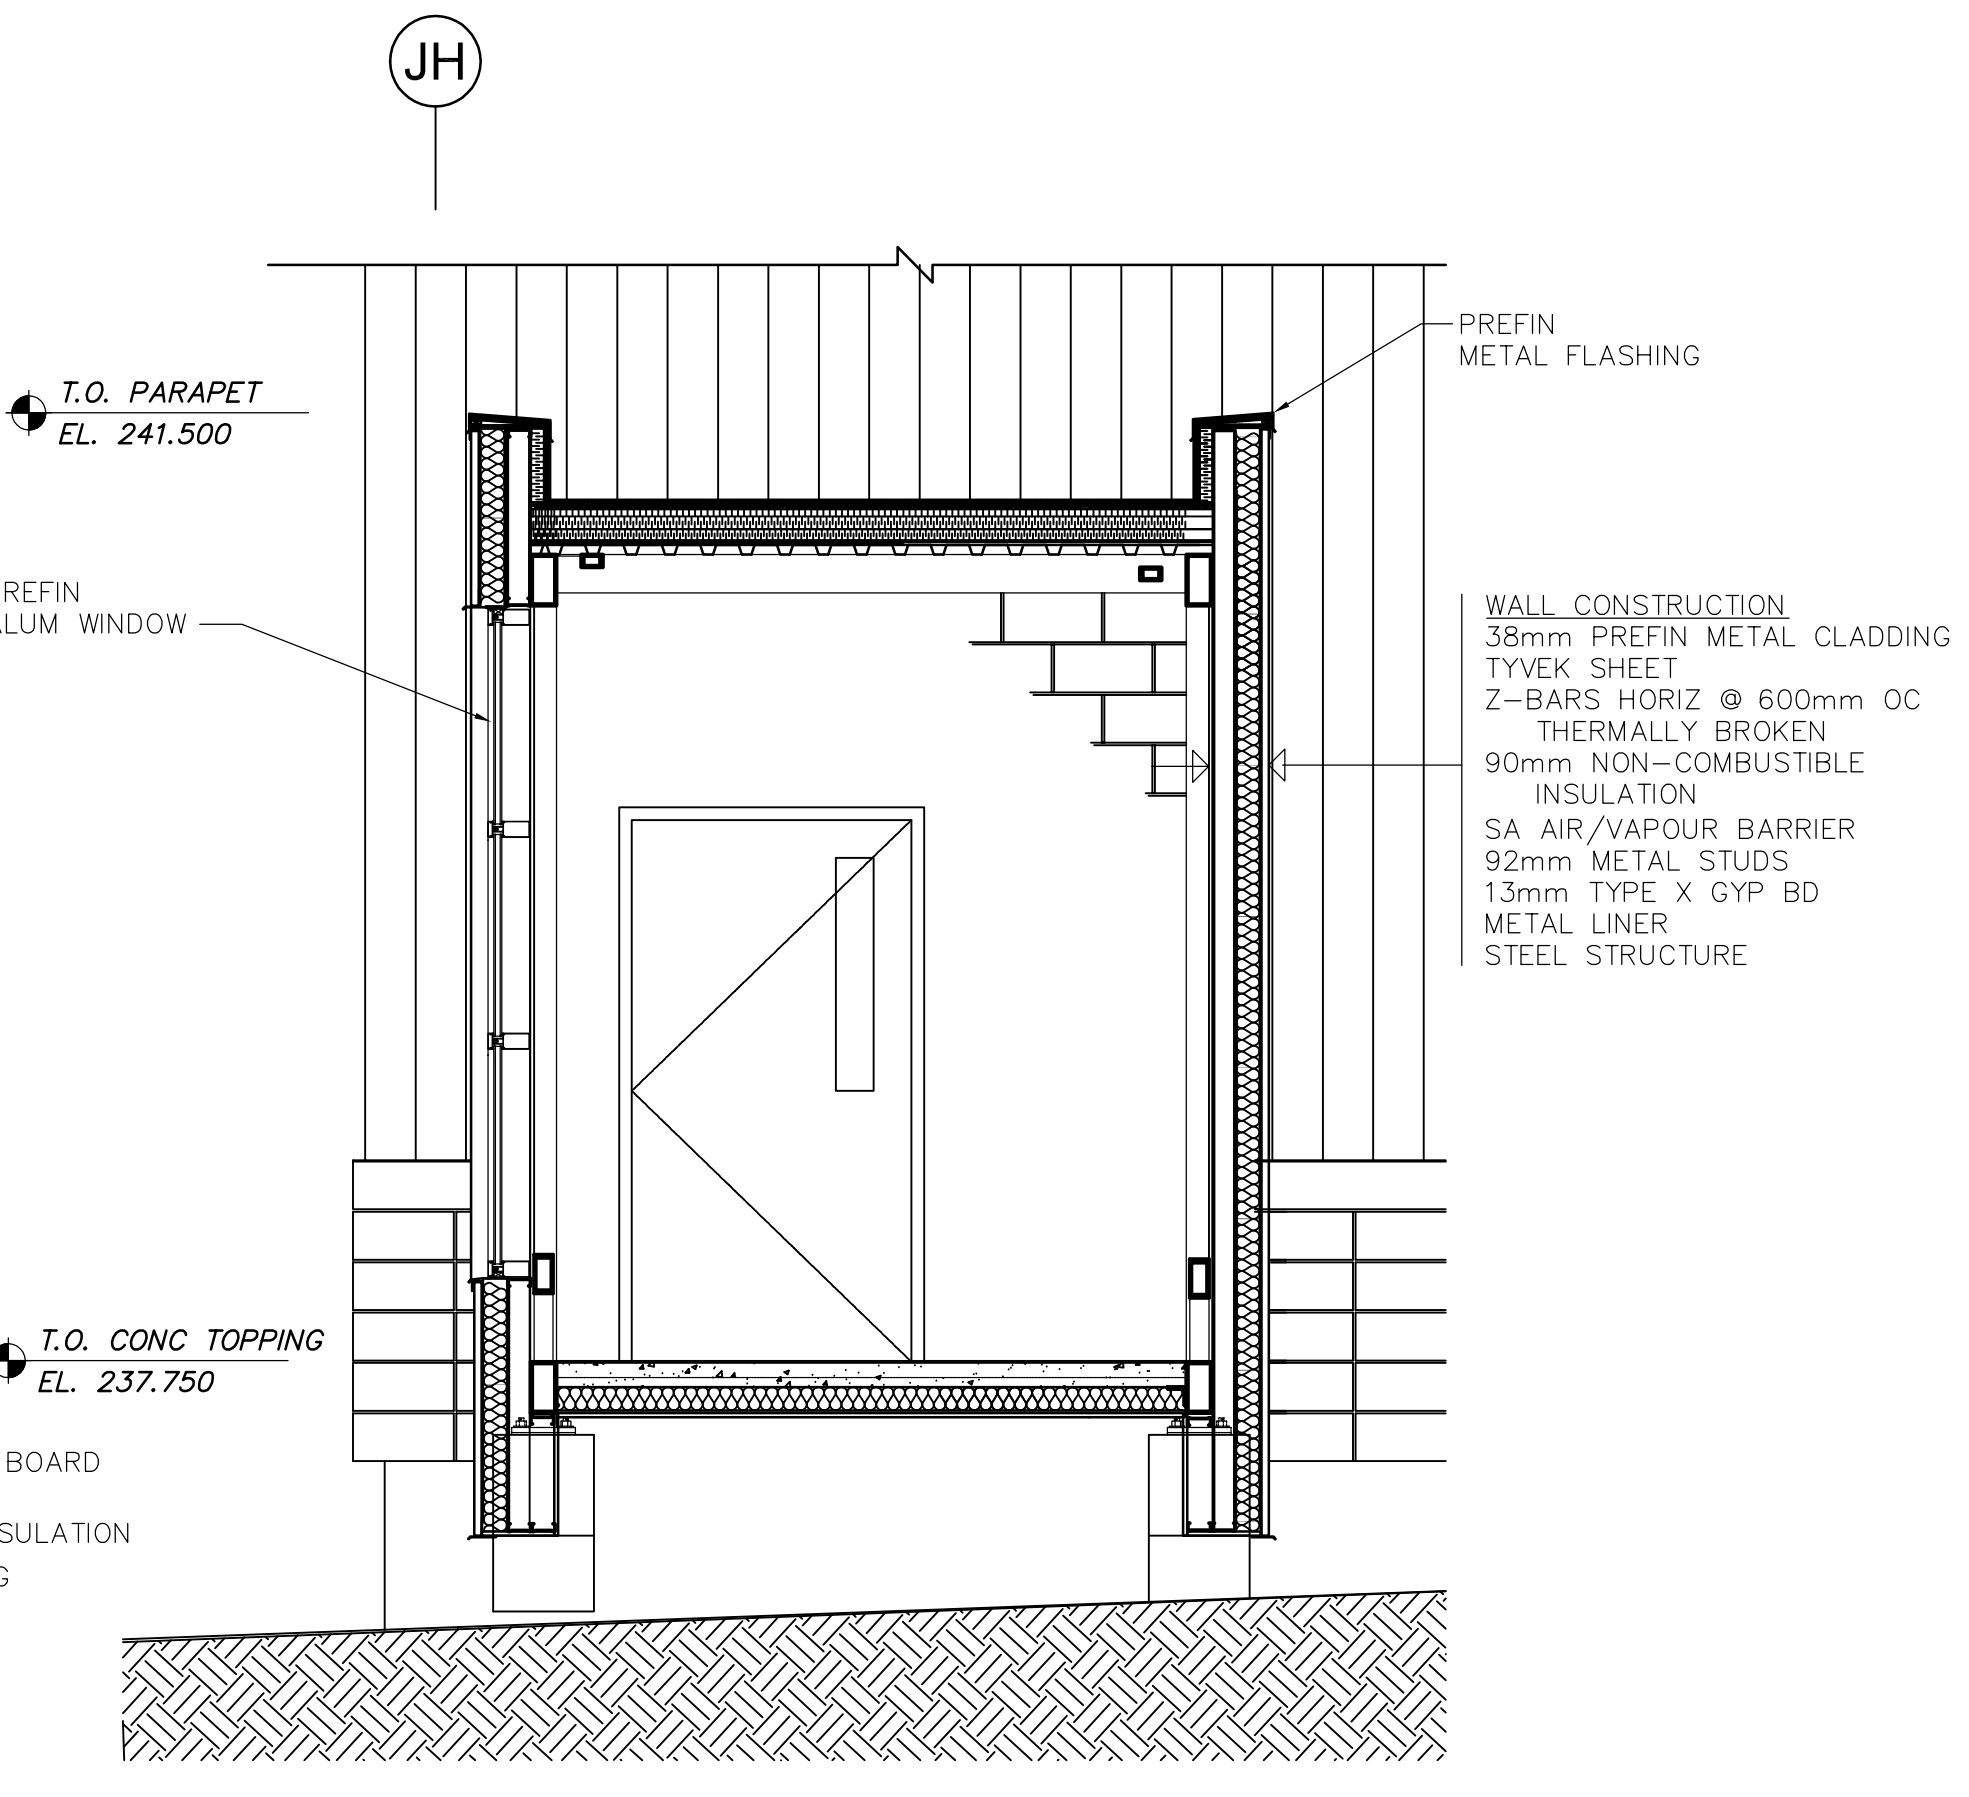

3 SECTION B
WJ-B0403 1:30

WALL CONSTRUCTION
 38mm PREFIN METAL CLADDING
 TYVEK SHEET
 Z-BARS HORIZ @ 600mm OC
 THERMALLY BROKEN
 90mm NON-COMBUSTIBLE
 INSULATION
 SA AIR/VAPOUR BARRIER
 92mm METAL STUDS
 13mm TYPE X GYP BD
 METAL LINER
 STEEL STRUCTURE



B.M. ELEV.	
DESIGNED BY	NC
DRAWN BY	AL
SCALE:	AS SHOWN
00 ISSUED FOR TENDER	07/01/31 AL
NO. REVISIONS	DATE BY
	DATE 2006/10/02

CH2MHILL Frederickson Cooper ARCHITECTS	EarthTech A Tyco International US Company
DESIGNED BY NC	CHECKED BY LK
DRAWN BY AL	APPROVED BY AHL
SCALE: AS SHOWN	RELEASED FOR CONSTRUCTION BY: R. SOROKOWSKI
	DATE 2007/01/31

ENGINEER'S SEAL
ORIGINAL SIGNED BY
NEIL COOPER
2007/01/31
CONSULTANT DRAWING NO.
WJ-B0403

THE CITY OF WINNIPEG
 WATER AND WASTE DEPARTMENT
 ENGINEERING DIVISION

WATER TREATMENT PLANT
 SODIUM HYPOCHLORITE GENERATION BUILDING
 SODIUM HYPOCHLORITE AND CHEMICAL STORAGE BUILDING

ARCHITECTURAL
 BUILDING LINK DETAILED PLAN & SECTIONS

CITY FILE NUMBER
 SHEET OF
 CITY DRAWING NUMBER
 1-0601J-A-B0403-001-000