



**3 ROOF PLAN**  
WS-B0404 1:30

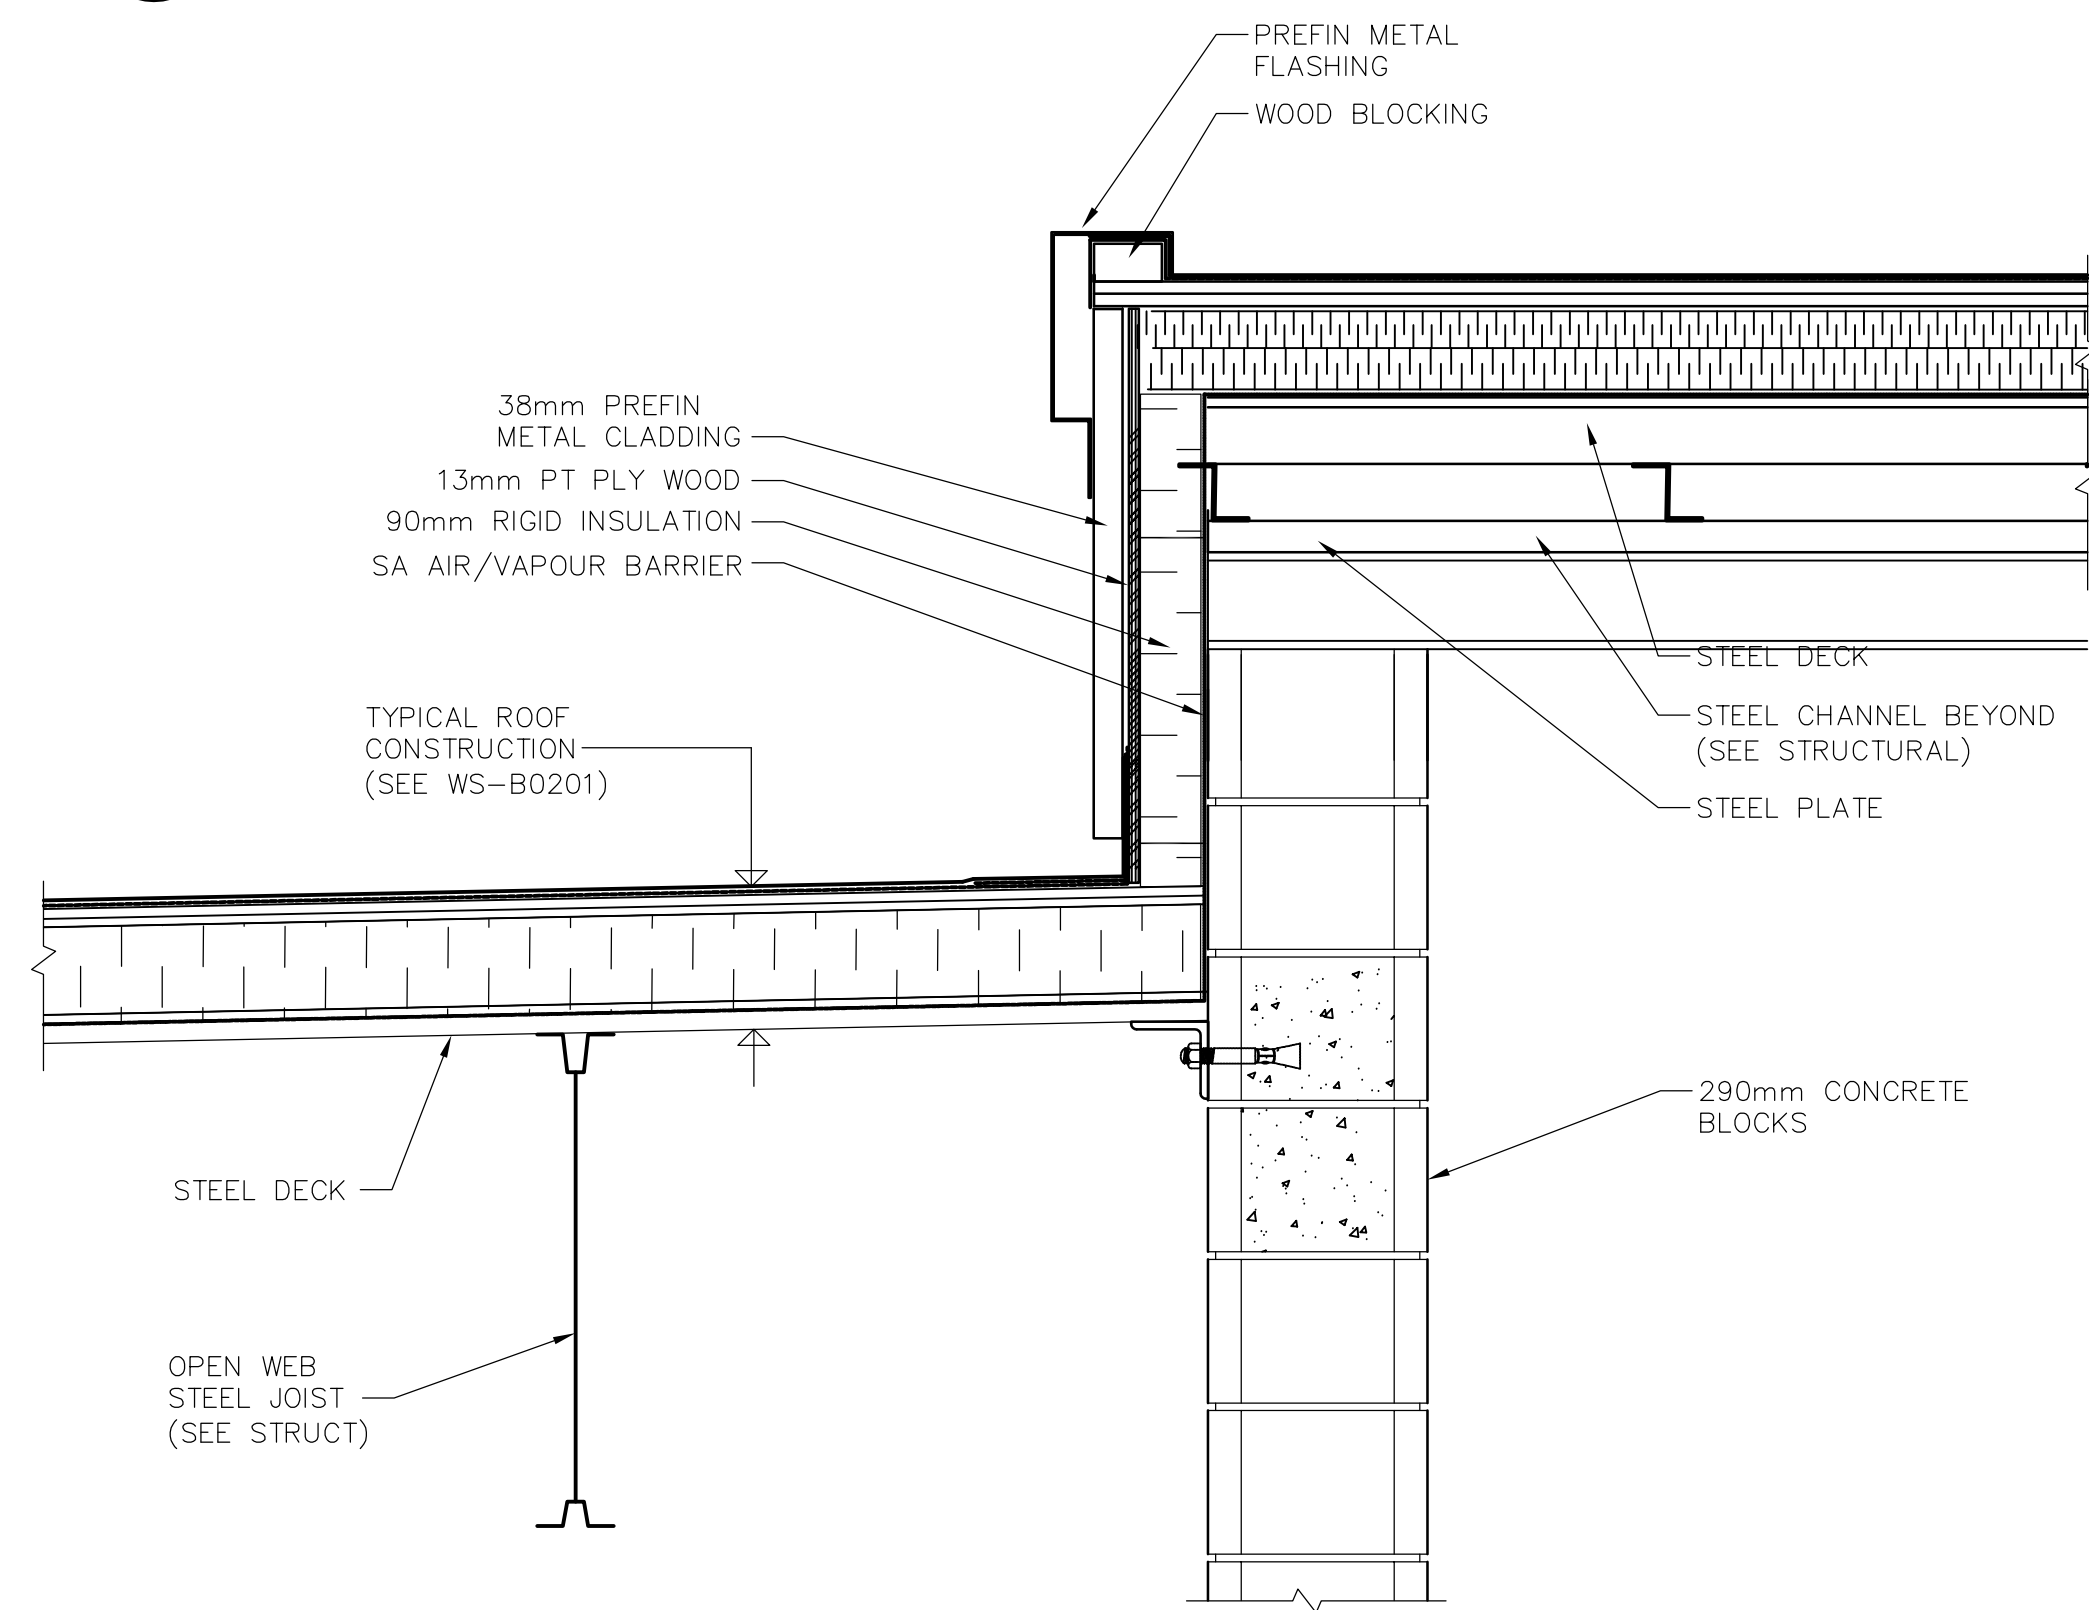

**1 DETAIL**  
WS-B0404 1:10

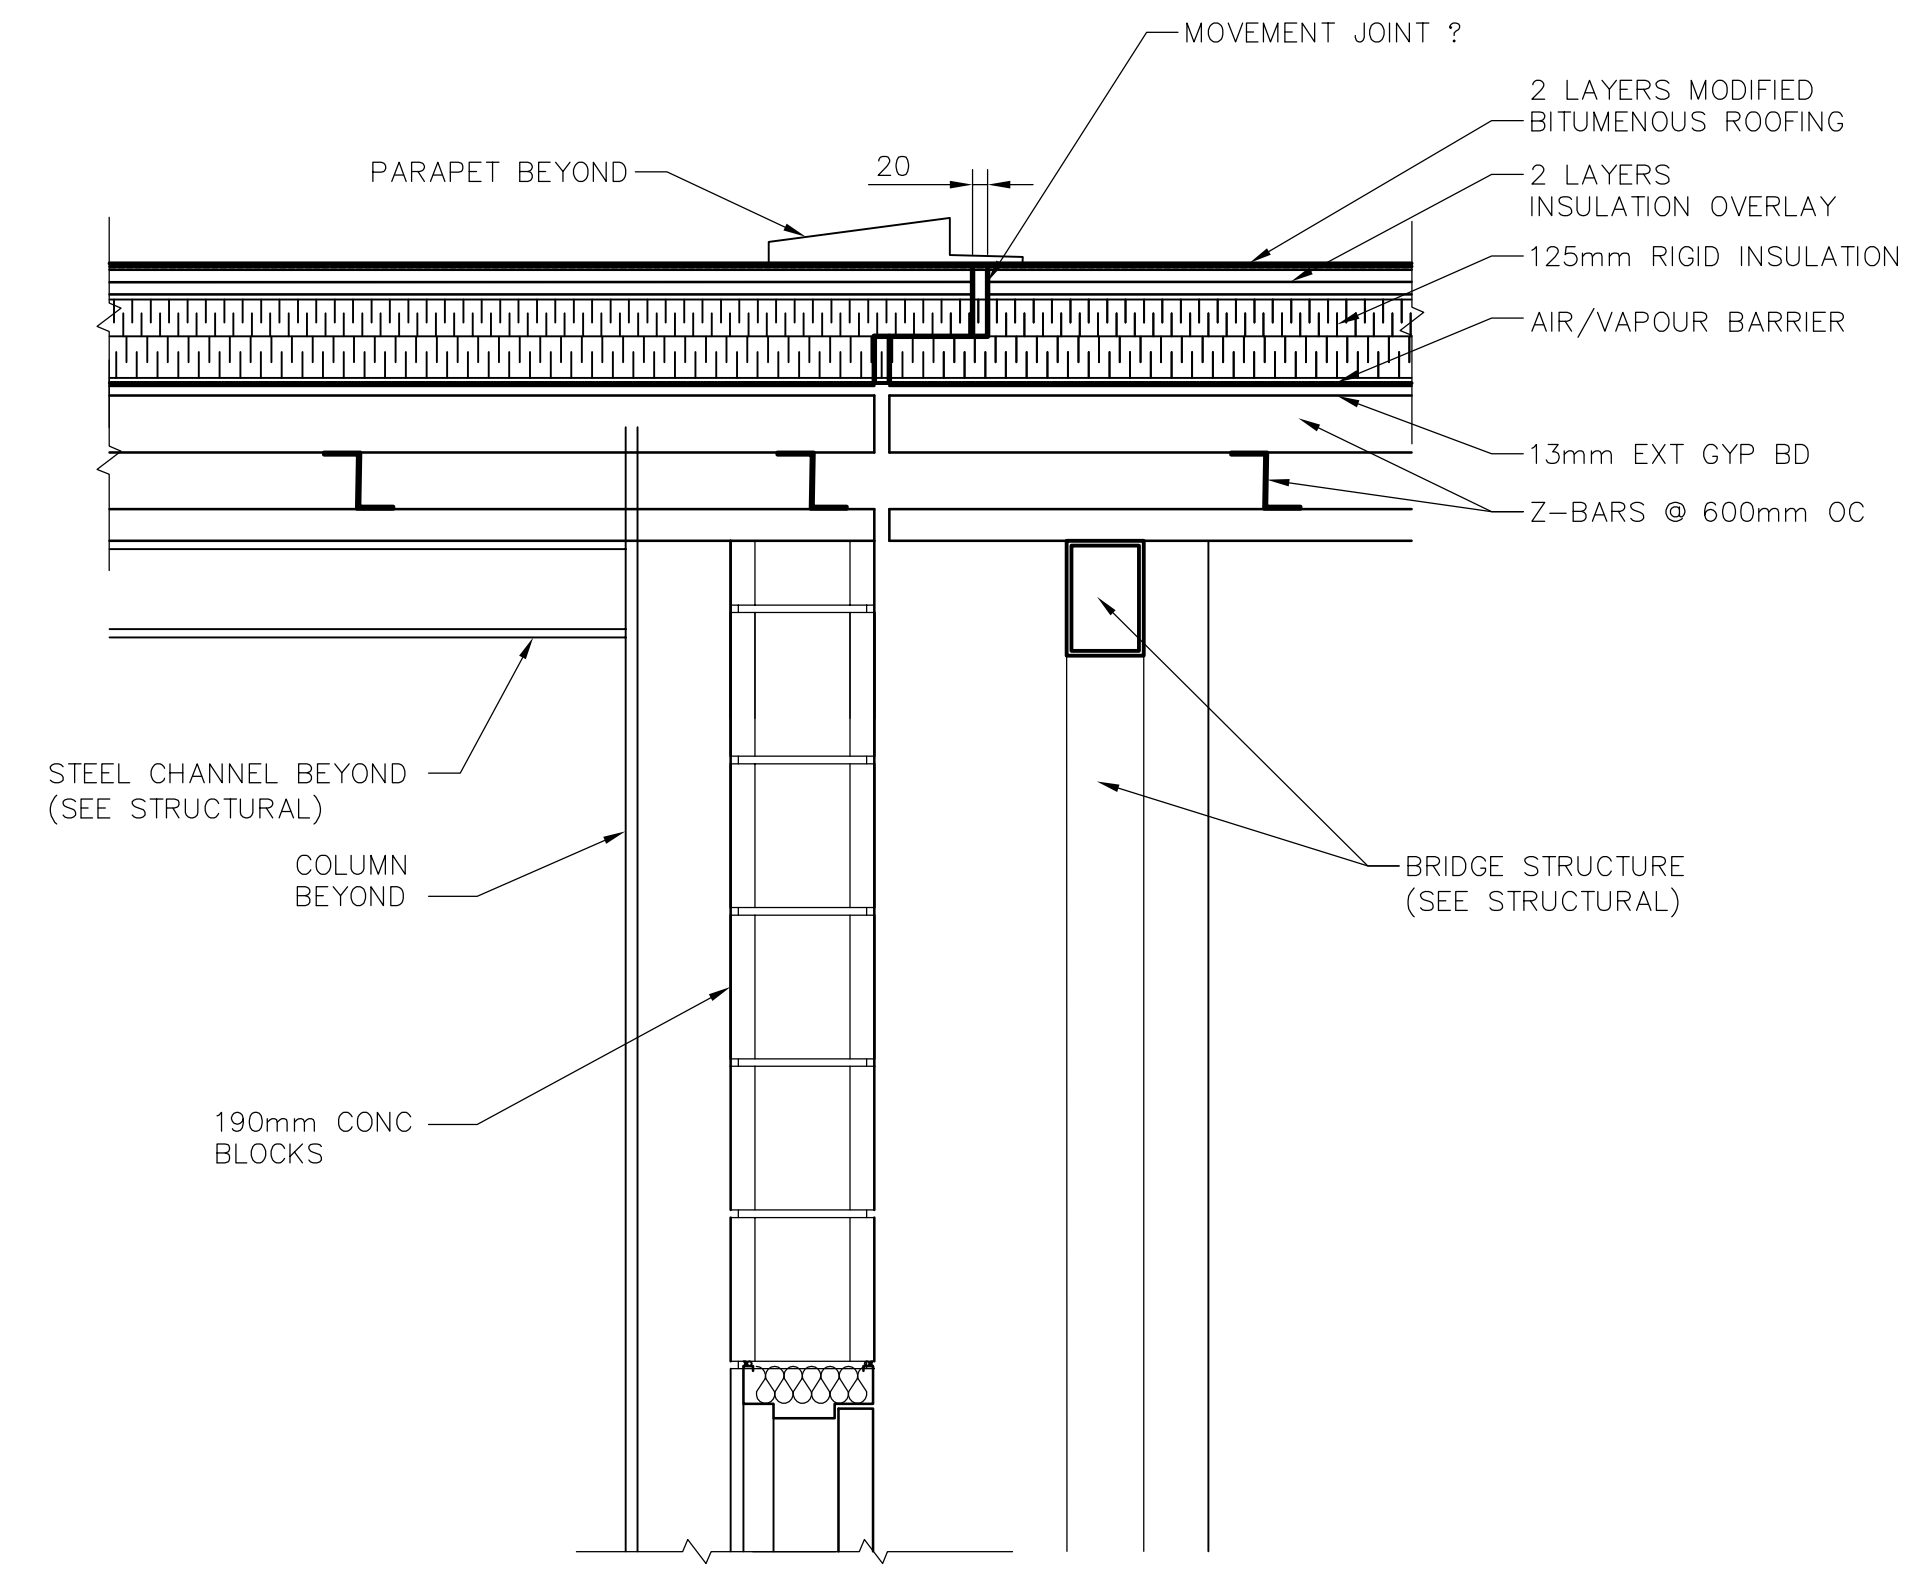

**2 DETAIL**  
WS-B0404 1:10



B.M. ELEV.			
DESIGNED BY	NC	CHECKED BY	LK
DRAWN BY	AL	APPROVED BY	AHL
SCALE:	AS SHOWN	RELEASED FOR CONSTRUCTION BY:	R. SOROKOWSKI
00 ISSUED FOR TENDER	07/01/31	DATE	2006/10/02
NO. REVISIONS	DATE	BY	DATE

DESIGNED BY	NC	CHECKED BY	LK
DRAWN BY	AL	APPROVED BY	AHL
SCALE:	AS SHOWN	RELEASED FOR CONSTRUCTION BY:	R. SOROKOWSKI
00 ISSUED FOR TENDER	07/01/31	DATE	2006/10/02
NO. REVISIONS	DATE	BY	DATE

ENGINEER'S SEAL	
ORIGINAL SIGNED BY	NEIL COOPER
	2007/01/31
CONSULTANT DRAWING NO.	WS-B0404

<b>THE CITY OF WINNIPEG</b> WATER AND WASTE DEPARTMENT ENGINEERING DIVISION	
WATER TREATMENT PLANT BULK CHEMICAL BUILDING SODIUM HYPOCHLORITE AND CHEMICAL STORAGE BUILDING	CITY FILE NUMBER SHEET OF CITY DRAWING NUMBER 1-0601S-A-B0404-001-000
ARCHITECTURAL ROOF PLAN OF BRIDGE AND DETAILS	