


1 FOUNDATION PLUMBING PLAN
1:75

DRAWING NOTES	
1	ALL SANITARY LINES @ 1% SLOPE.
2	100Ø SANITARY LINE CONNECT TO SITE SERVICES. SEE CIVIL DWG. WH-C0204.
3	75Ø STUB UP TO FLOOR DRAIN.
4	40Ø STUB UP.
5	25Ø STUB UP.
6	75Ø STUB UP TO SECOND LEVEL
7	75Ø DOWN TO MAIN SANITARY LINE
8	75Ø STUB UP TO FLOOR DRAIN C/W TRAP PRIMER CONNECTION.
9	PROVIDE RUNNING TRAP C/W CLEAN OUT AND CLEAN OUT COVER AND TRAP PRIMER CONNECTION.
10	75Ø SANITARY VENT LINE UP TO ROOF.
11	30Ø SANITARY STAND PIPE FOR WATER SOFTENER DISCHARGE AND CONDENSATE LINE FROM SECOND LEVEL AHU.
12	75Ø SANITARY LINE FOR RAIL CAR EMERGENCY SHOWER.

DRAWING NOTES	
13	30Ø SANITARY AT HIGH LEVEL FOR CONDENSATE DRAIN.
14	12Ø TRAP PRIMERS FROM MANIFOLD IN MECHANICAL ROOM.

GENERAL NOTES	
1.	MECHANICAL CONTRACTOR SHALL COORDINATE WITH OTHER TRADES. REPORT DISCREPANCIES TO MECHANICAL ENGINEER.
2.	MECHANICAL CONTRACTOR SHALL INSULATE ALL DOMESTIC COLD, HOT, RECERC. TEMPERED AND PROCESS HOT WATER LINES.
3.	MECHANICAL CONTRACTOR SHALL PROVIDE TRAP PRIMERS FOR ALL FLOOR DRAINS.
4.	MECHANICAL CONTRACTOR SHALL SLOPE SANITARY LINE AT 1% SLOPE.

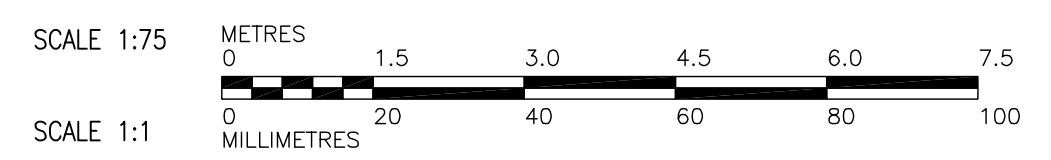

 Certificate of Authorization Earth Tech Canada Inc. No. 730 Expiry: April 30, 2007	B.M. ELEV.	 Frederickson Cooper ARCHITECTS	 A Tyco International Ltd. Company	ENGINEER'S SEAL	 THE CITY OF WINNIPEG WATER AND WASTE DEPARTMENT ENGINEERING DIVISION		
				DESIGNED BY: DJP		CHECKED BY: PVL/AMA	ORIGINAL SIGNED BY: A. M. AFTANAS
				DRAWN BY: DJP		APPROVED BY: AHL	2007/01/31
				SCALE: 1:75		RELEASED FOR CONSTRUCTION BY: R. SOROKOWSKI	CONSULTANT DRAWING NO. WS-H0100
	00 ISSUED FOR TENDER 07/01/31 DJP				WATER TREATMENT PLANT BULK CHEMICAL STORAGE SODIUM HYPOCHLORITE AND CHEMICAL STORAGE BUILDING		
	NO. REVISIONS DATE BY DATE				MECHANICAL FOUNDATION PLUMBING PLAN		
					CITY FILE NUMBER SHEET OF CITY DRAWING NUMBER 1-0601S-A-H0100-001-000		