




7 WALL SECTION  
WB-B0205 1 : 50

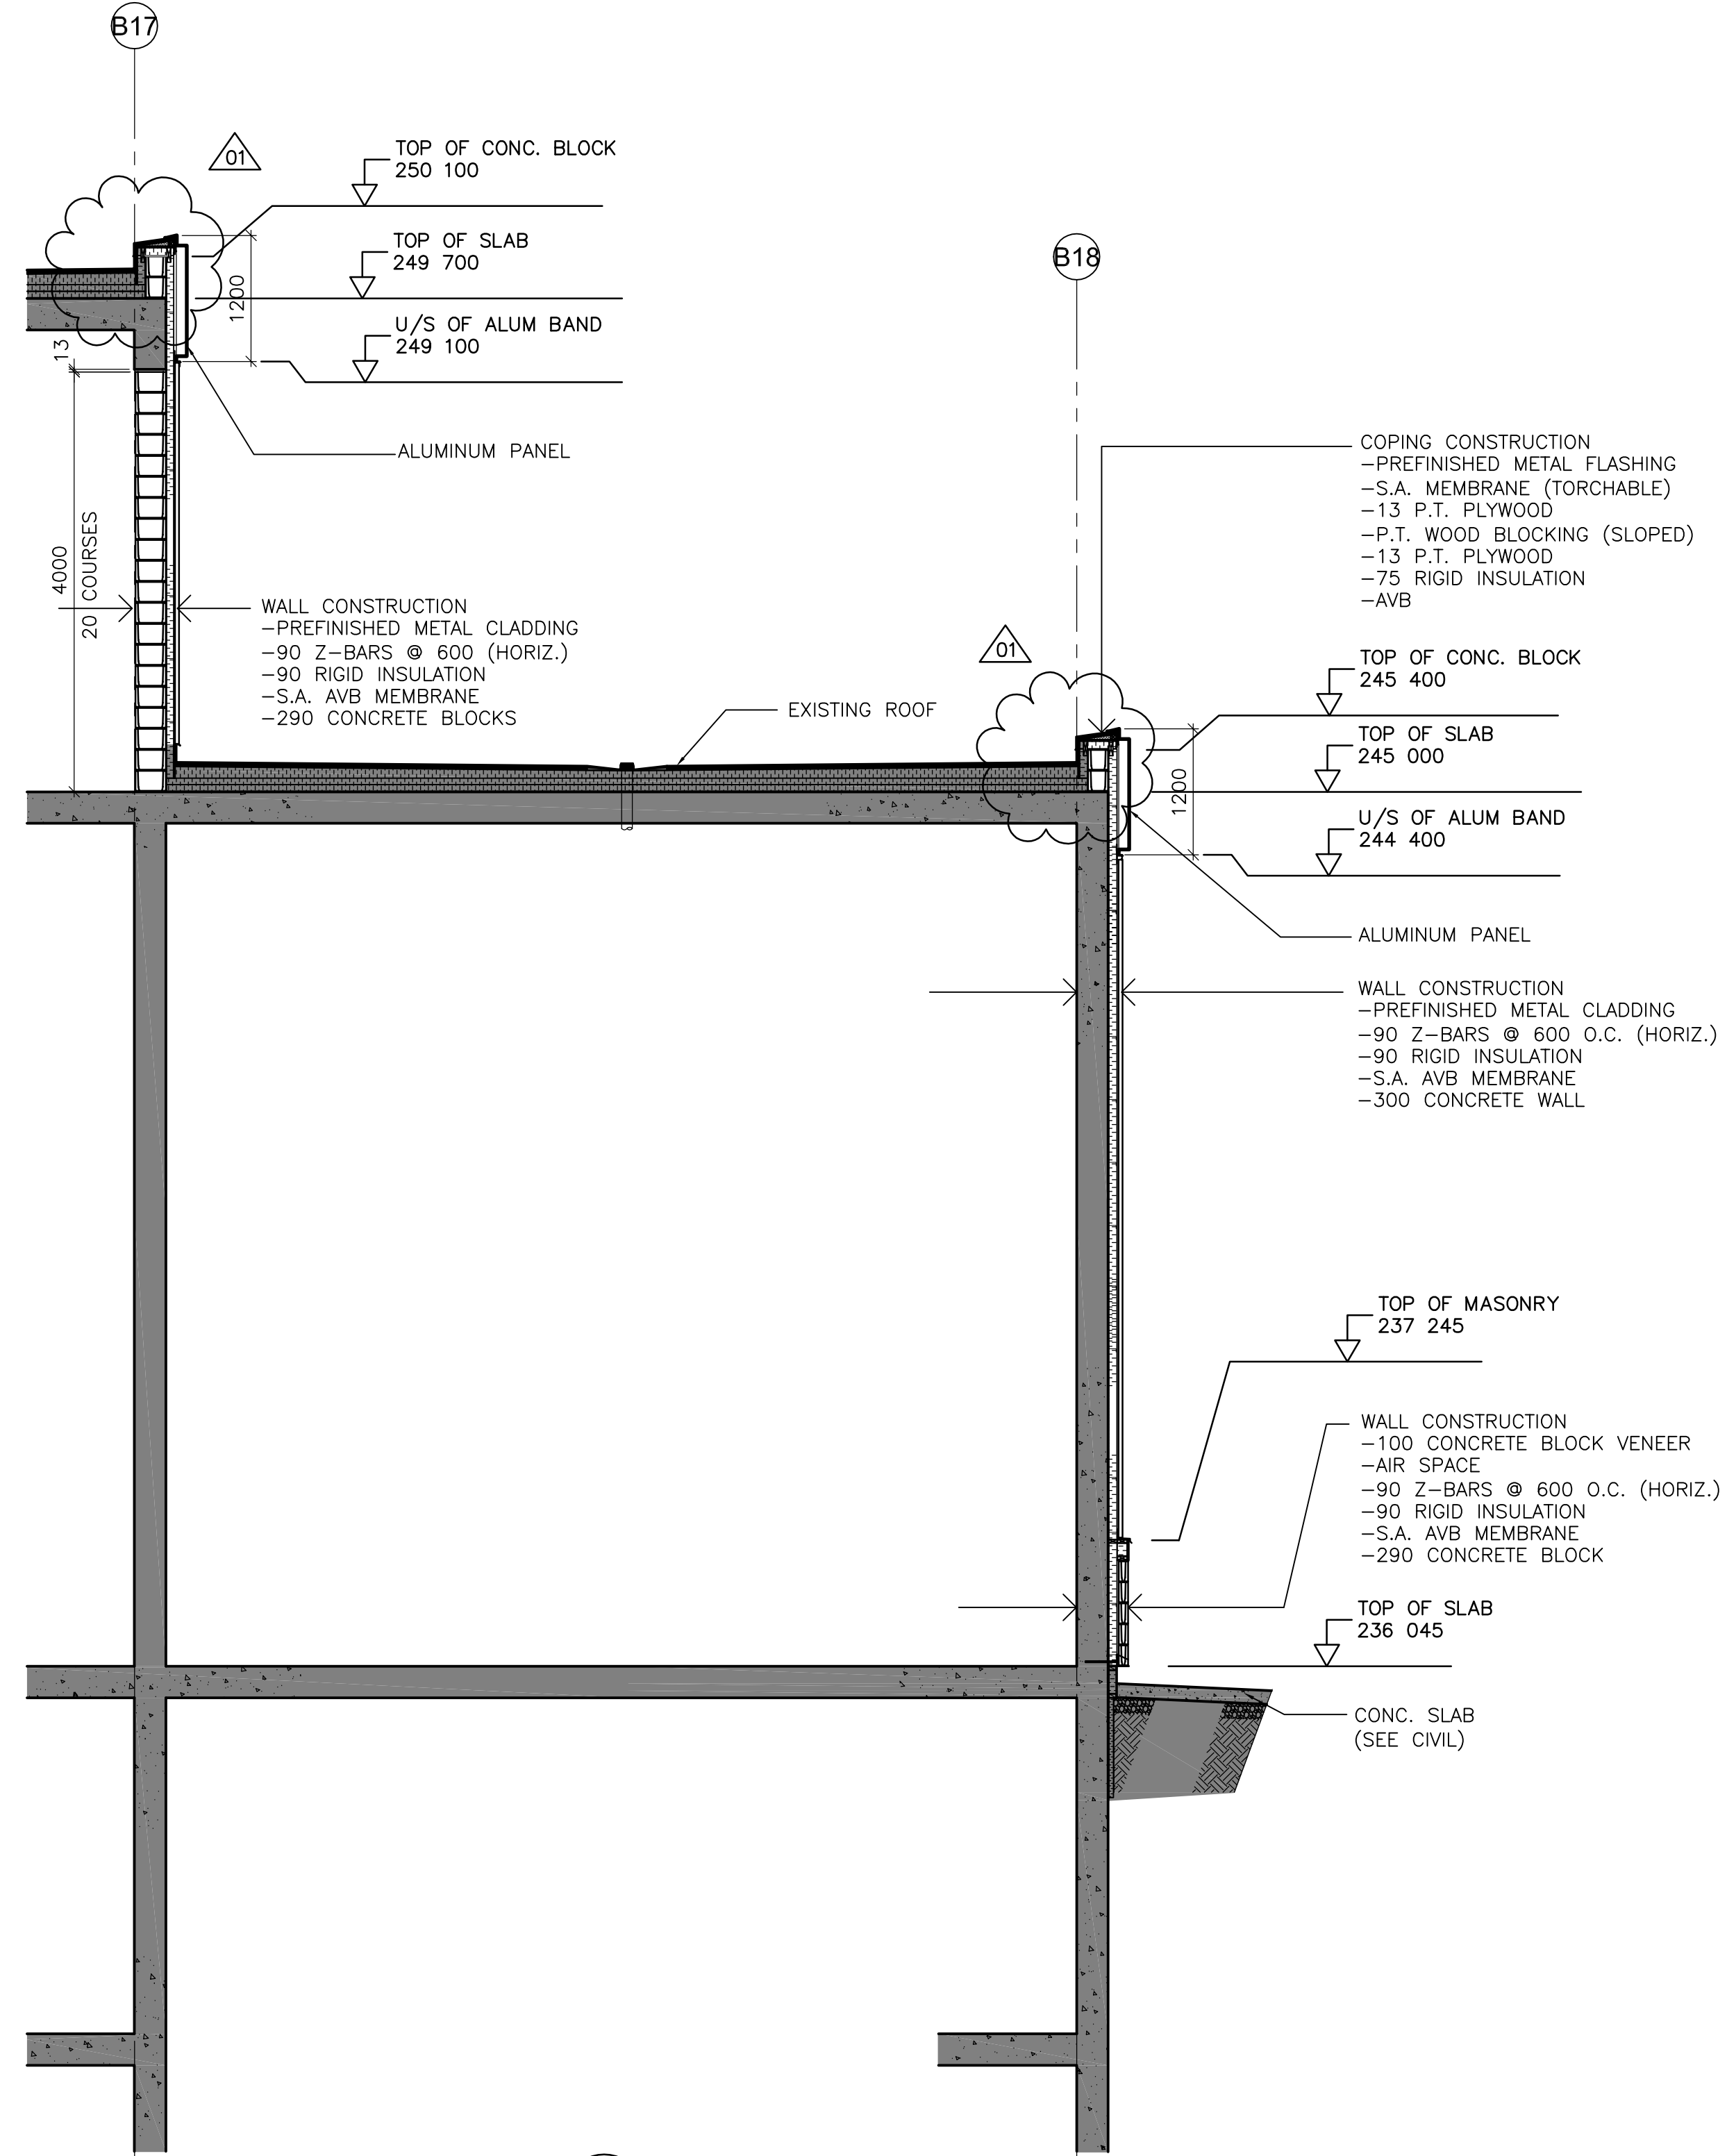

8 WALL SECTION  
WB-B0204 1 : 50

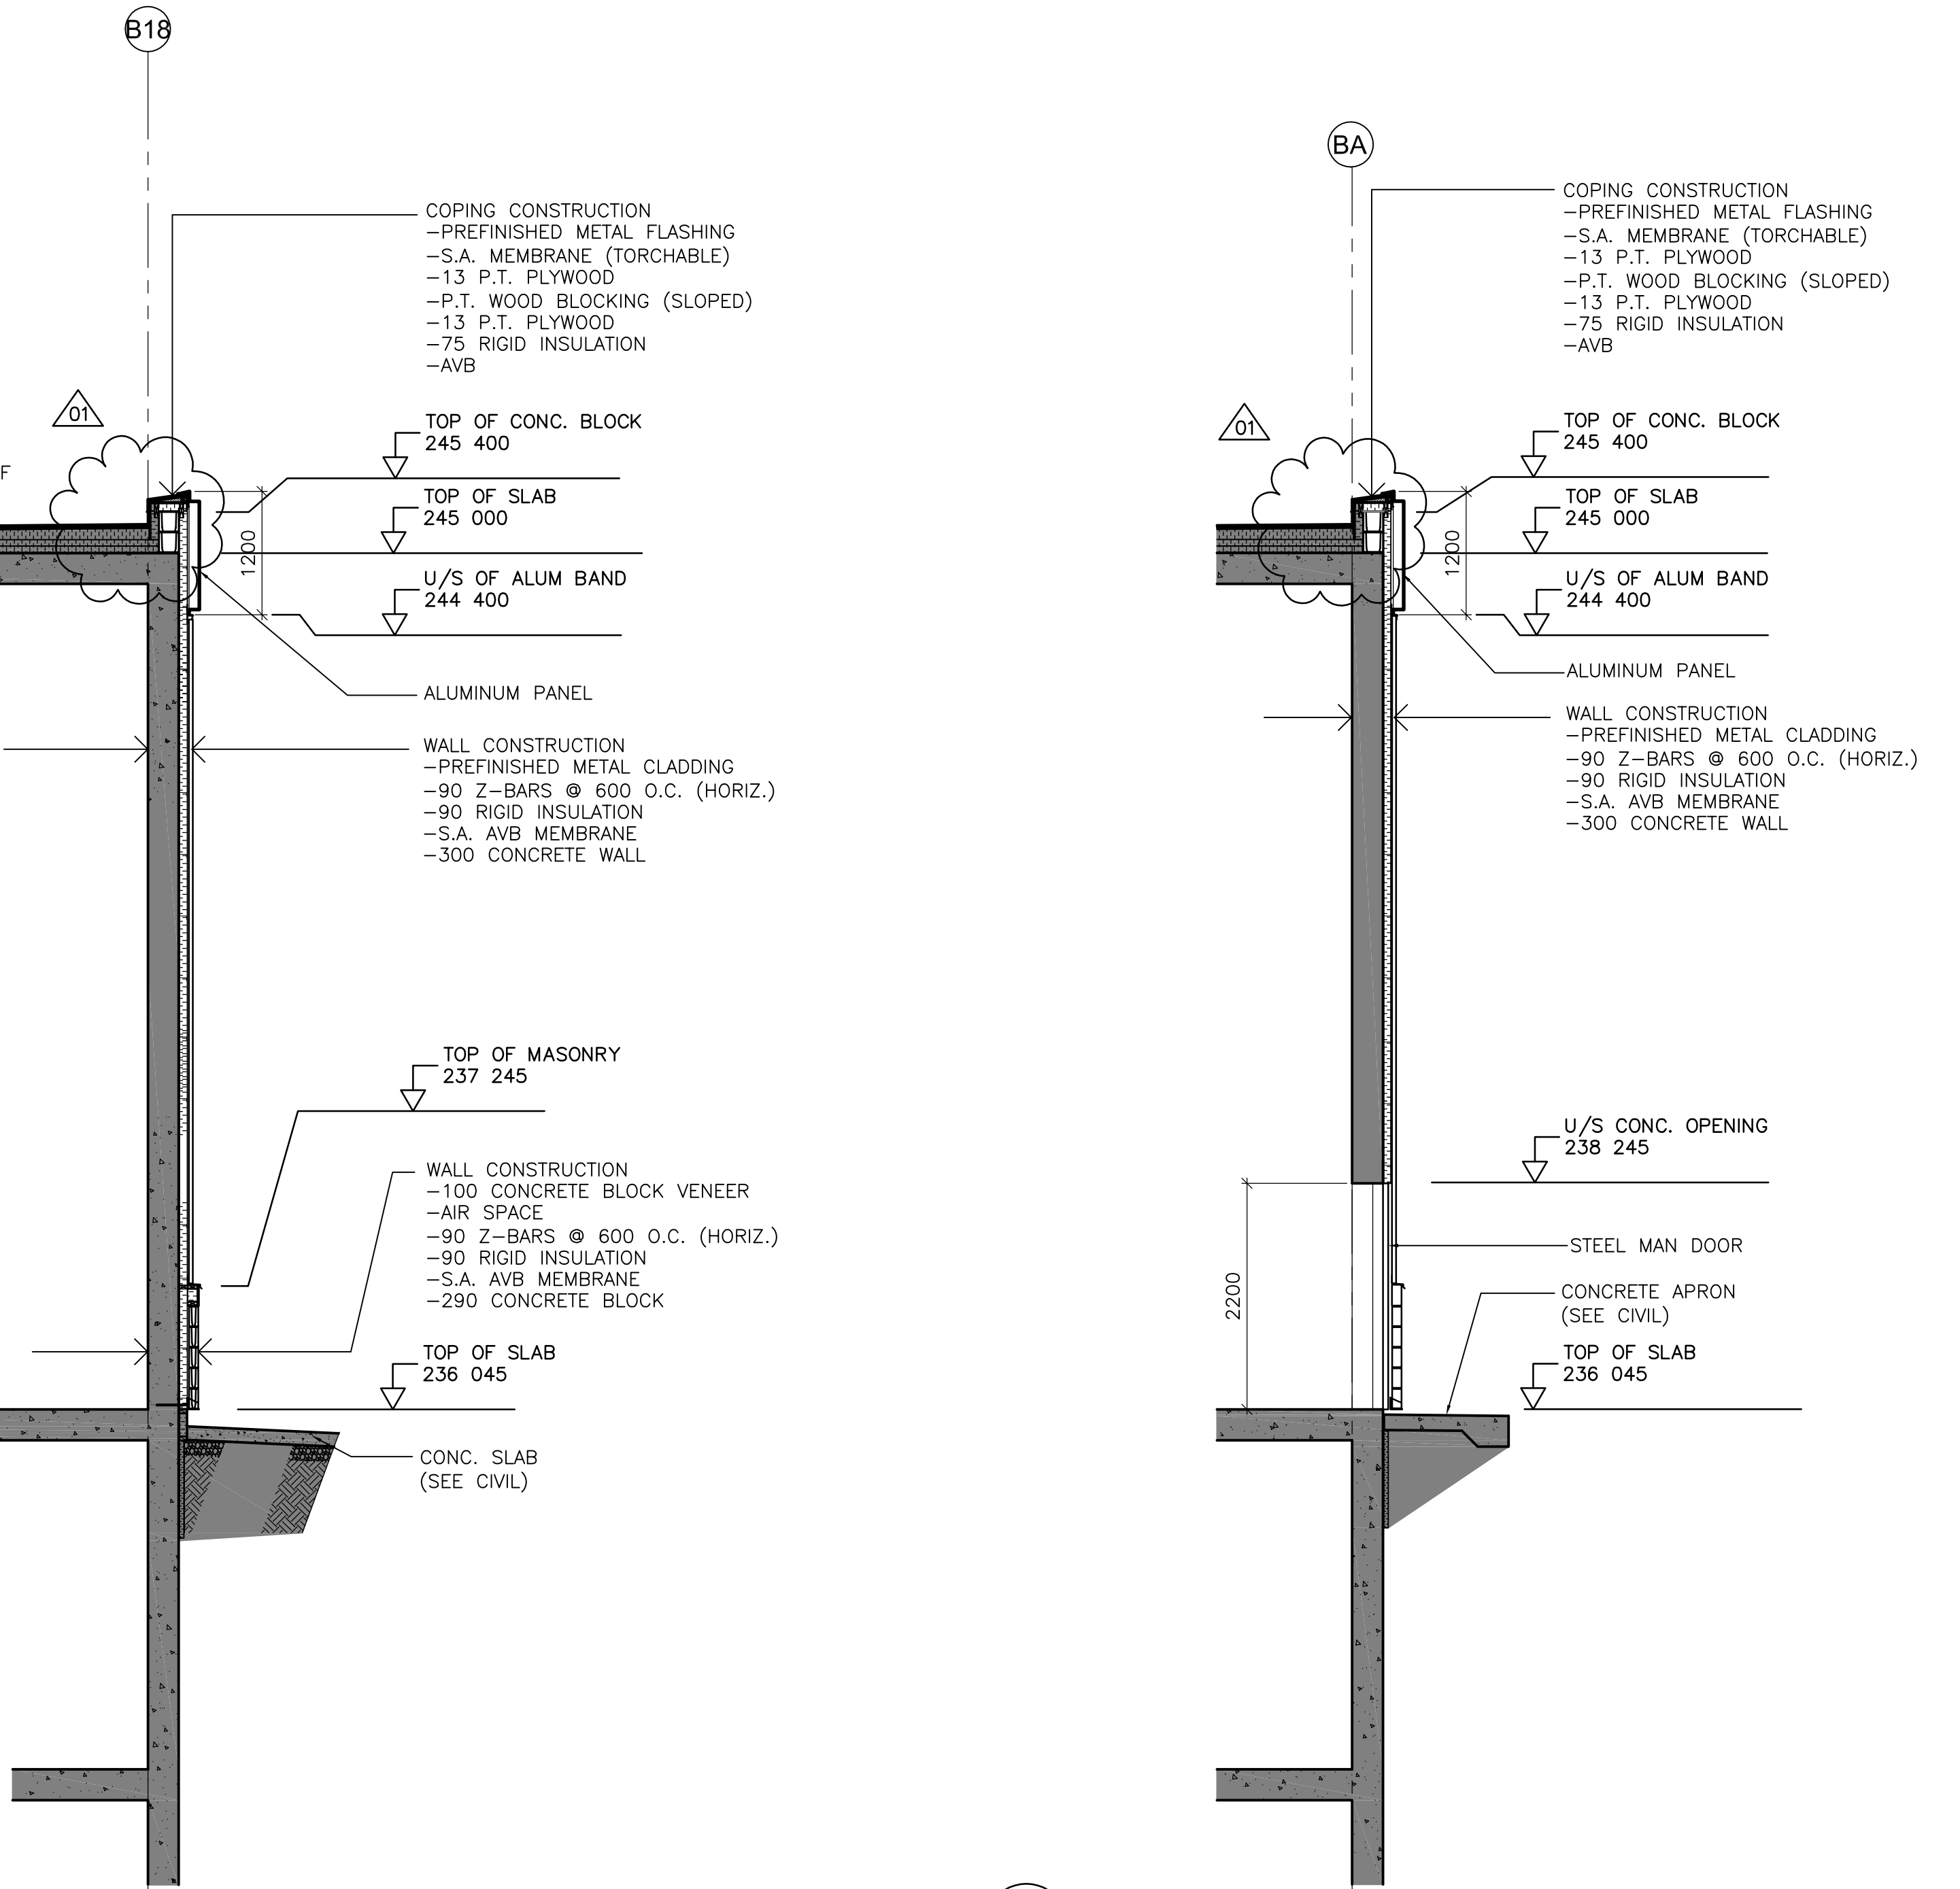

9 WALL SECTION  
WB-B0110 1 : 50

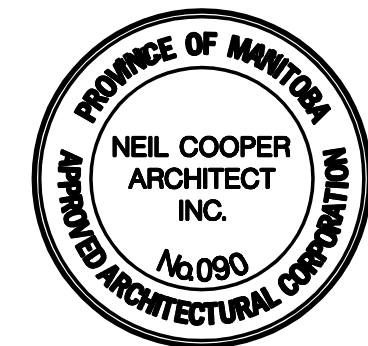

NO.	REVISIONS	DATE	BY
01	793-2006 ADDENDUM 1	07/03/29	LK
00	ISSUED FOR TENDER	07/03/19	LK

DESIGNED BY	NC	CHECKED BY	LK
DRAWN BY	AL	APPROVED BY	AHL
SCALE:	AS SHOWN	RELEASED FOR CONSTRUCTION BY:	R. SOROKOWSKI
DATE	2005/11/28	DATE	2007/03/19

ENGINEER'S SEAL	ORIGINAL SIGNED BY	NEIL COOPER
		2007/03/19
	CONSULTANT DRAWING NO.	WB-B0252

WATER TREATMENT PLANT MAIN BUILDING BUILDING ENVELOPE	CITY FILE NUMBER SHEET OF CITY DRAWING NUMBER 1-06018-A-B0252-001-010