


10 WALL SECTION
WB-B0110 1 : 50

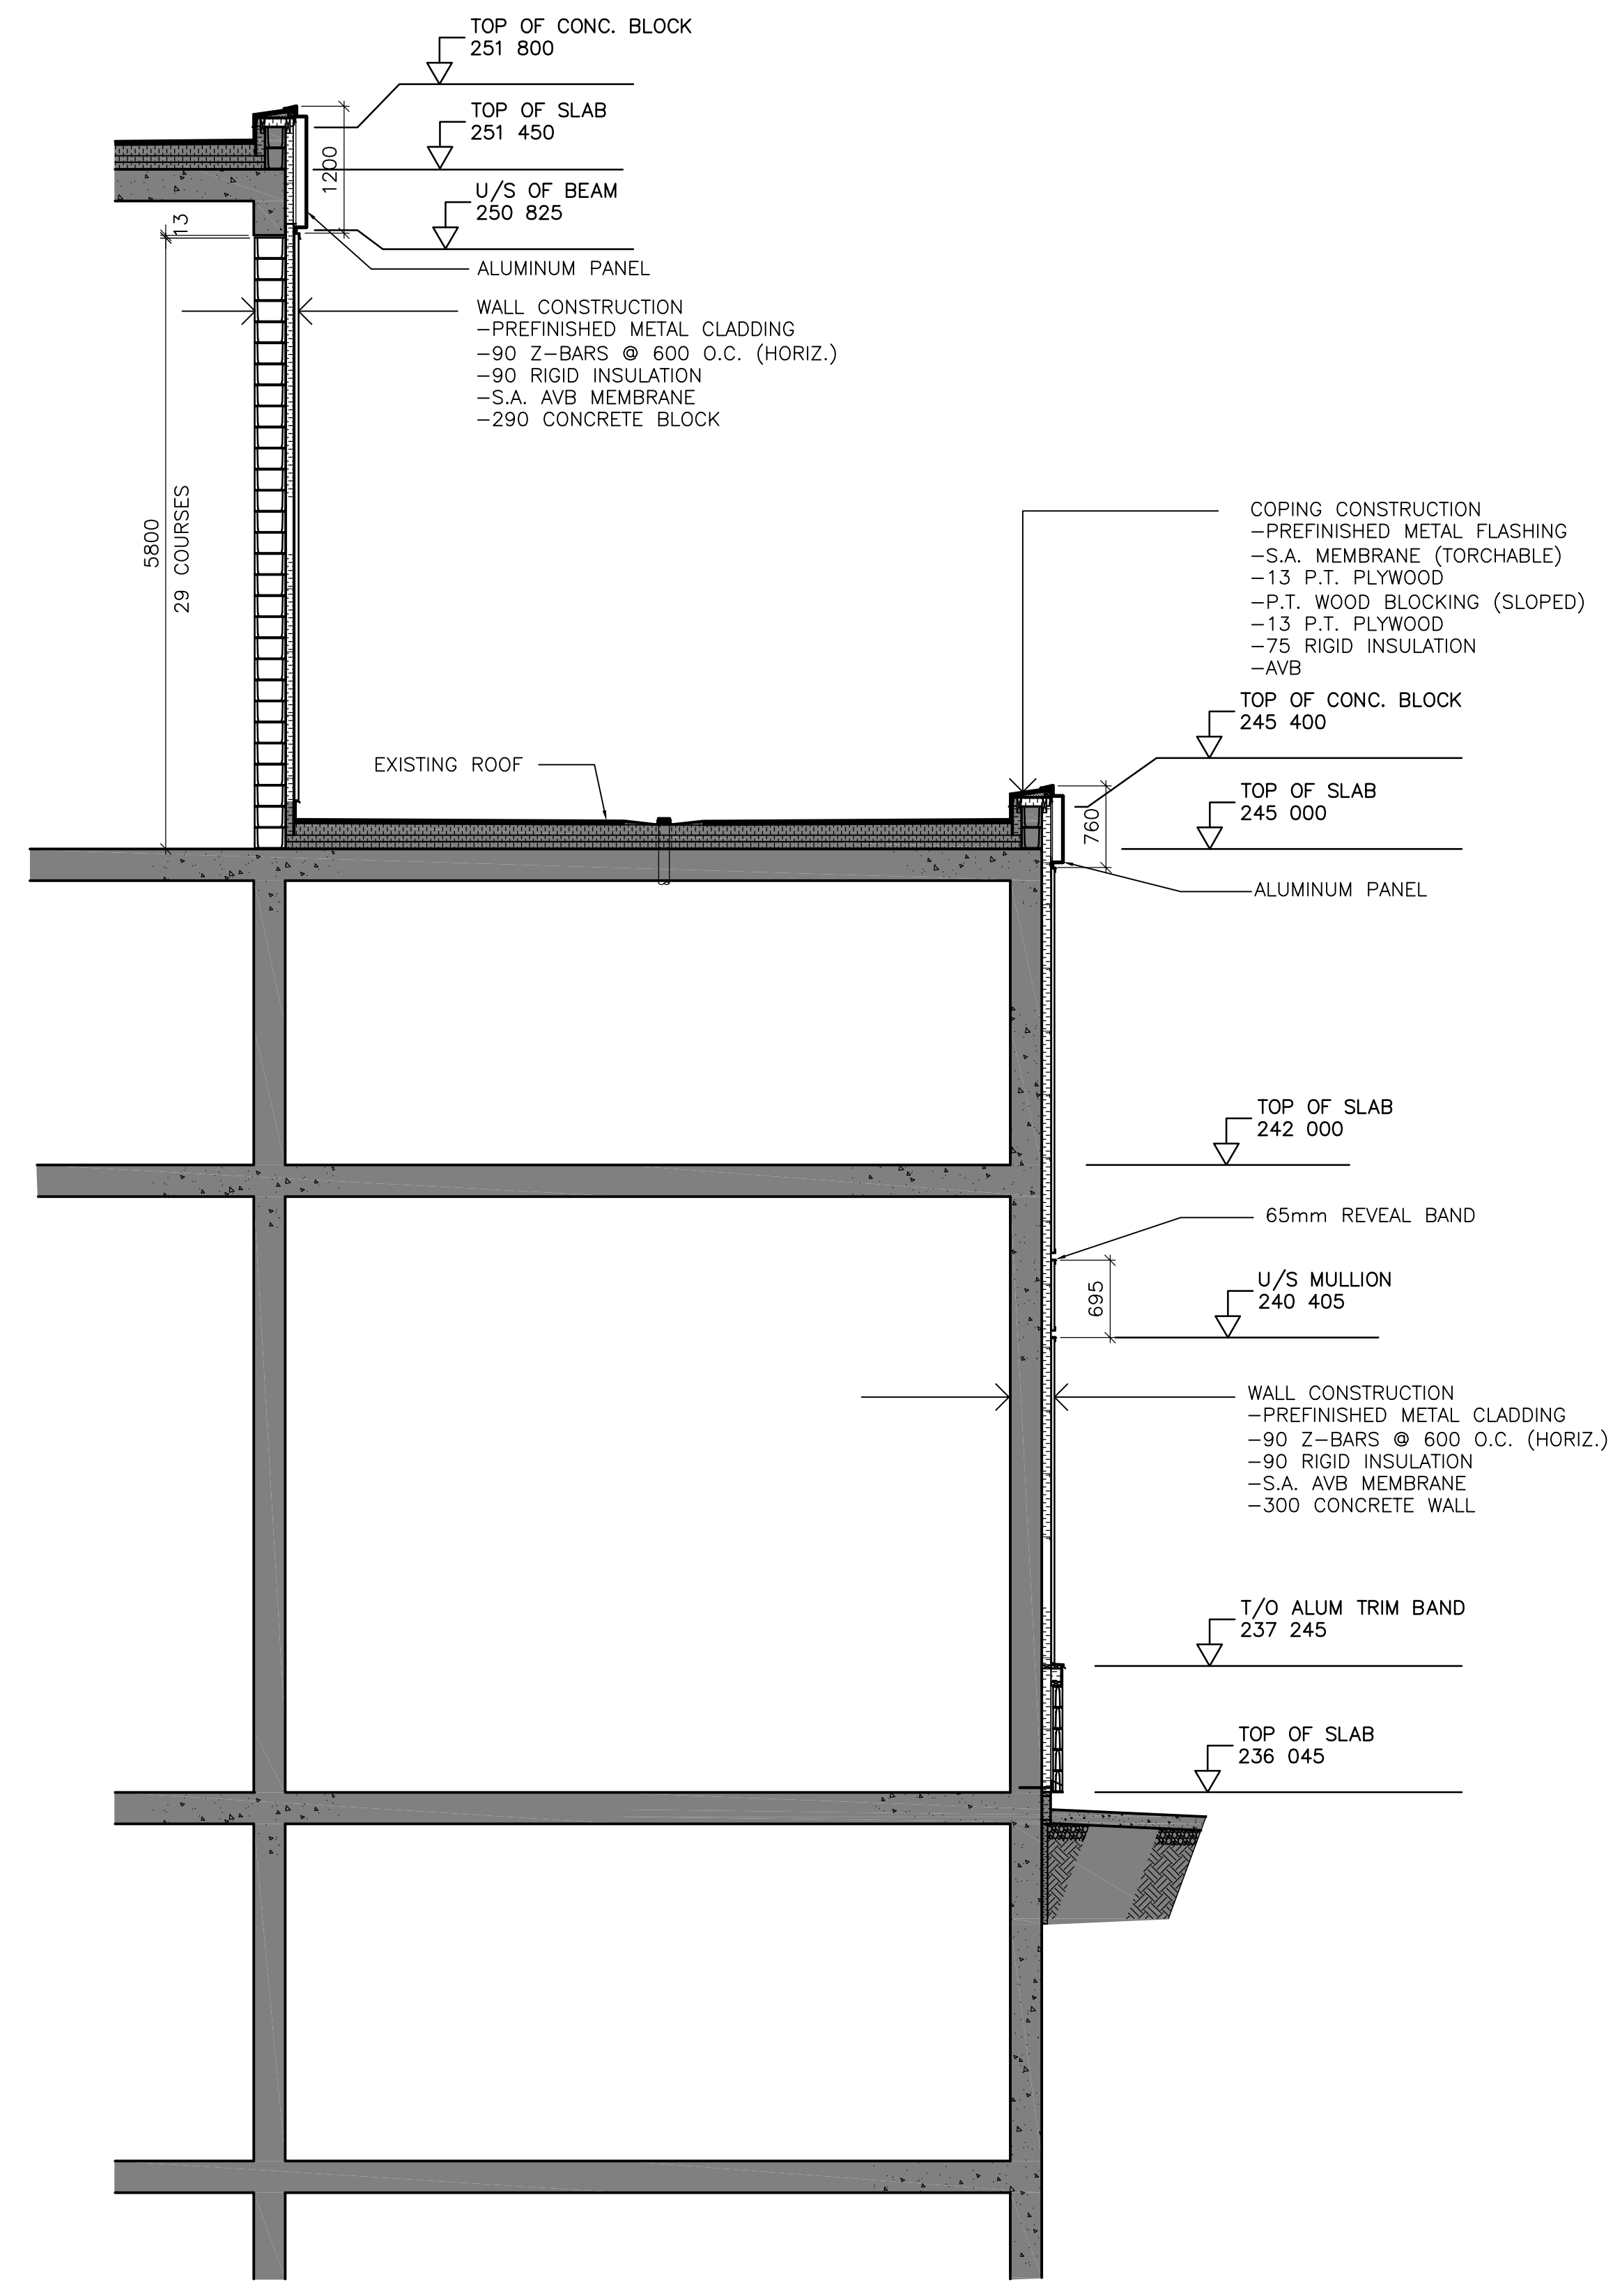

11 WALL SECTION
WB-B0206 1 : 50



B.M. ELEV.			
DESIGNED BY	NC	CHECKED BY	LK
DRAWN BY	IC	APPROVED BY	AHL
SCALE:	AS SHOWN	RELEASED FOR CONSTRUCTION BY:	R. SOROKOWSKI
ISSUED FOR TENDER	07/03/19	DATE	2005/11/28
NO. REVISIONS		DATE	2007/03/19

CH2MHILL
Frederickson Cooper ARCHITECTS

EarthTech
A Total International Ltd. Company

ENGINEER'S SEAL
ORIGINAL SIGNED BY
NEIL COOPER
2007/03/19

CONSULTANT DRAWING NO.
WB-B0253

THE CITY OF WINNIPEG
WATER AND WASTE DEPARTMENT
ENGINEERING DIVISION

WATER TREATMENT PLANT
MAIN BUILDING
BUILDING ENVELOPE

ARCHITECTURAL
WALL SECTIONS

CITY FILE NUMBER
SHEET OF
CITY DRAWING NUMBER
1-0601B-A-B0253-001-000