



12 WALL SECTION
WB-B0110 1 : 50

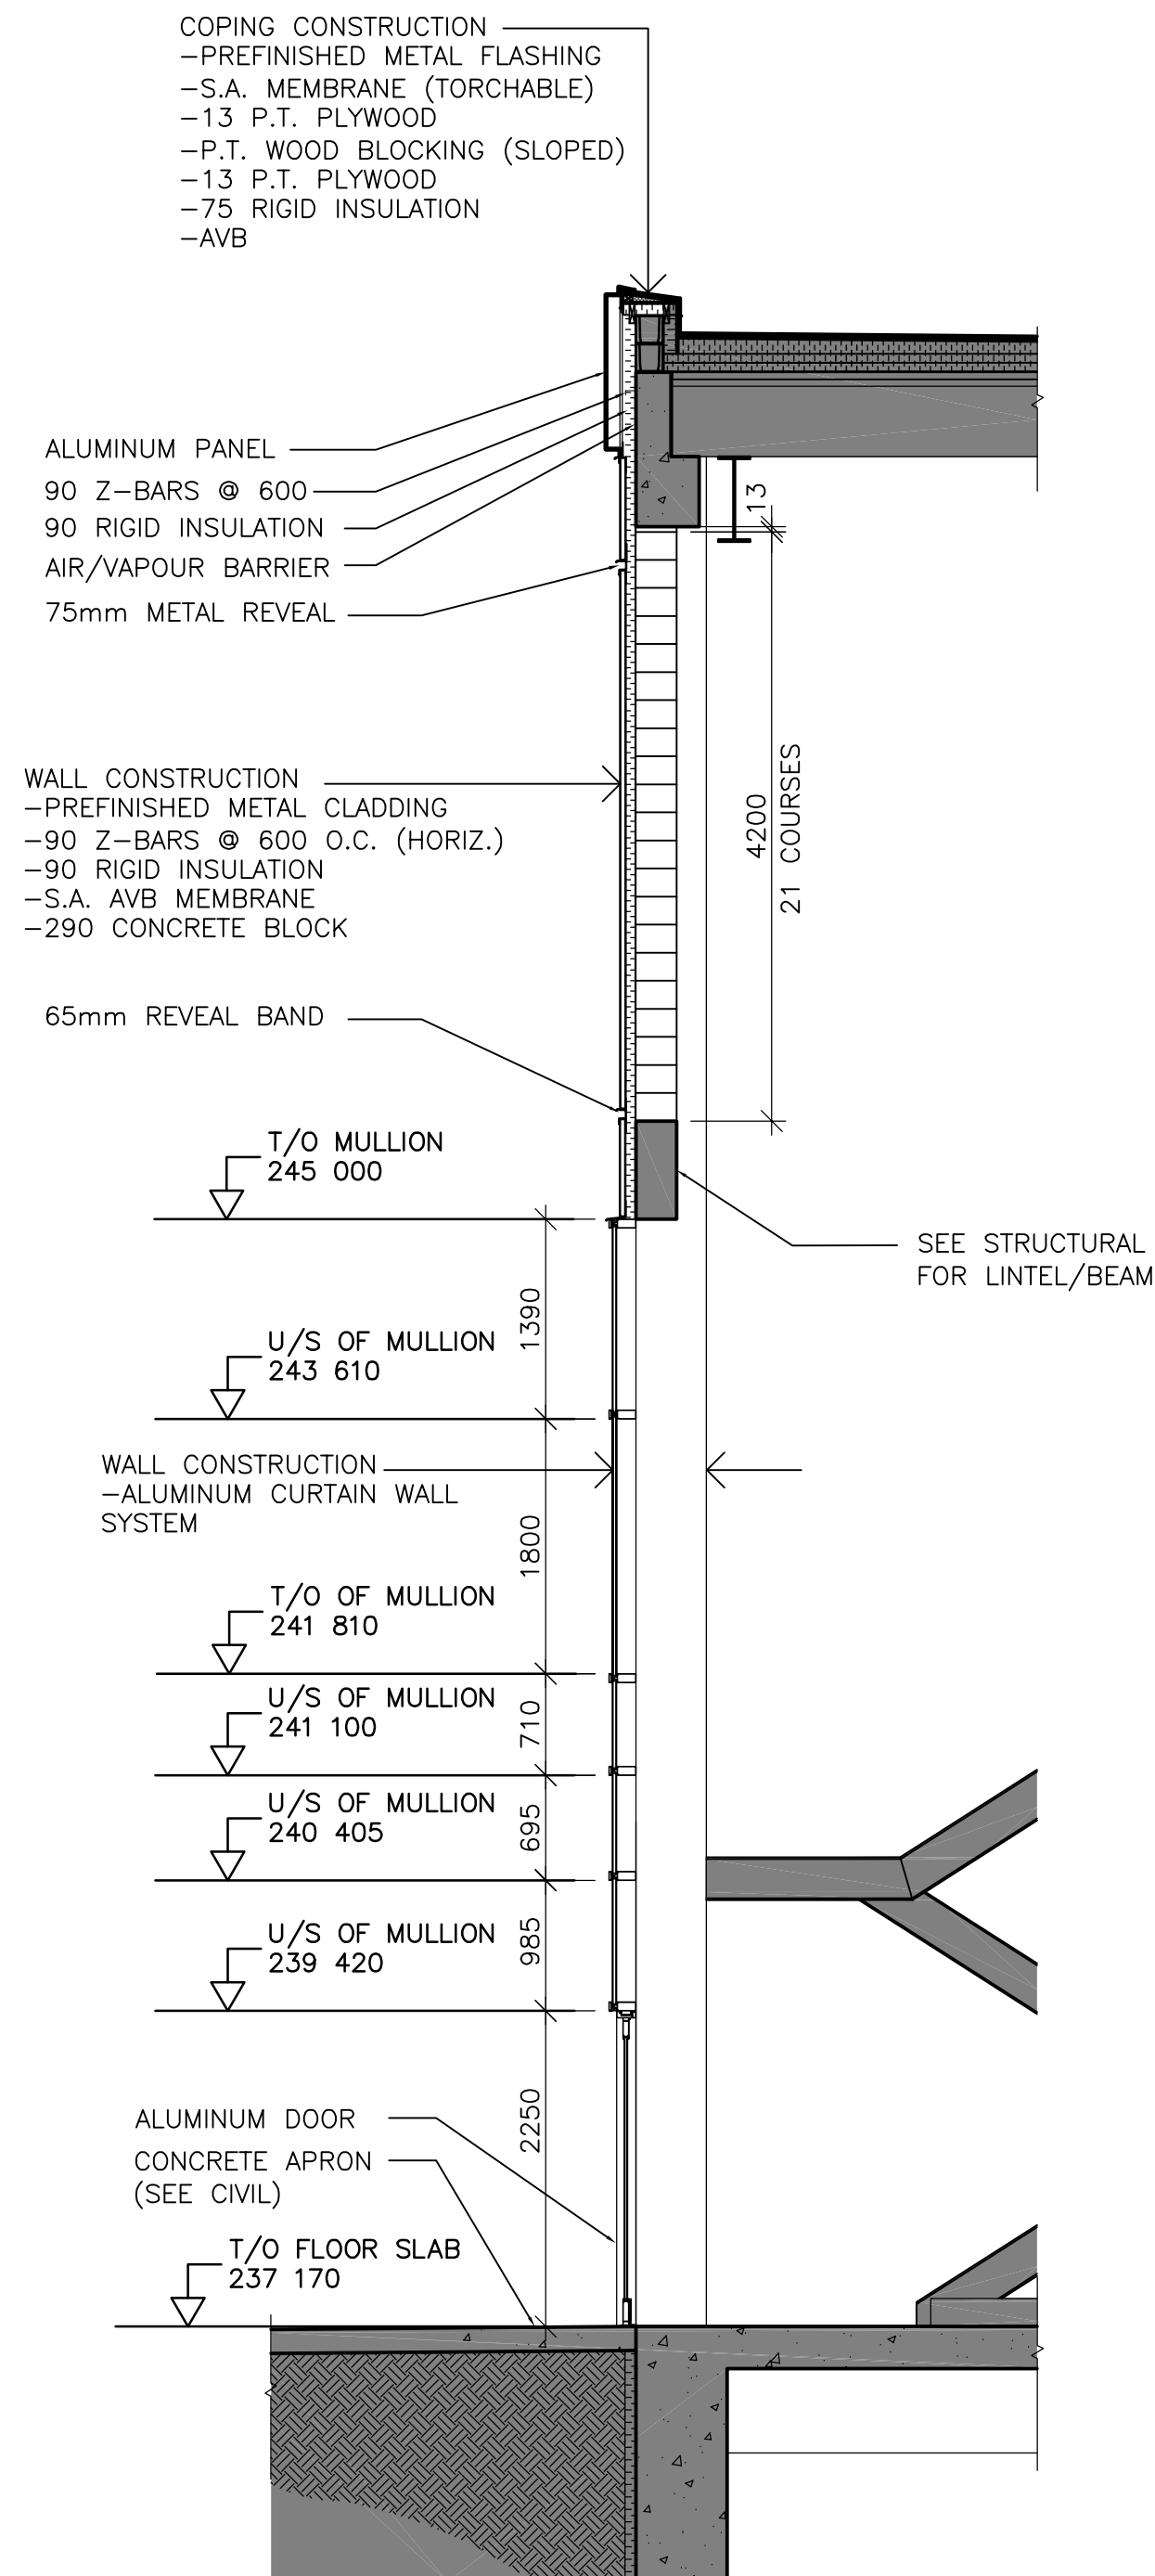

13 WALL SECTION
WB-B0110 1 : 50

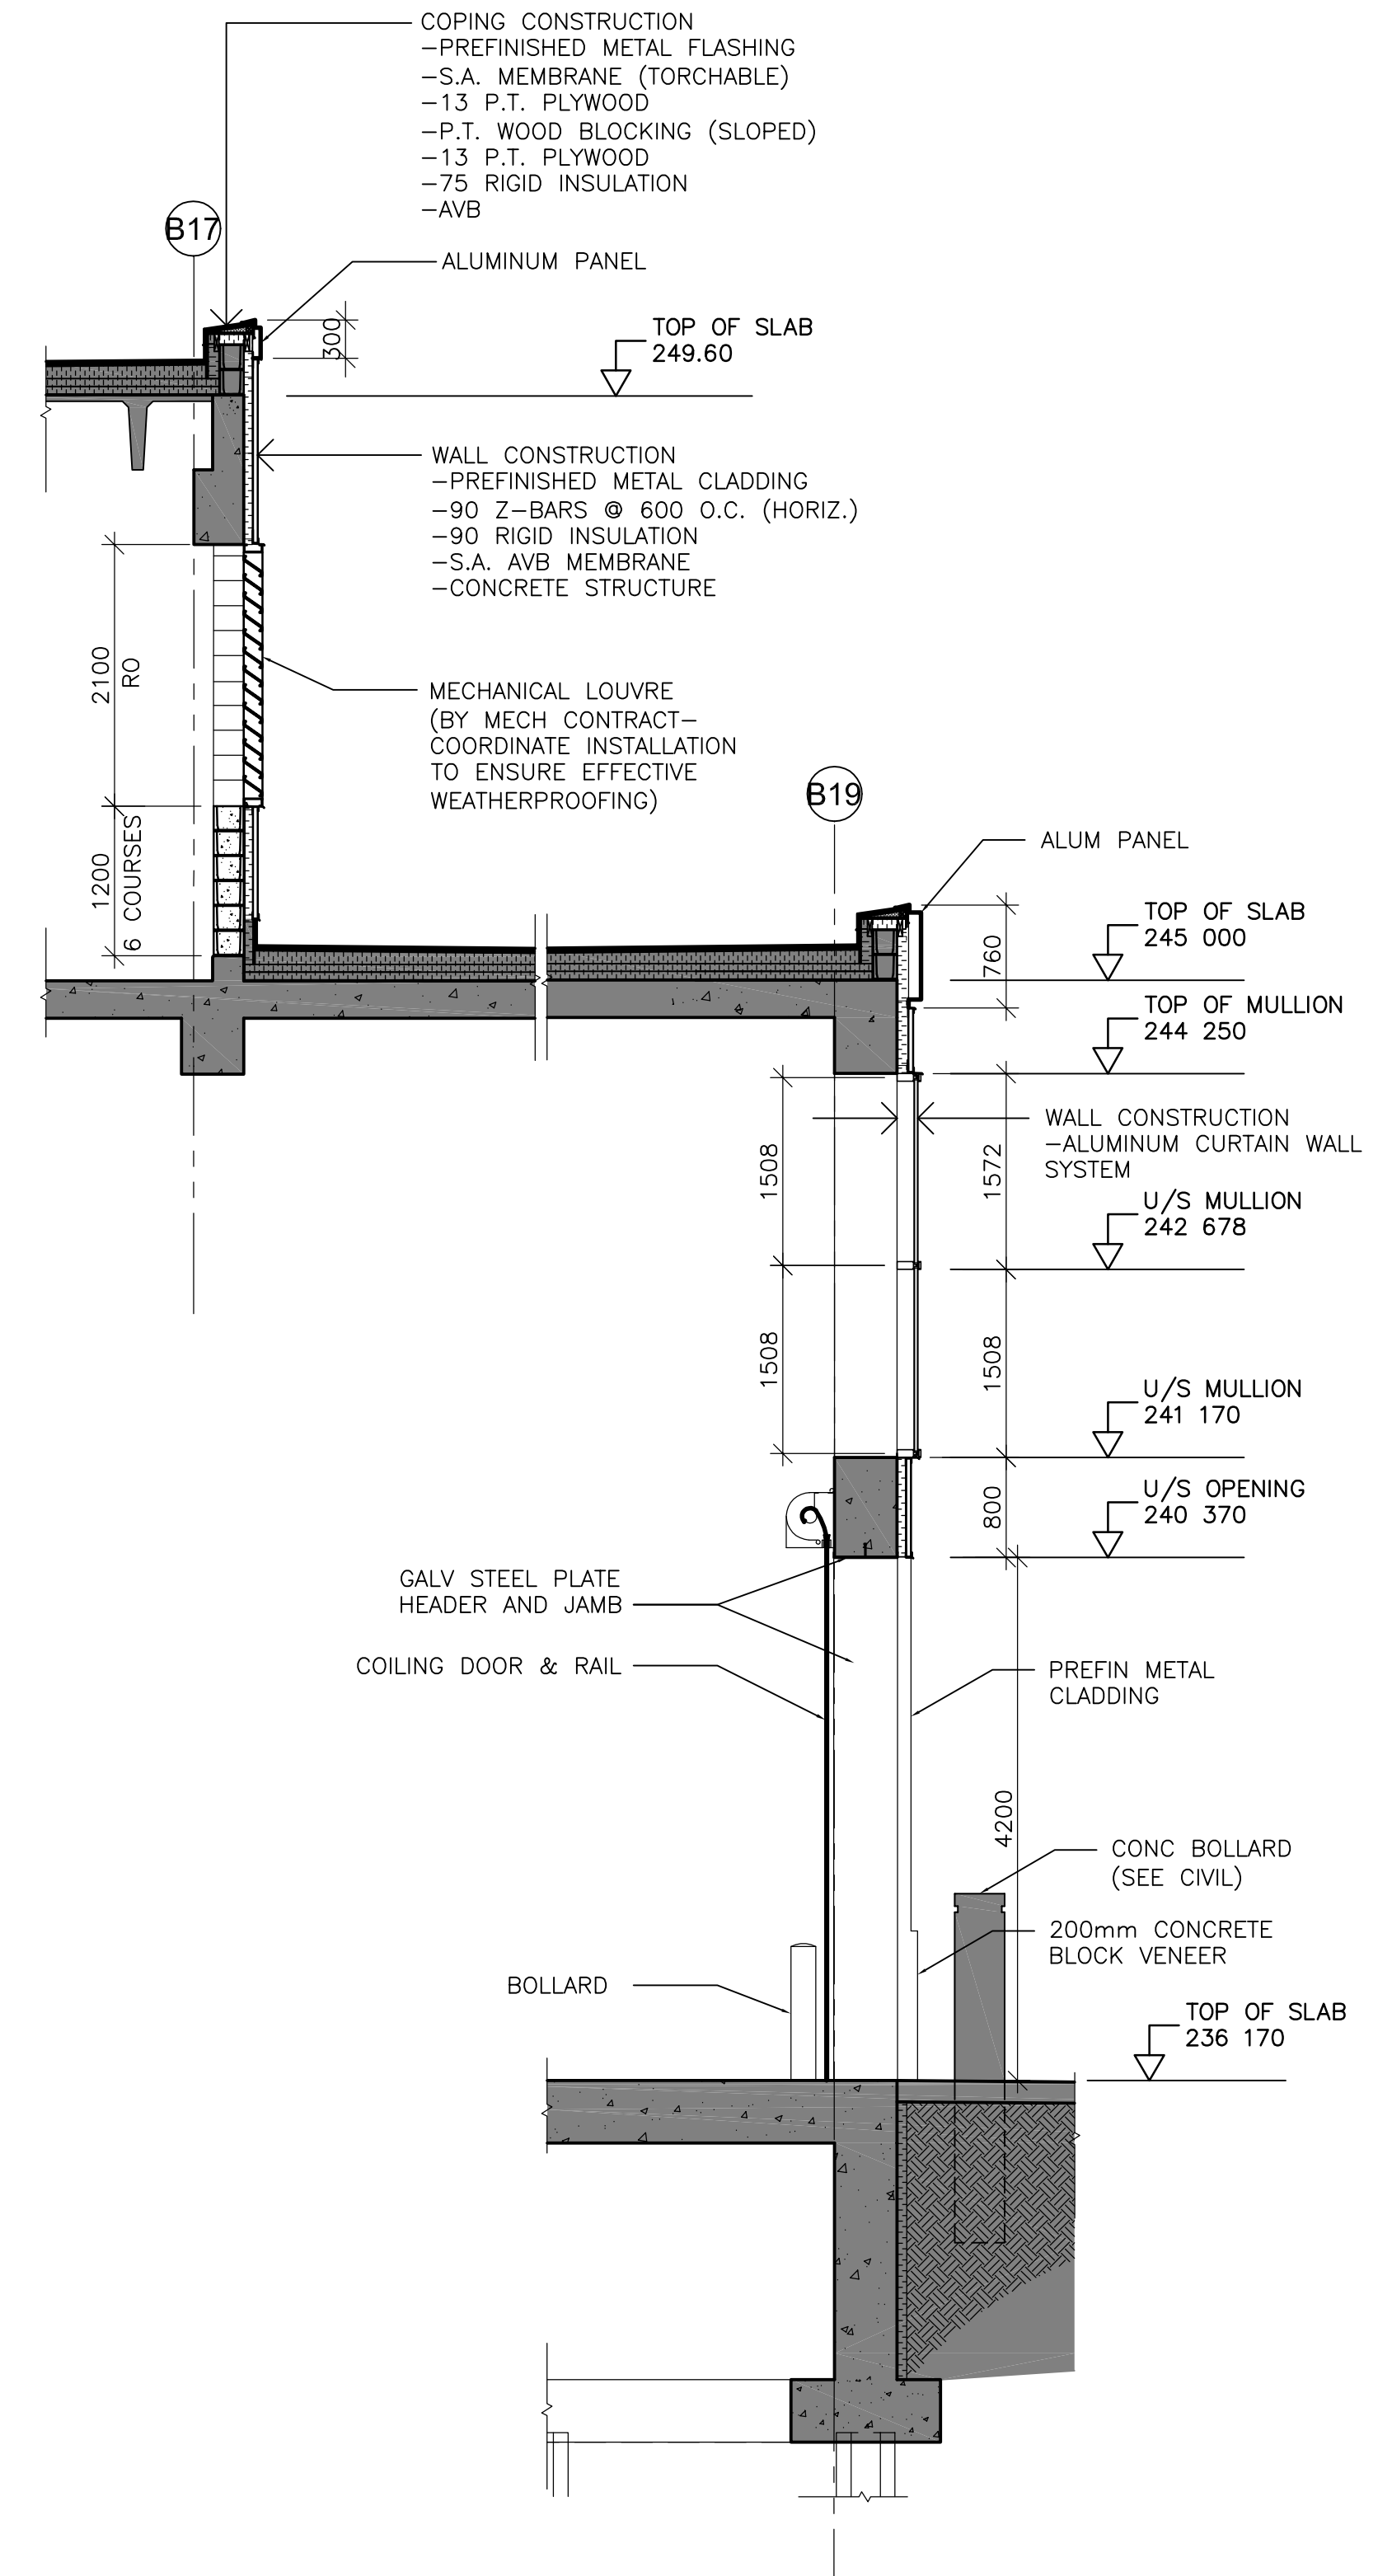

14 WALL SECTION
WB-B0110 1 : 50



B.M.	ELEV.

DESIGNED BY: NC		CHECKED BY: LK	
DRAWN BY: IC	APPROVED BY: AHL	RELEASED FOR CONSTRUCTION BY: R. SOROKOWSKI	DATE: 2007/03/19
SCALE: AS SHOWN		DATE: 2005/11/28	

THE CITY OF WINNIPEG WATER AND WASTE DEPARTMENT ENGINEERING DIVISION		ENGINEER'S SEAL ORIGINAL SIGNED BY NEIL COOPER 2007/03/19
WATER TREATMENT PLANT MAIN BUILDING BUILDING ENVELOPE		CONSULTANT DRAWING NO. WB-B0254
CITY FILE NUMBER	SHEET OF	CITY DRAWING NUMBER 1-0601B-A-B0254-001-000