


SOUTH ELEVATION
SCALE 1:200

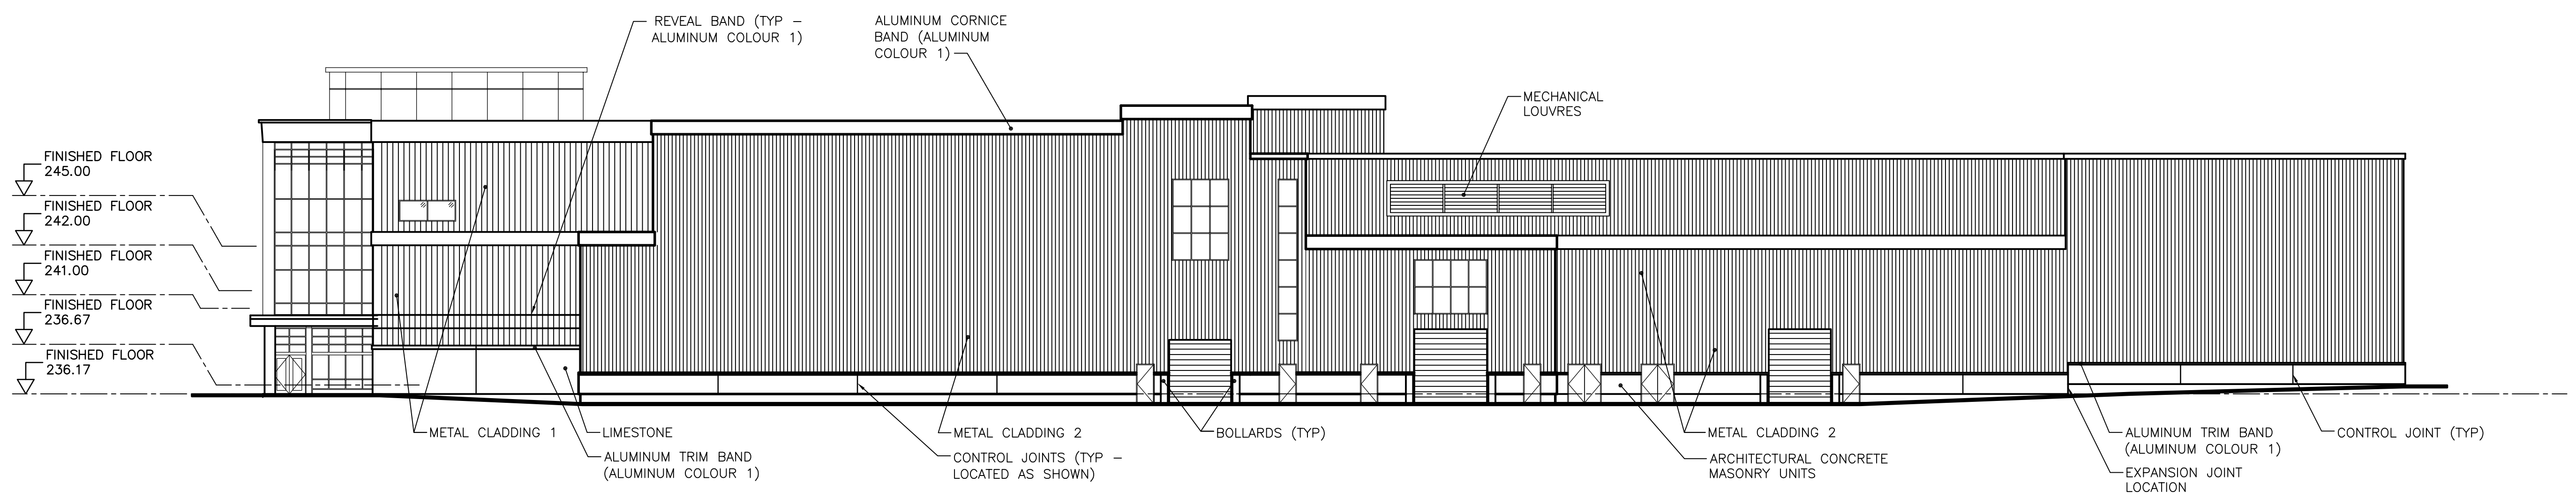

EAST ELEVATION
SCALE 1:200



B.M. ELEV.			
DESIGNED BY	TWS	CHECKED BY	BJS
DRAWN BY	SH/LK	APPROVED BY	AHL
SCALE:	1:300	RELEASED FOR CONSTRUCTION BY:	R. SOROKOWSKI
NO.	ISSUED FOR TENDER	DATE	07/03/19
	REVISIONS	DATE	2005/08/03
		BY	LK
		DATE	2005/08/03
		DATE	2007/03/19

CH2MHILL Frederickson Cooper ARCHITECTS	EarthTech A Top International LLC Company
ENGINEER'S SEAL	ORIGINAL SIGNED BY
	NEIL COOPER
	2007/03/19
CONSULTANT DRAWING NO.	WB-B0301

THE CITY OF WINNIPEG
WATER AND WASTE DEPARTMENT
ENGINEERING DIVISION

WATER TREATMENT PLANT
MAIN BUILDING
BUILDING ENVELOPE

ARCHITECTURAL
EXTERIOR ELEVATIONS

CITY FILE NUMBER

SHEET OF

CITY DRAWING NUMBER
1-0601B-A-B0301-001-00D