


SITE PLAN
SCALE: 1" = 100'

CONTRACT BENCH MARKS - NOT GEODETIC
 BM₁ - AT S.E. CORNER OF MAIN BLDG. ELEV. 34.60'
 BM₂ - AT NORTH CENTRAL TANGENT POINT OF PRIMARY CLARIFIER TANK No. 3 ELEV. 32.10'

LEGEND

- WORK AREA
- ▨ RESTRICTED ROADS

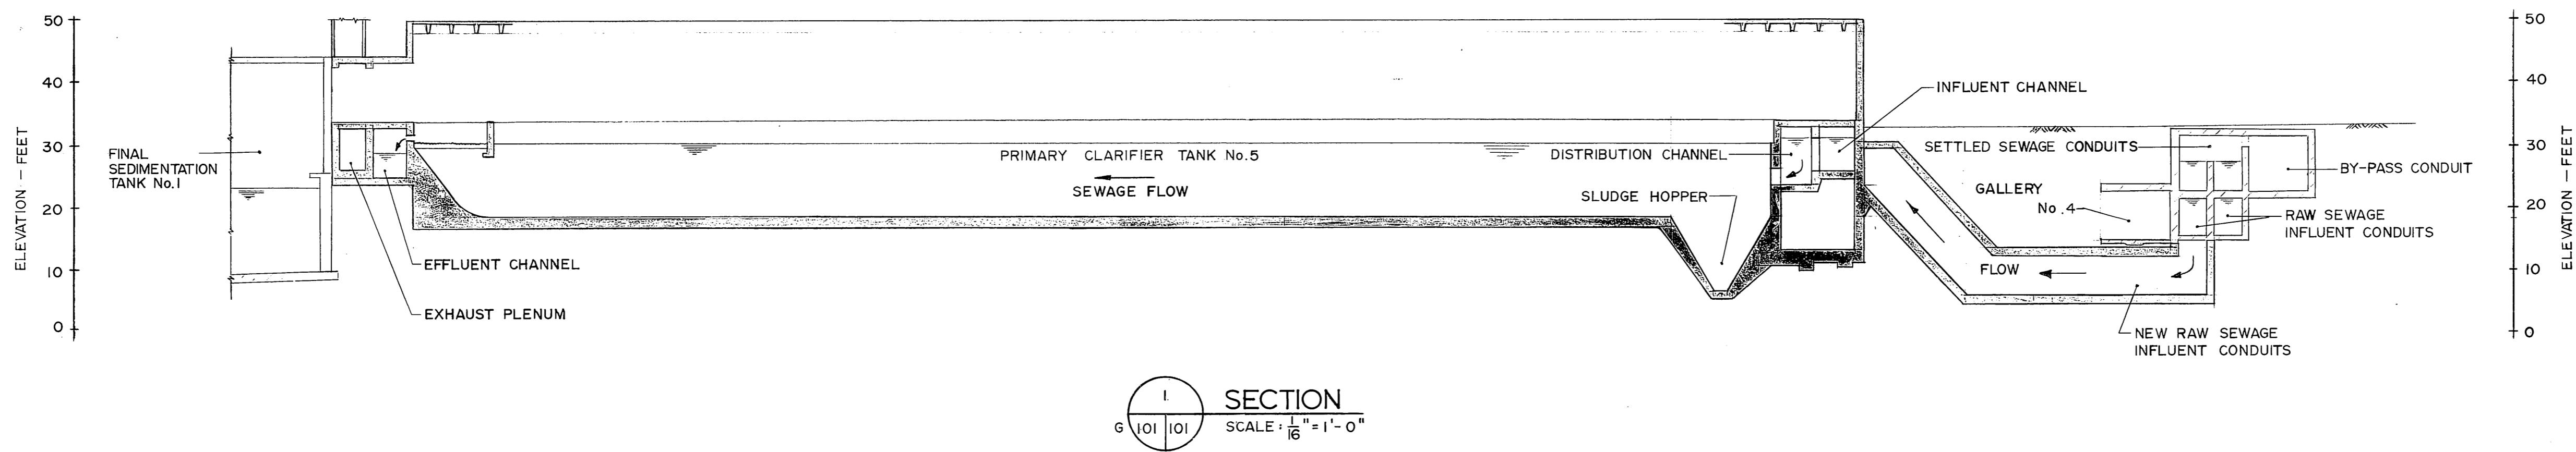

SECTION
SCALE: 1/16" = 1'-0"

		W. L. WARDROP & ASSOCIATES LTD. JAMES F. MACLAREN LIMITED ENGINEERING CONSULTANTS		THE CITY OF WINNIPEG WORKS & OPERATIONS DEPARTMENT WATERWORKS, WASTE & DISPOSAL DIVISION		SCALE: AS SHOWN
AS BUILT <i>CSA</i> ISSUED FOR TENDER		DRAWN BY: <i>Gm</i> CHECKED BY: <i>R. MacLaren</i> DATE: 15/5/78	DESIGNED BY: <i>Gm</i> APPROVED BY: <i>R. MacLaren</i> DATE:	NORTH END WATER POLLUTION CONTROL CENTRE PRIMARY CLARIFIER ADDITION		DATE: MAY 1978
CONSULTANT DRAWING NO. 76012-05-G101 CITY DRAWING NO. NEP-918		MICROFILMED MAR 31 1980		SITE PLAN		CONSULTANT DRAWING NO. 76012-05-G101 CITY DRAWING NO. NEP-918