


NOTE: PILES LOCATED ON THIS PILE ARE TO BE BATTERED 10% TO THE NORTH.
14 725

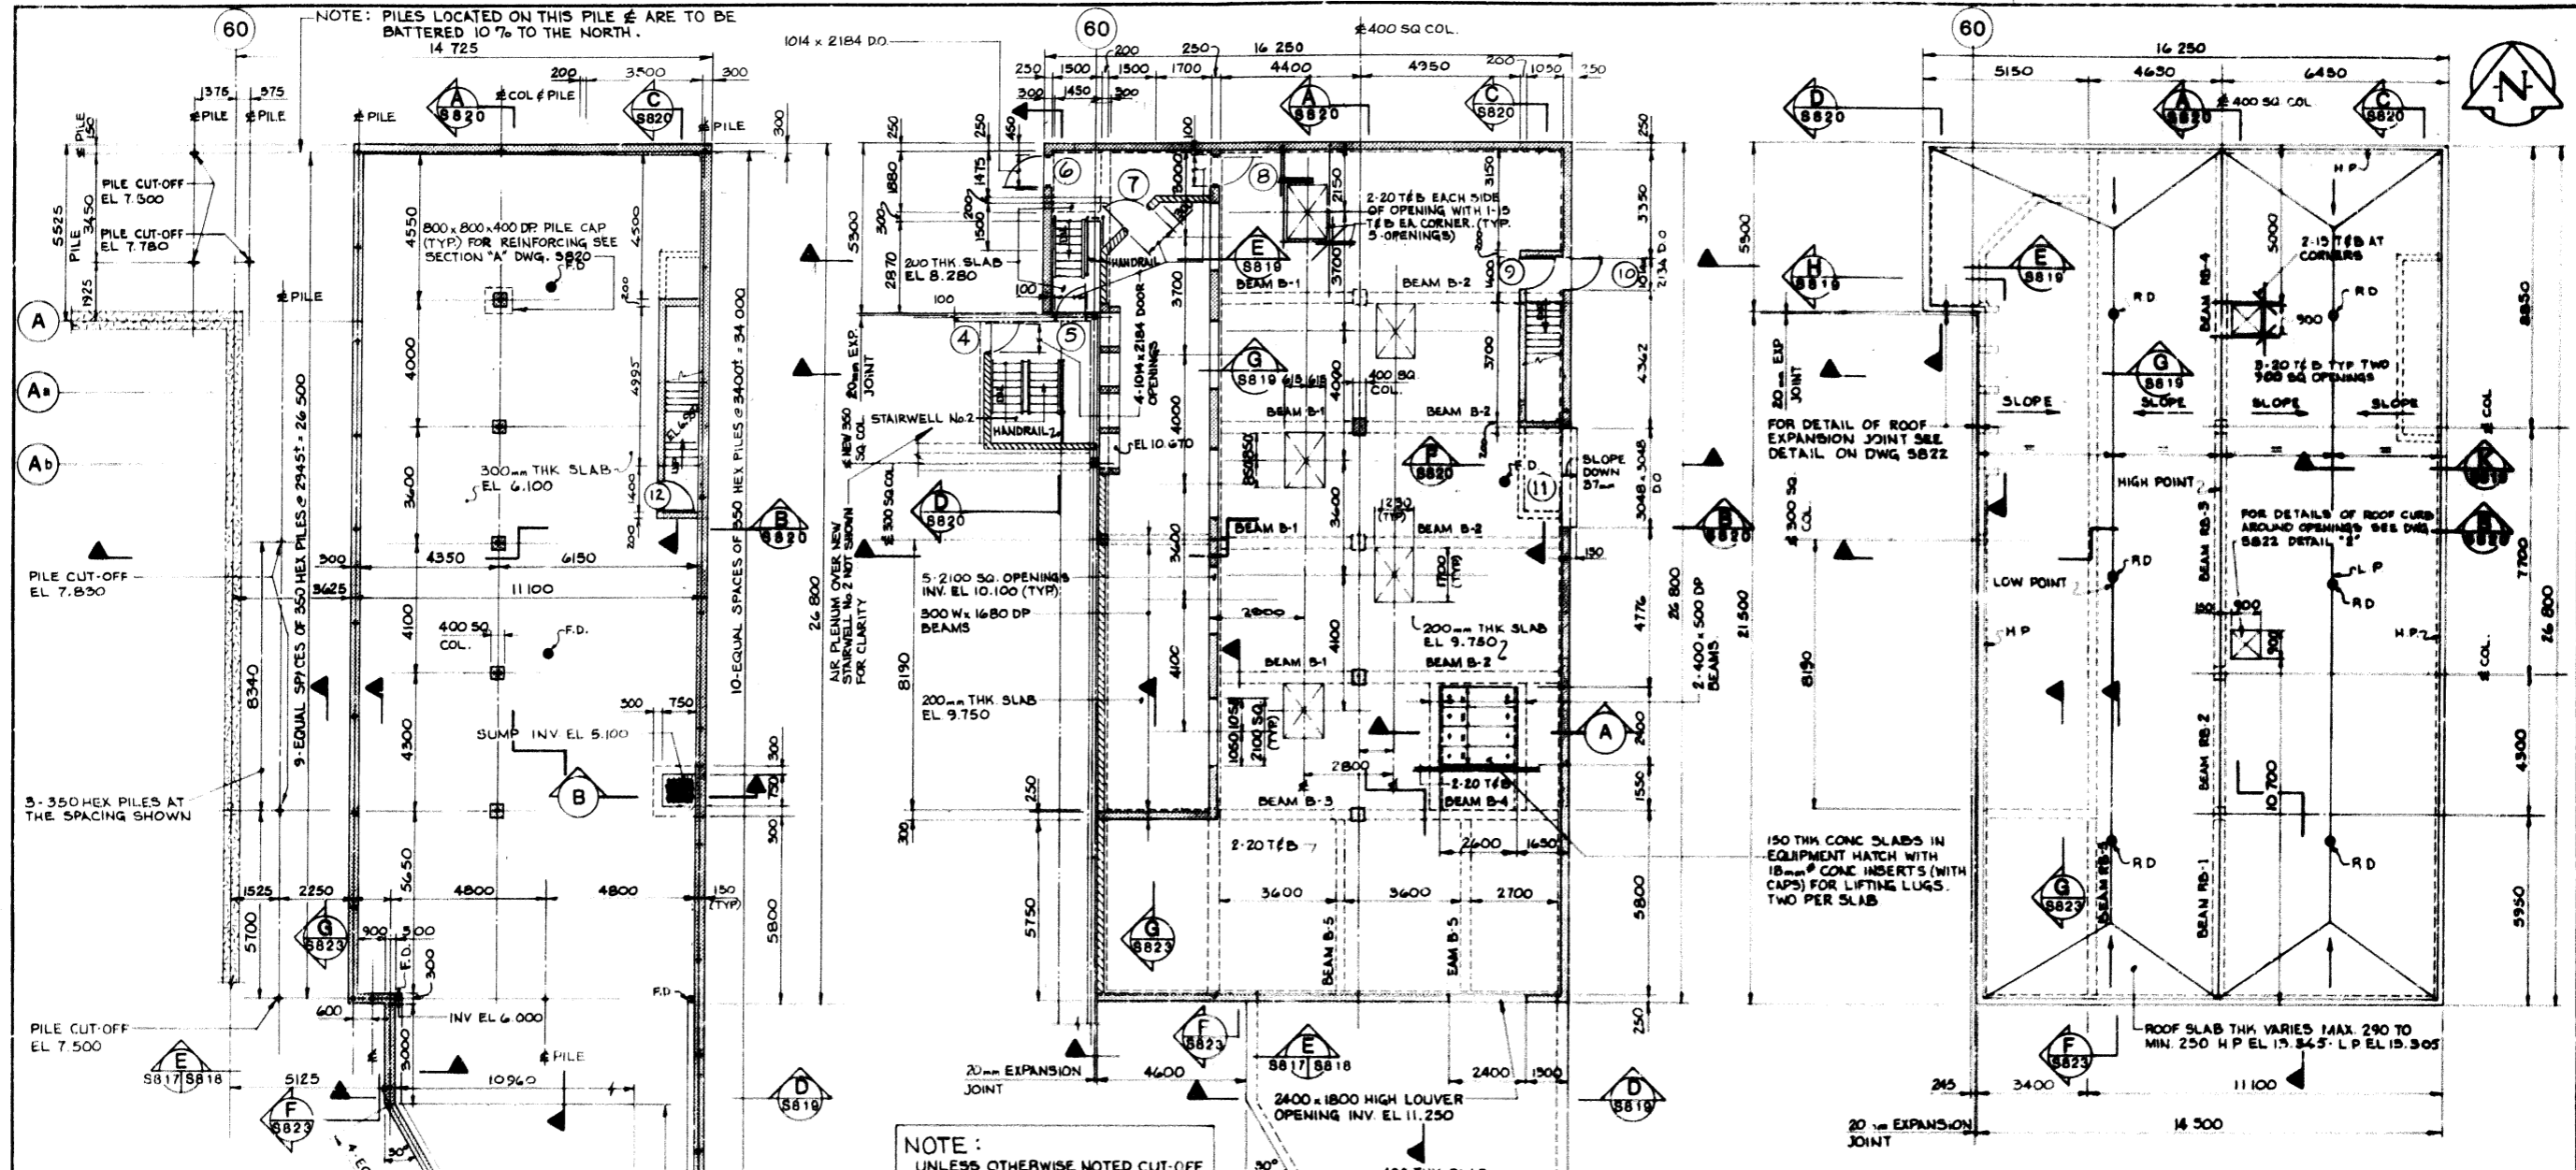


NOTE: UNLESS OTHERWISE NOTED CUT-OFF ELEVATION FOR TOP OF PILES ARE EL. 5.500

NOTE: SEE DWG SB23 FOR DETAILS OF BEAMS INDICATED ON THIS DWG.


ROOF PLAN
SCALE 1:100

PLAN ABOVE EL. 6.100
SCALE 1:100


PLAN ABOVE EL. 8.280
SCALE 1:100

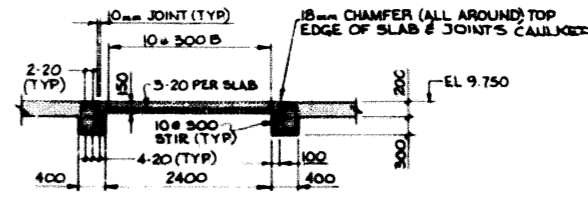

SECTION A
SCALE 1:50

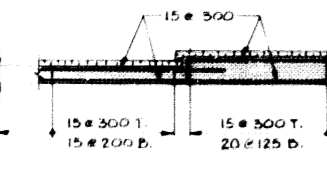

SECTION C
SCALE

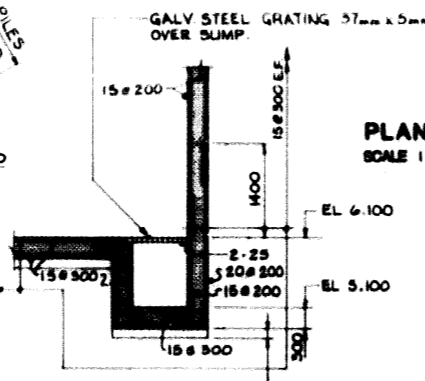

SECTION B
SCALE 1:50

AS - BUILT	
DATE	PERMITTED
MAY 88	

METRIC
WHOLE NUMBERS INDICATE MILLIMETRES
DECIMALISED NUMBERS INDICATE METRES

FOR CONTINUATION SEE DWG SB17 & SB19	
2 AS CONSTRUCTED	DATE
1 ISSUED FOR TENDER	DATE
0 ISSUED FOR CLIENT REVIEW	DATE
NO. REVISIONS	DATE



W.L. WARDROP & ASSOCIATES LTD.
MacLAREN ENGINEERS INC.
DESIGNED BY: A.L.
DRAWN BY: J.P.S.
CHECKED BY: A.L.
DATE: SEPT 1988



THE CITY OF WINNIPEG
WORKS & OPERATIONS DIVISION
WATERWORKS, WASTE & DISPOSAL DEPARTMENT
NORTH END WATER POLLUTION CONTROL CENTRE
SECONDARY TREATMENT EXPANSION
SECONDARY CLARIFIERS - STRUCTURAL FAN HOUSE -
PLANS & SECTIONS
RELEASED FOR CONSTRUCTION DATE: 1988 09 12
SCALE: AS SHOWN
DRAWING NO: NEP 1394