


CRAWLSPACE POWER PLAN
1:20

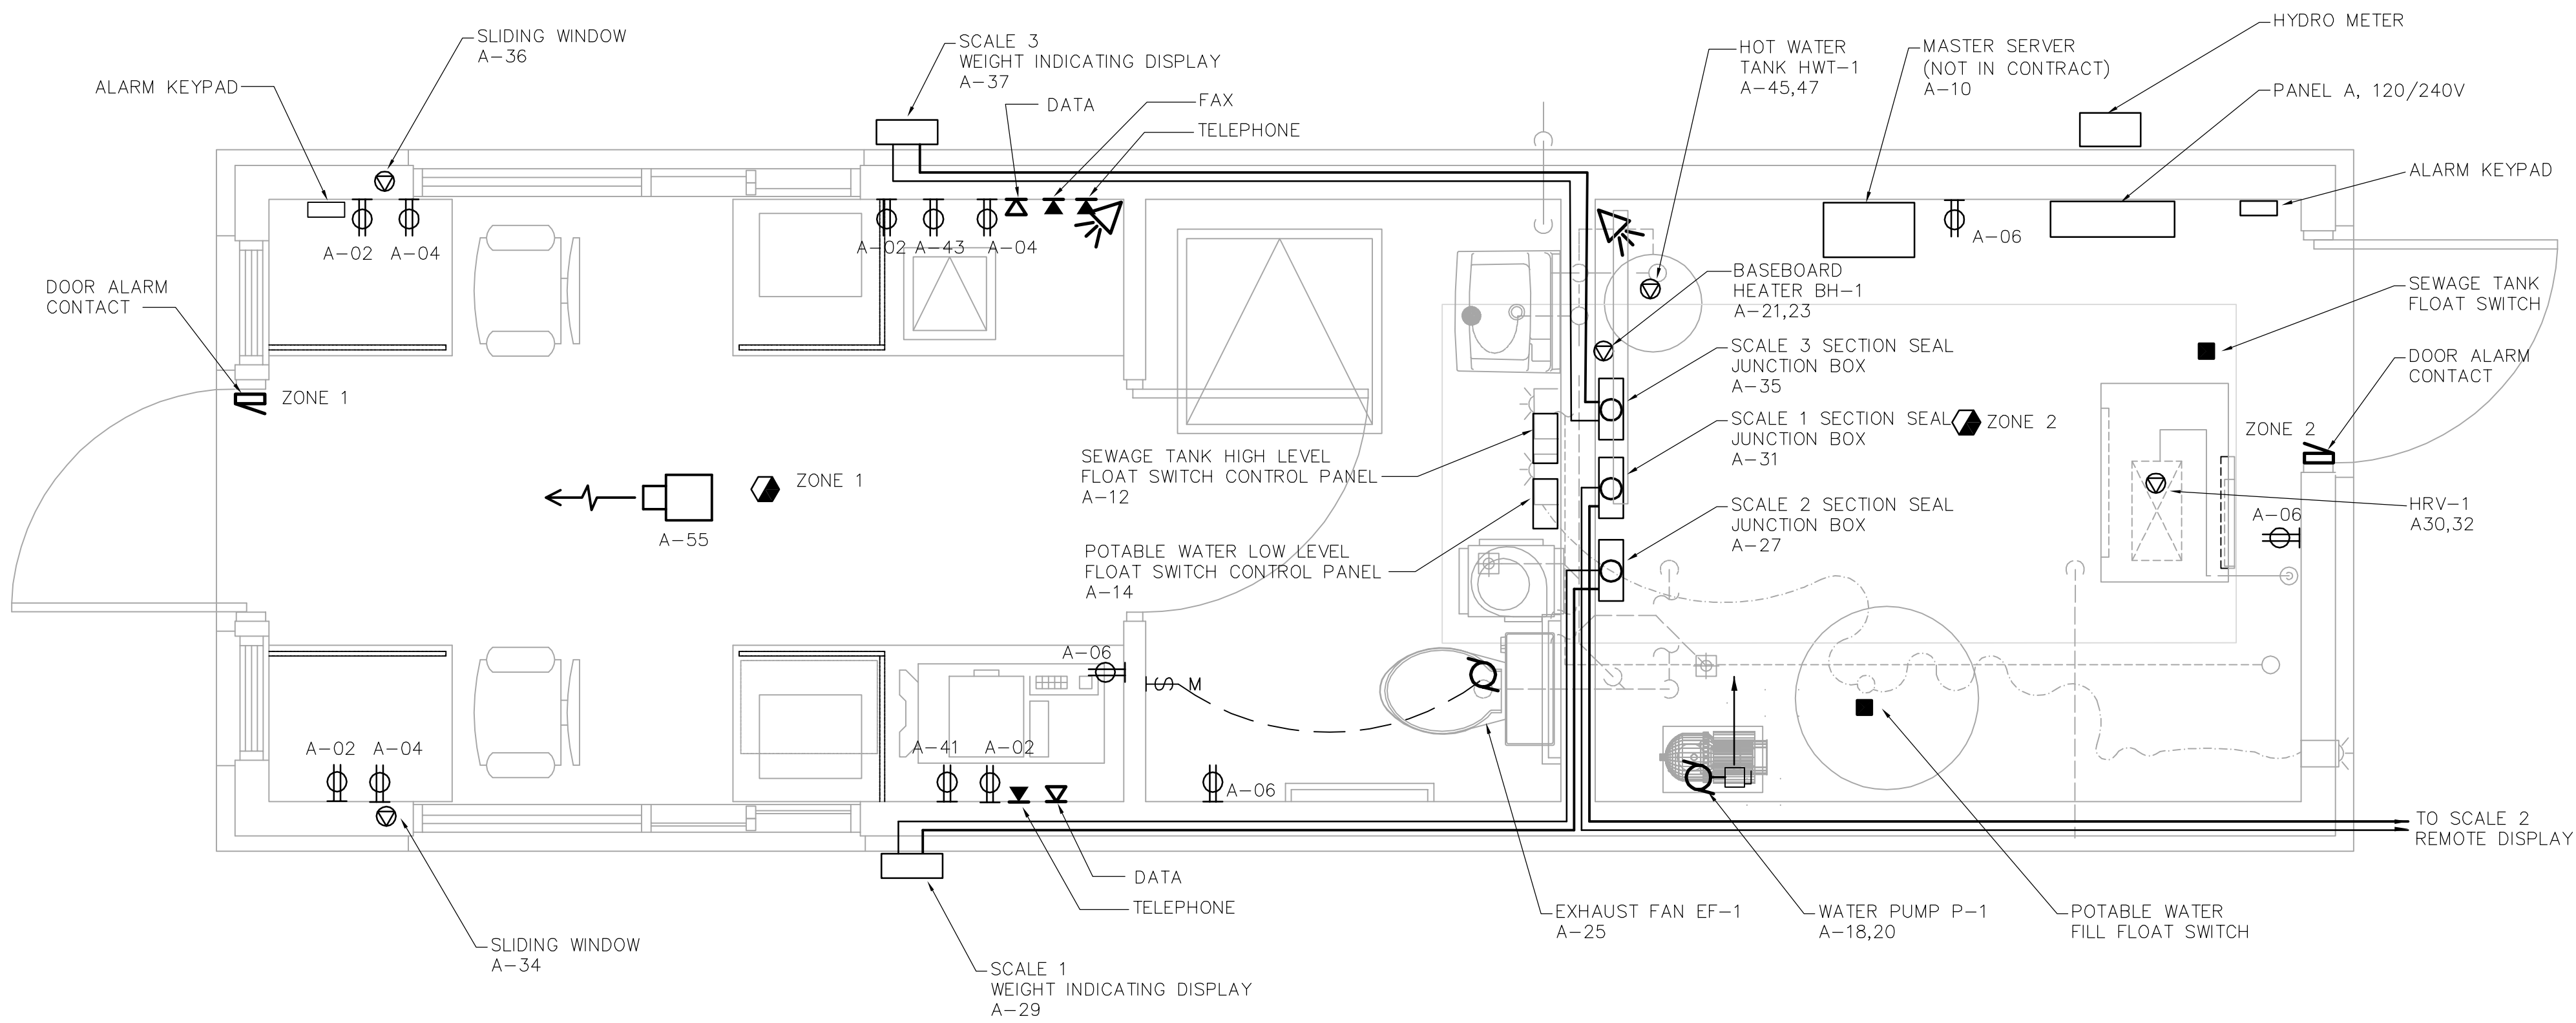

MAIN FLOOR POWER PLAN
1:20

 Certificate of Authorization Earth Tech Canada Inc. No. 730	B.M. ELEV.	 DESIGNED BY: ERC DRAWN BY: ERC SCALE: 1:20 ISSUED FOR TENDER: 07/07/20 NO. REVISIONS	 CHECKED BY: PS APPROVED BY: TGS RELEASED FOR CONSTRUCTION BY: V. JEANCART DATE: 2006/08/31	ENGINEER'S SEAL ORIGINAL SIGNED BY: P. STRYK DATE: 2007/07/20 CONSULTANT DRAWING NO. E1.04	 THE CITY OF WINNIPEG WATER AND WASTE DEPARTMENT SOLID WASTE SERVICES DIVISION BRADY RD. LANDFILL NEW ENTRANCE AND SCALE FACILITY ELECTRICAL CRAWLSPACE AND MAIN FLOOR POWER PLAN CITY FILE NUMBER SHEET OF CITY DRAWING NUMBER SWD-D-391