
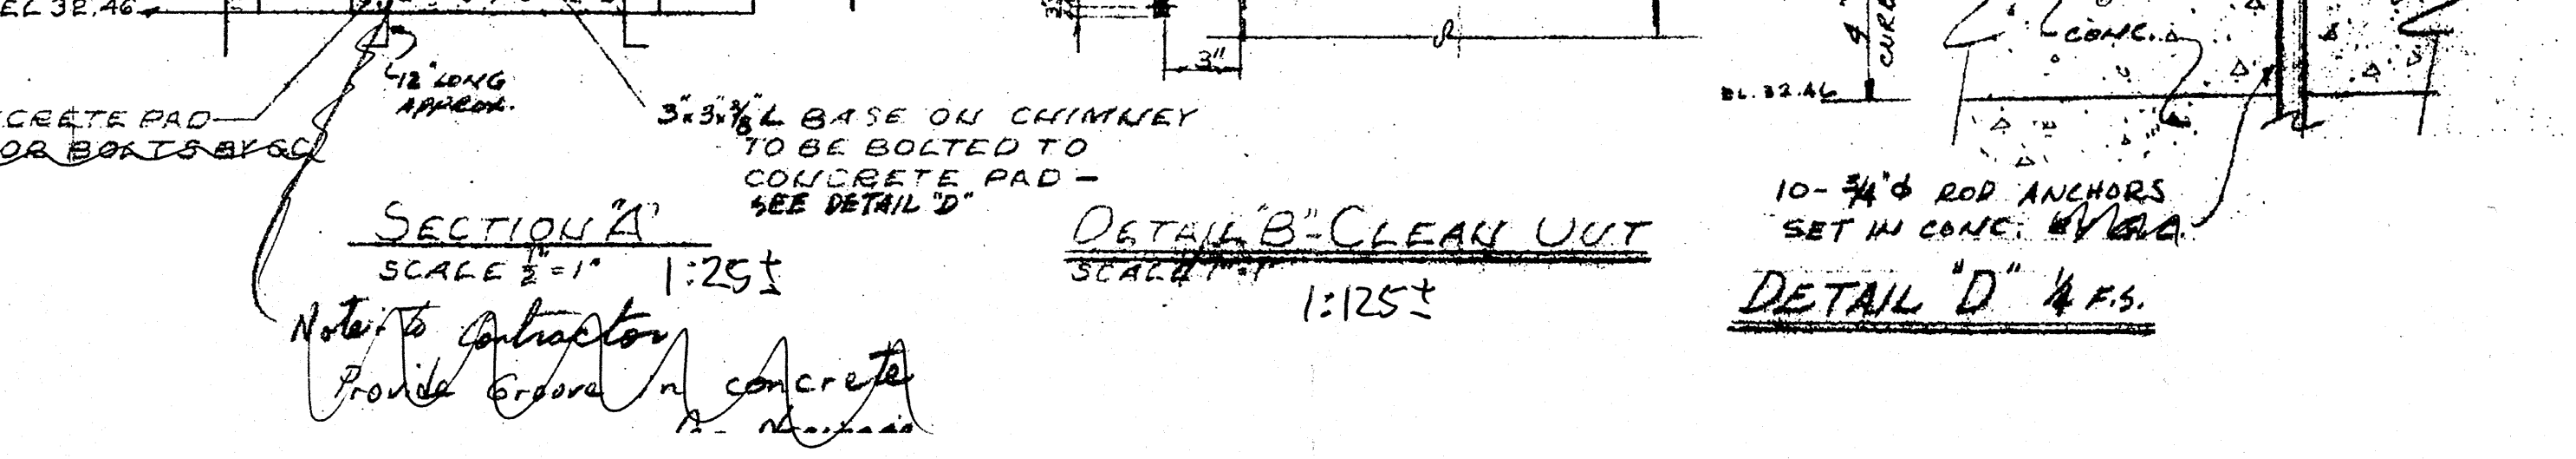
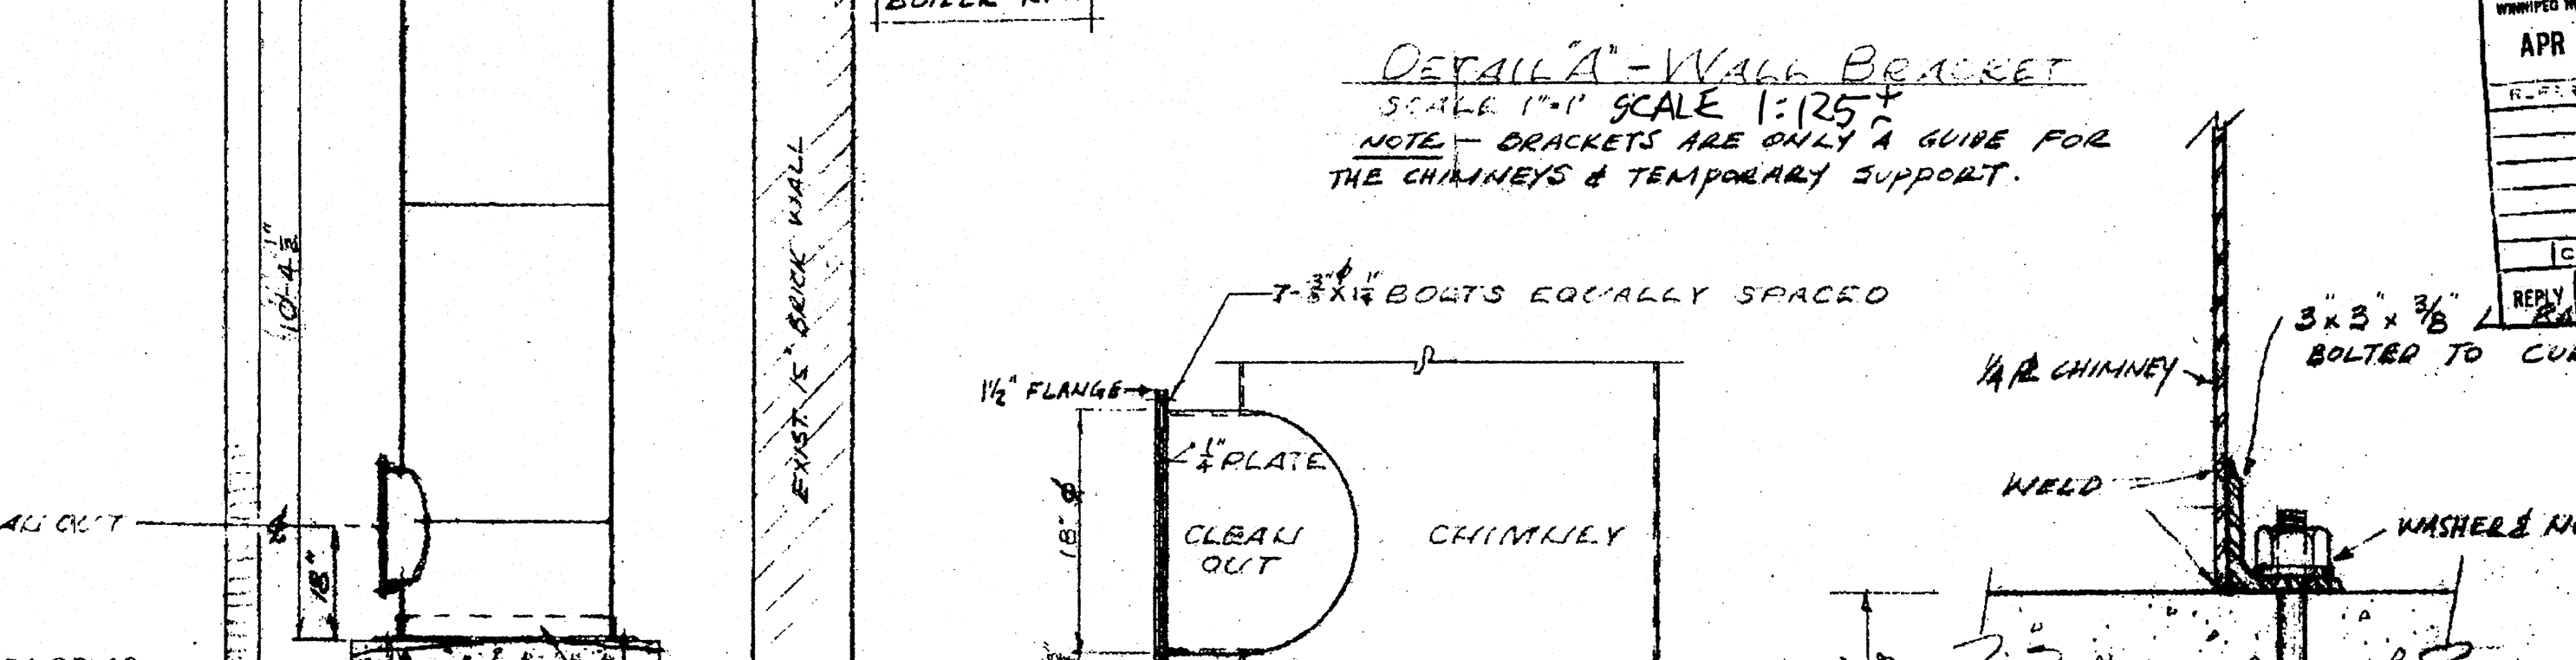
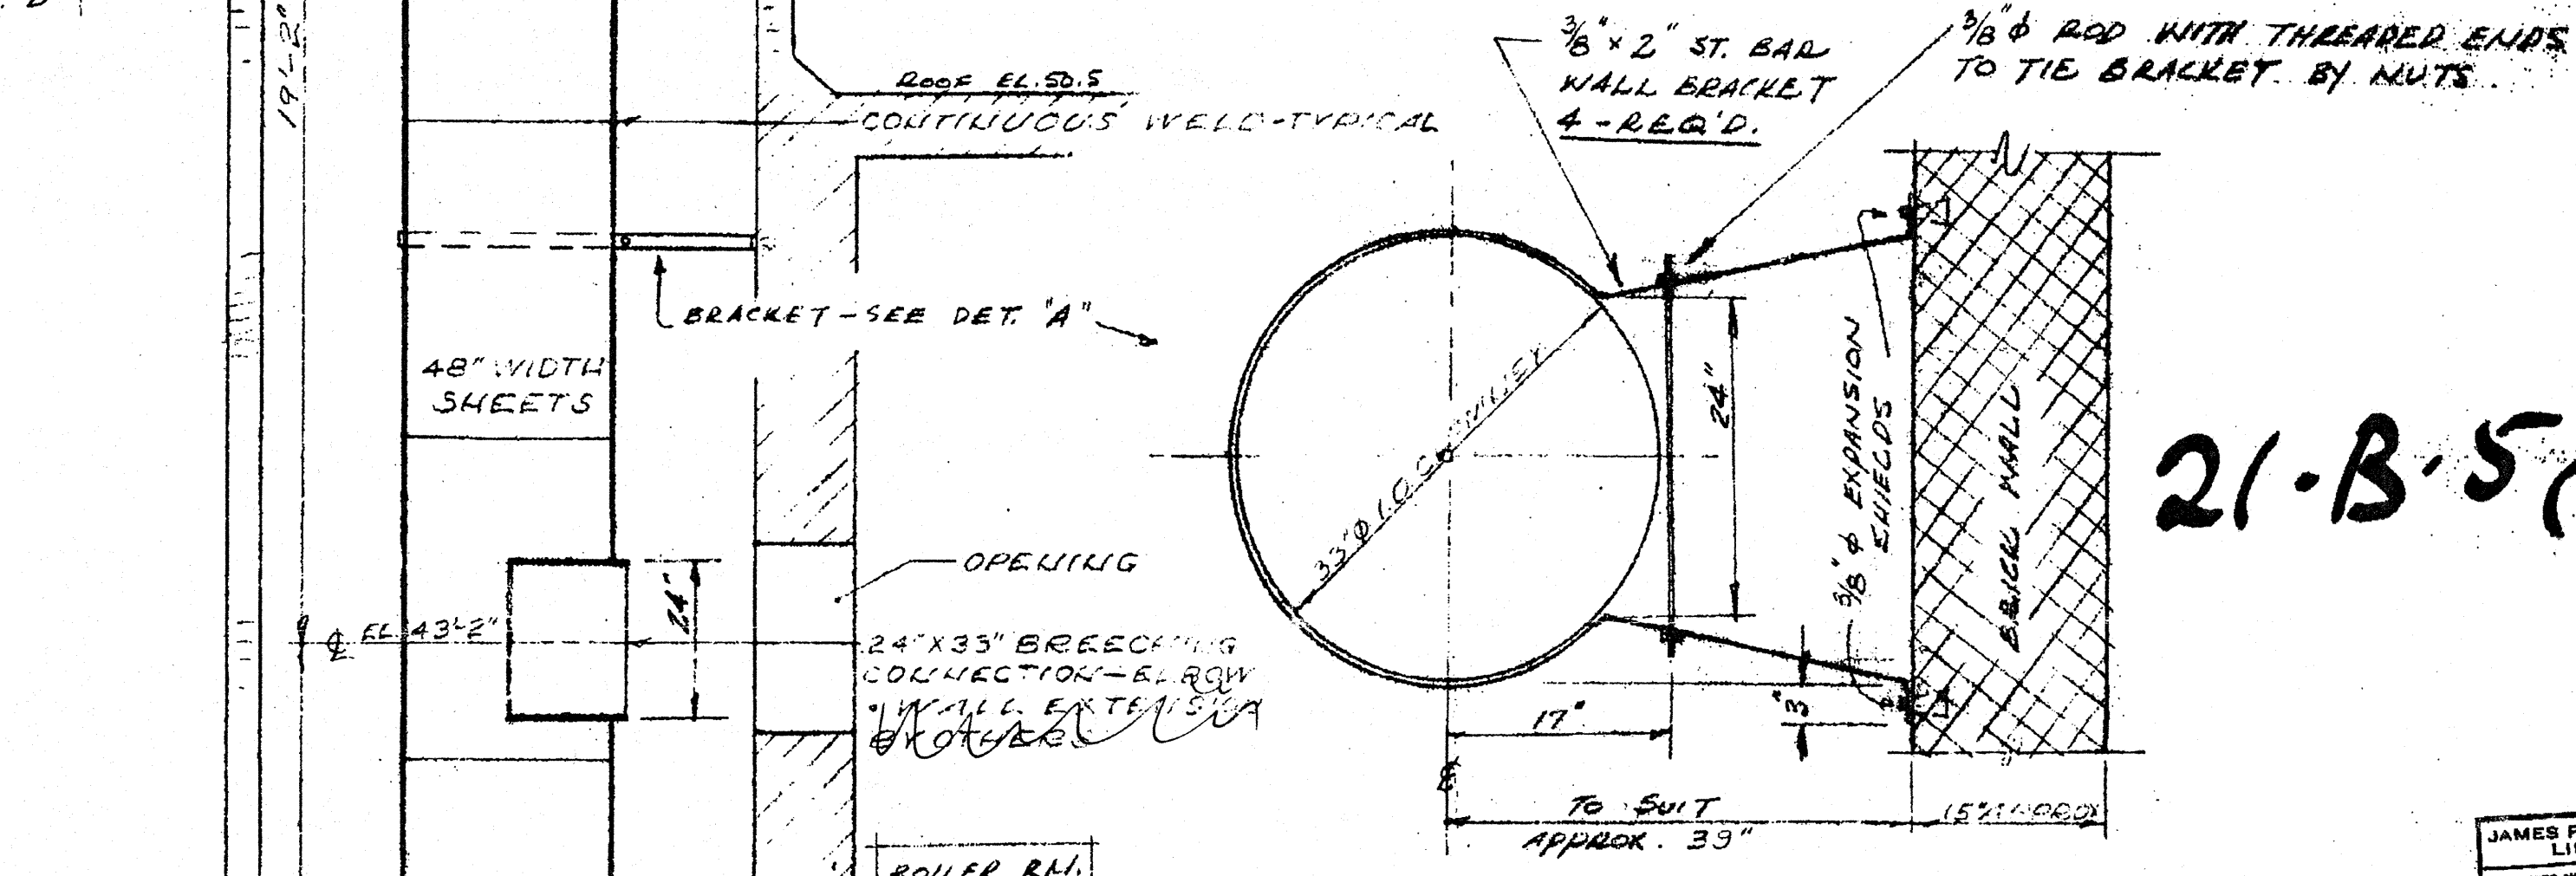
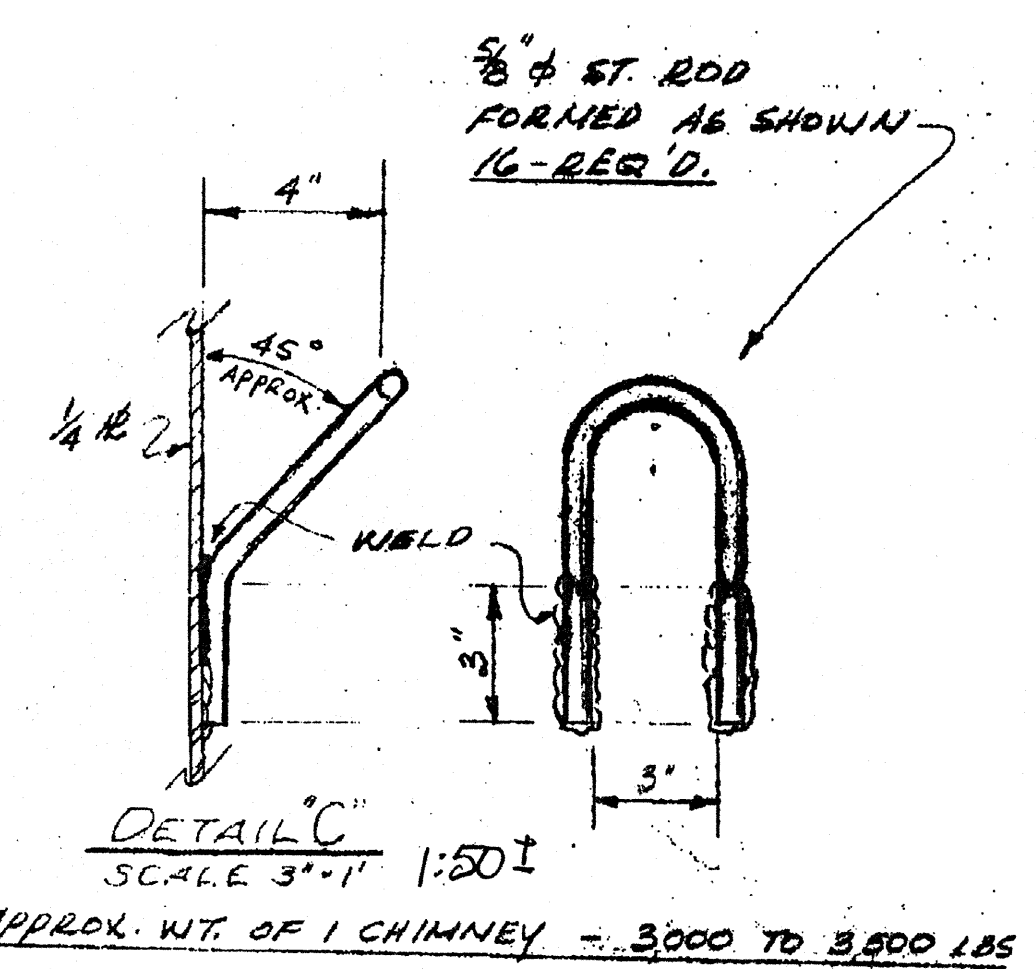


**FRONT ELEVATION**  
SCALE 1/4"=1' 1:50±

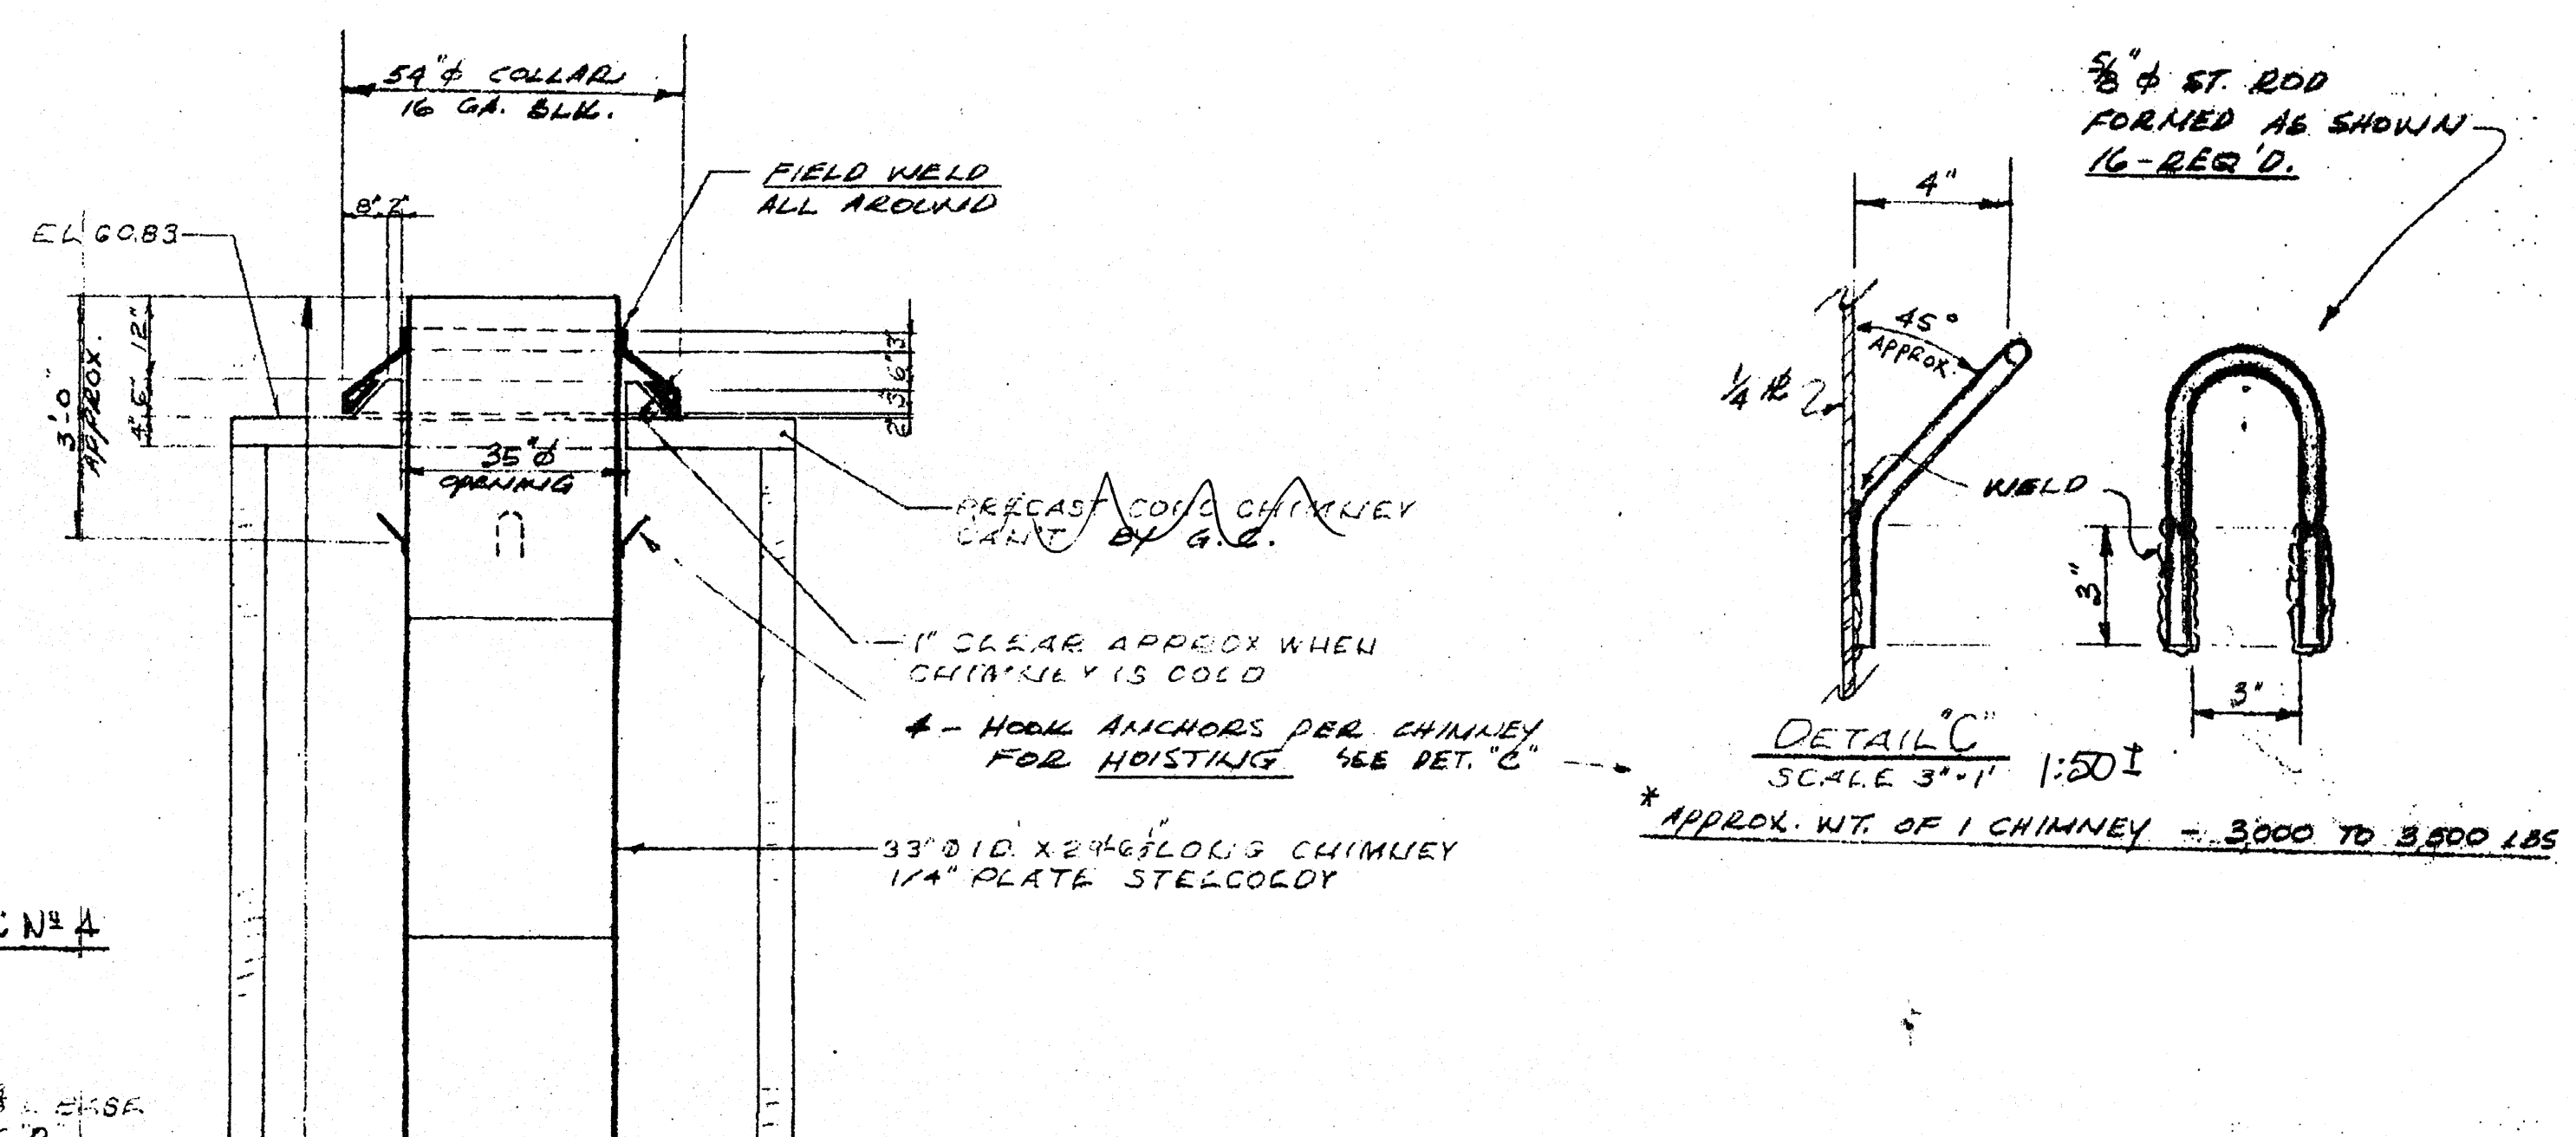

Notes to Contractor  
Provide concrete pad

21-B-5

JAMES F. MAX LIMITED
APR 6
REPLY DATE
DATE
BY

B.M. ELEV.	FIELD BOOK #	CITY OF WINNIPEG WATER AND WASTE ENGINEERING DIVISION		ENGINEER'S SEAL
POSTED TO LBS		DESIGNED BY	CHECKED BY	<b>THE CITY OF WINNIPEG</b> WATER AND WASTE DEPARTMENT NORTH END WATER POLLUTION CONTROL CENTER 4 CHIMNEYS FOR NORTHEAST STP - A
		DRAWN BY WKT	APPROVED BY	
		HOR. SCALE 1:50 AS SHOWN	RELEASED FOR CONSTRUCTION	
		VERTICAL SCALE 1:50 AS SHOWN	FILENAME: NEP_21-B-5.DWG	
NO. REVISIONS	DATE	DATE	DATE	TENDER No. 2004-???
		2006 11 30		PLOT DATE: 2006 11 30