


SINGLE LINE DIAGRAM

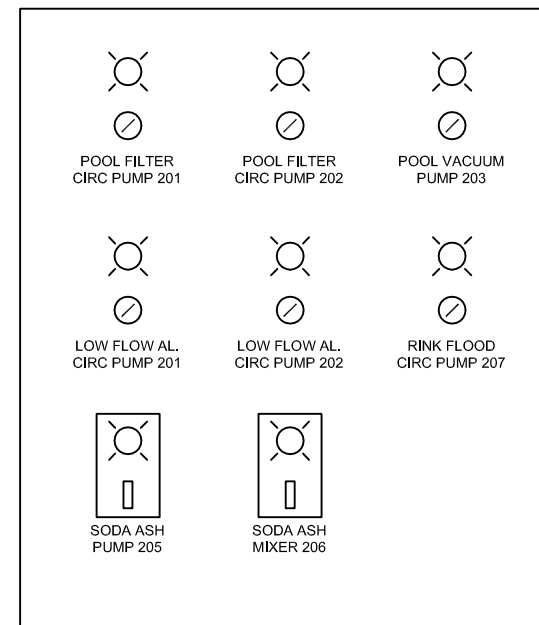

NEW CONTROL PANEL CP-101

0 07/06/07 ISSUED FOR TENDER & CONSTRUCTION
No. DATE ISSUANCE



A.J. Dunsmore Engineering
CONSULTING ELECTRICAL ENGINEER
221 Kerr Ave., Dauphin, MB
R7N 3J5

Client
**CITY OF WINNIPEG
BUILDING SERVICES**

Project
CINDY KLASSEN RECREATION COMPLEX
POOL BOILER INSTALLATION
BID OPPORTUNITY# 434-2007

Sheet Title
ELECTRICAL SCHEMATICS

SCALE : NTS
PROJECT NO: 2007-13 **E-2**