
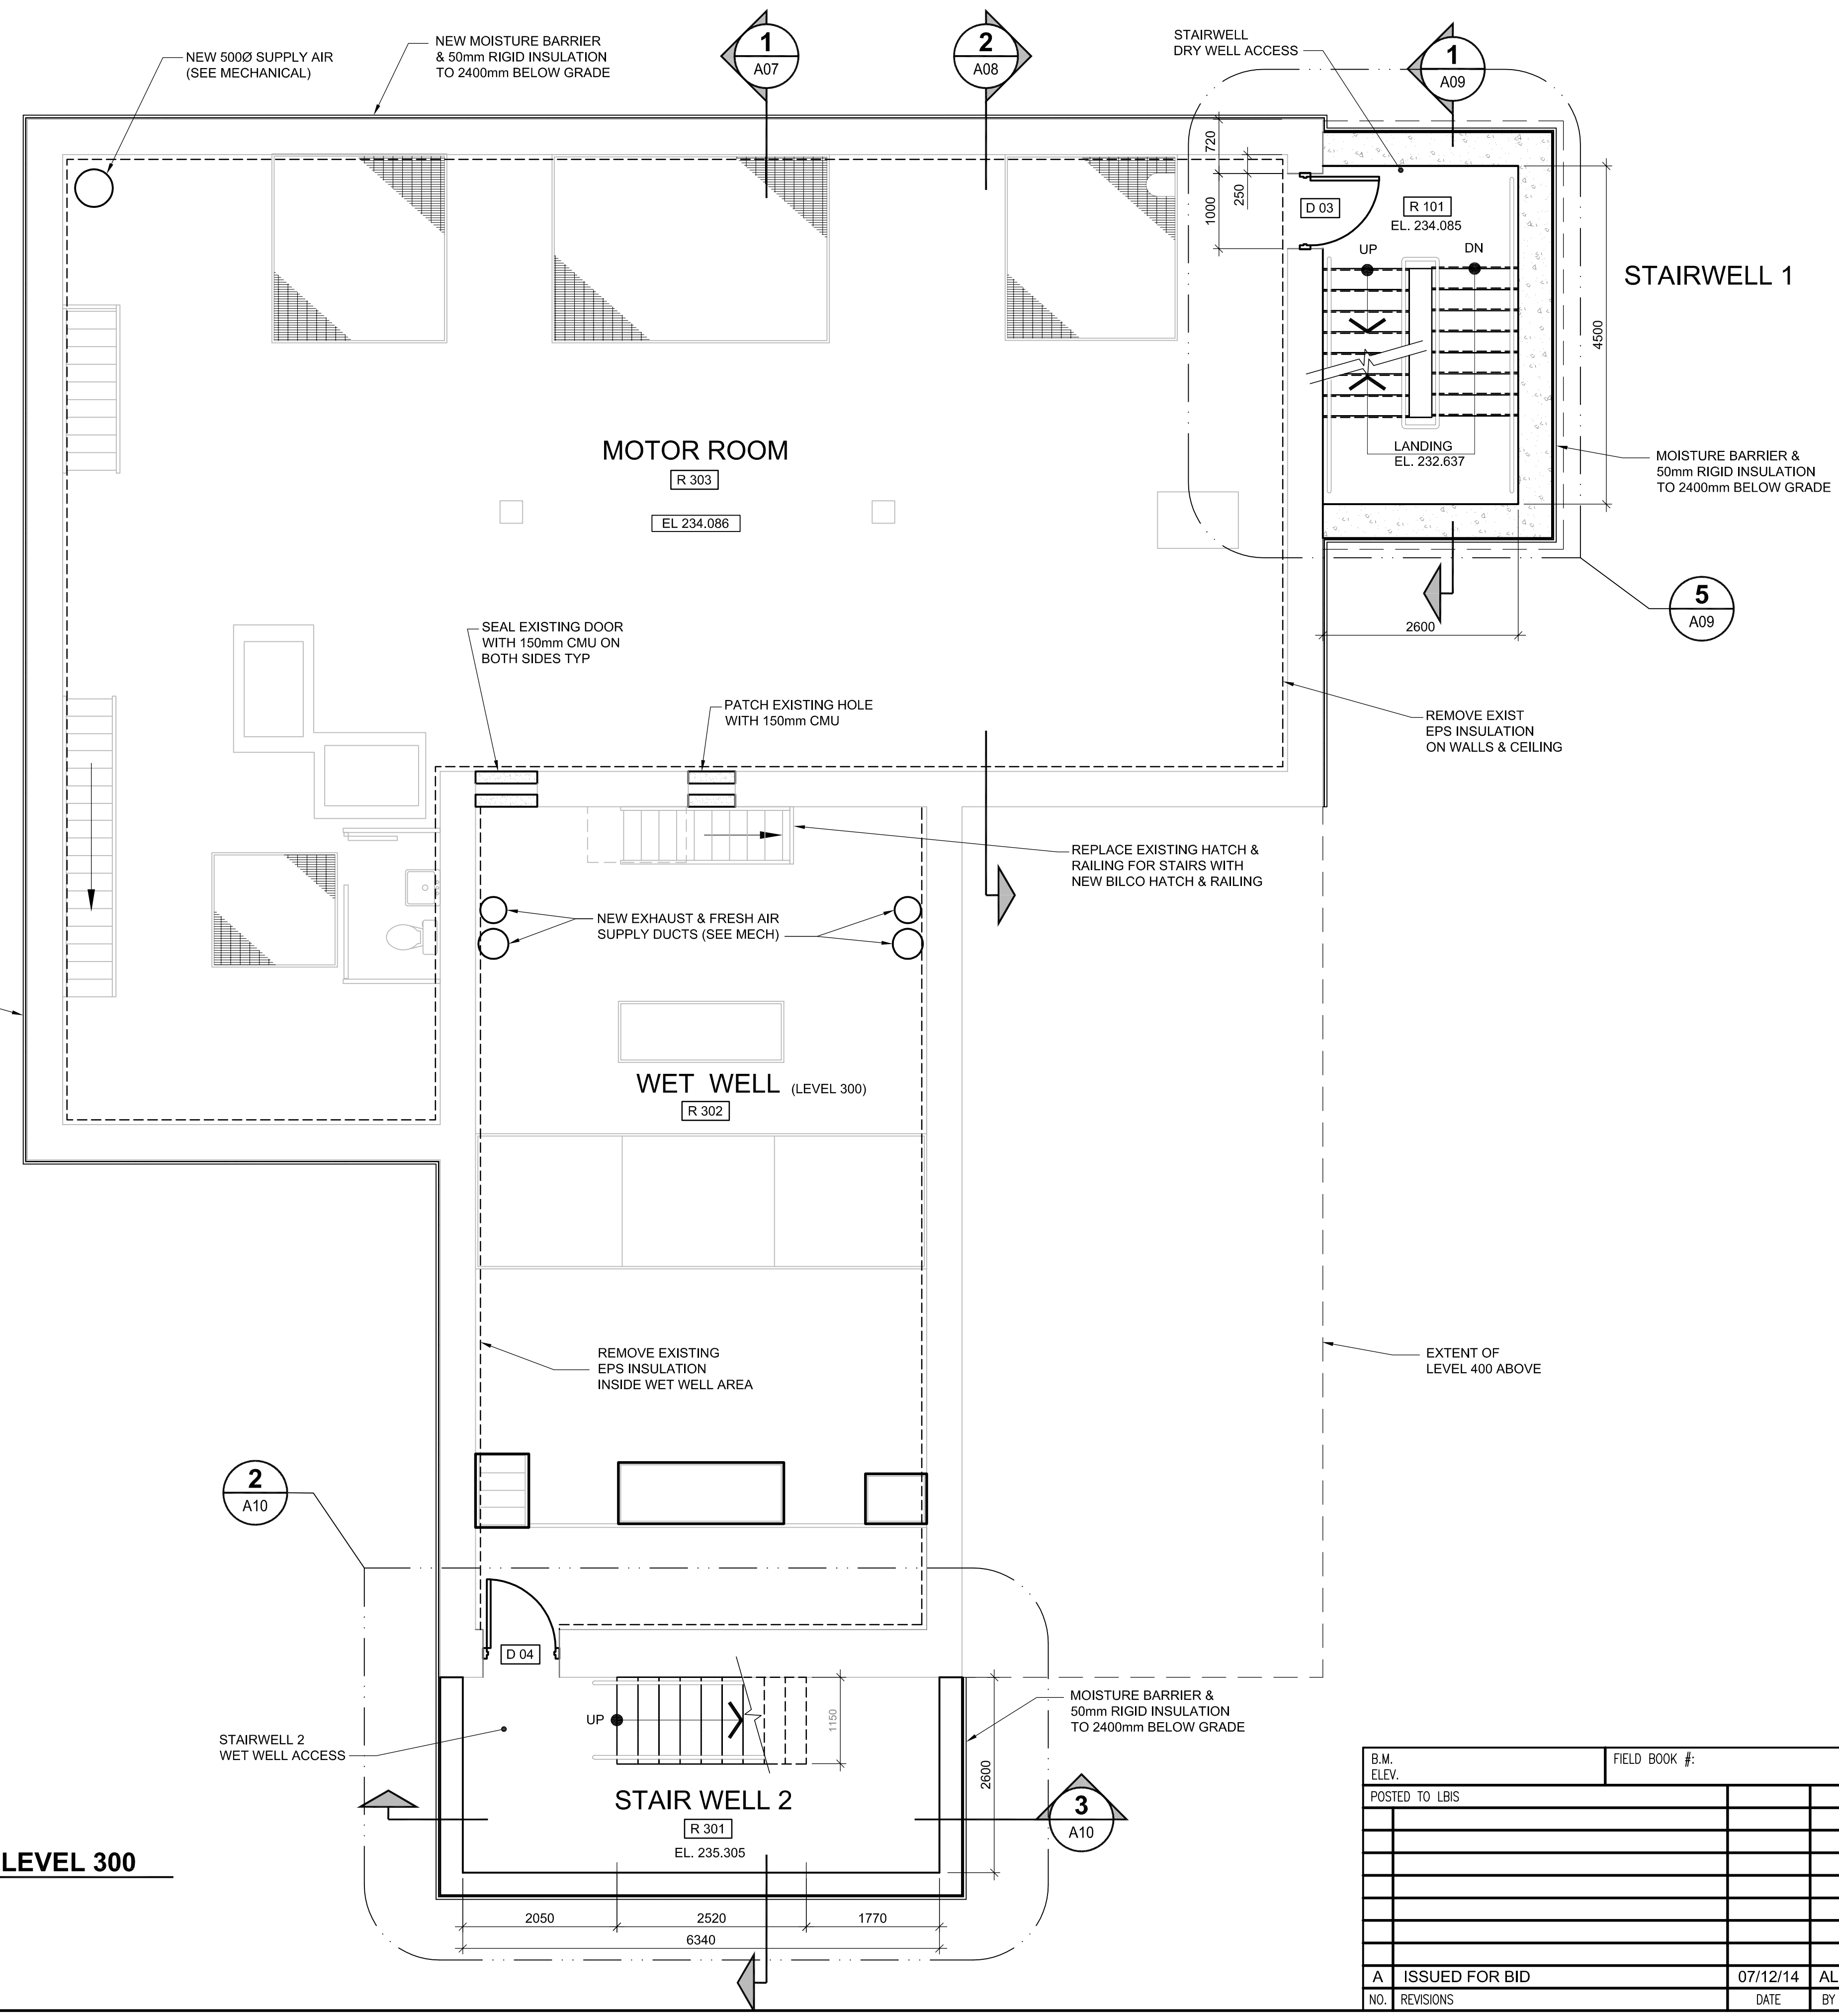


D SIZE 22" x 34" (559mm x 864mm)

PLOT: 12/18/2007 10:24:41 AM

NCA FILE NAME: AR\_L300.dwg Saved By: amercico

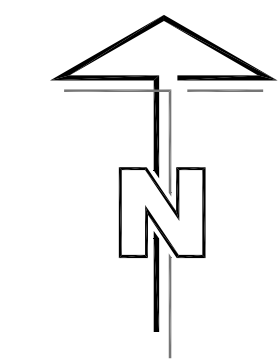


**1**  
A04

**PLAN LEVEL 300**  
SCALE: 1:50

B.M. ELEV.	FIELD BOOK #:	Neil Cooper Architect Inc. 10-395 Berry Street, Winnipeg, Manitoba R3J 1N6 Phone (204) 885-3855 Fax (204) 831-7148	
POSTED TO LBIS		DESIGNED BY <b>NC</b>	CHECKED BY -
		DRAWN BY <b>CGC/AL</b>	APPROVED BY -
		HOR. SCALE <b>AS NOTED</b>	RELEASED FOR CONSTRUCTION
		VERTICAL <b>AS NOTED</b>	
<b>A</b> ISSUED FOR BID	07/12/14	AL	DATE <b>07/06/14</b> DATE
NO. REVISIONS	DATE	BY	FILENAME: AR_L300.dwg

ENGINEER'S SEAL

REVISION - A  
ISSUED FOR BID  
WAS SEALED BY  
NEIL COOPER  
AND DATED  
DEC 14, 2007

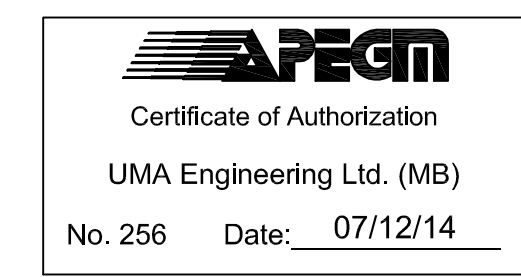

**Winnipeg** THE CITY OF WINNIPEG  
WATER AND WASTE DEPARTMENT

PERIMETER ROAD PUMPING STATION UPGRADES  
Contract B - Building Upgrades

Architectural - New Construction  
LEVEL 300 FLOOR PLAN

CITY DRAWING NUMBER **1-0111L-A0004** SHEET **001** REV. **A** SIZE **D**