
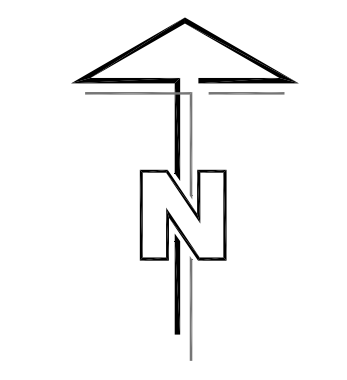


D SIZE 22" x 34" (559mm x 864mm)

PLOT: 12/18/2007 10:28:26 AM

NCA FILE NAME: AR ROOF LVL.dwg Saved By: americo.1

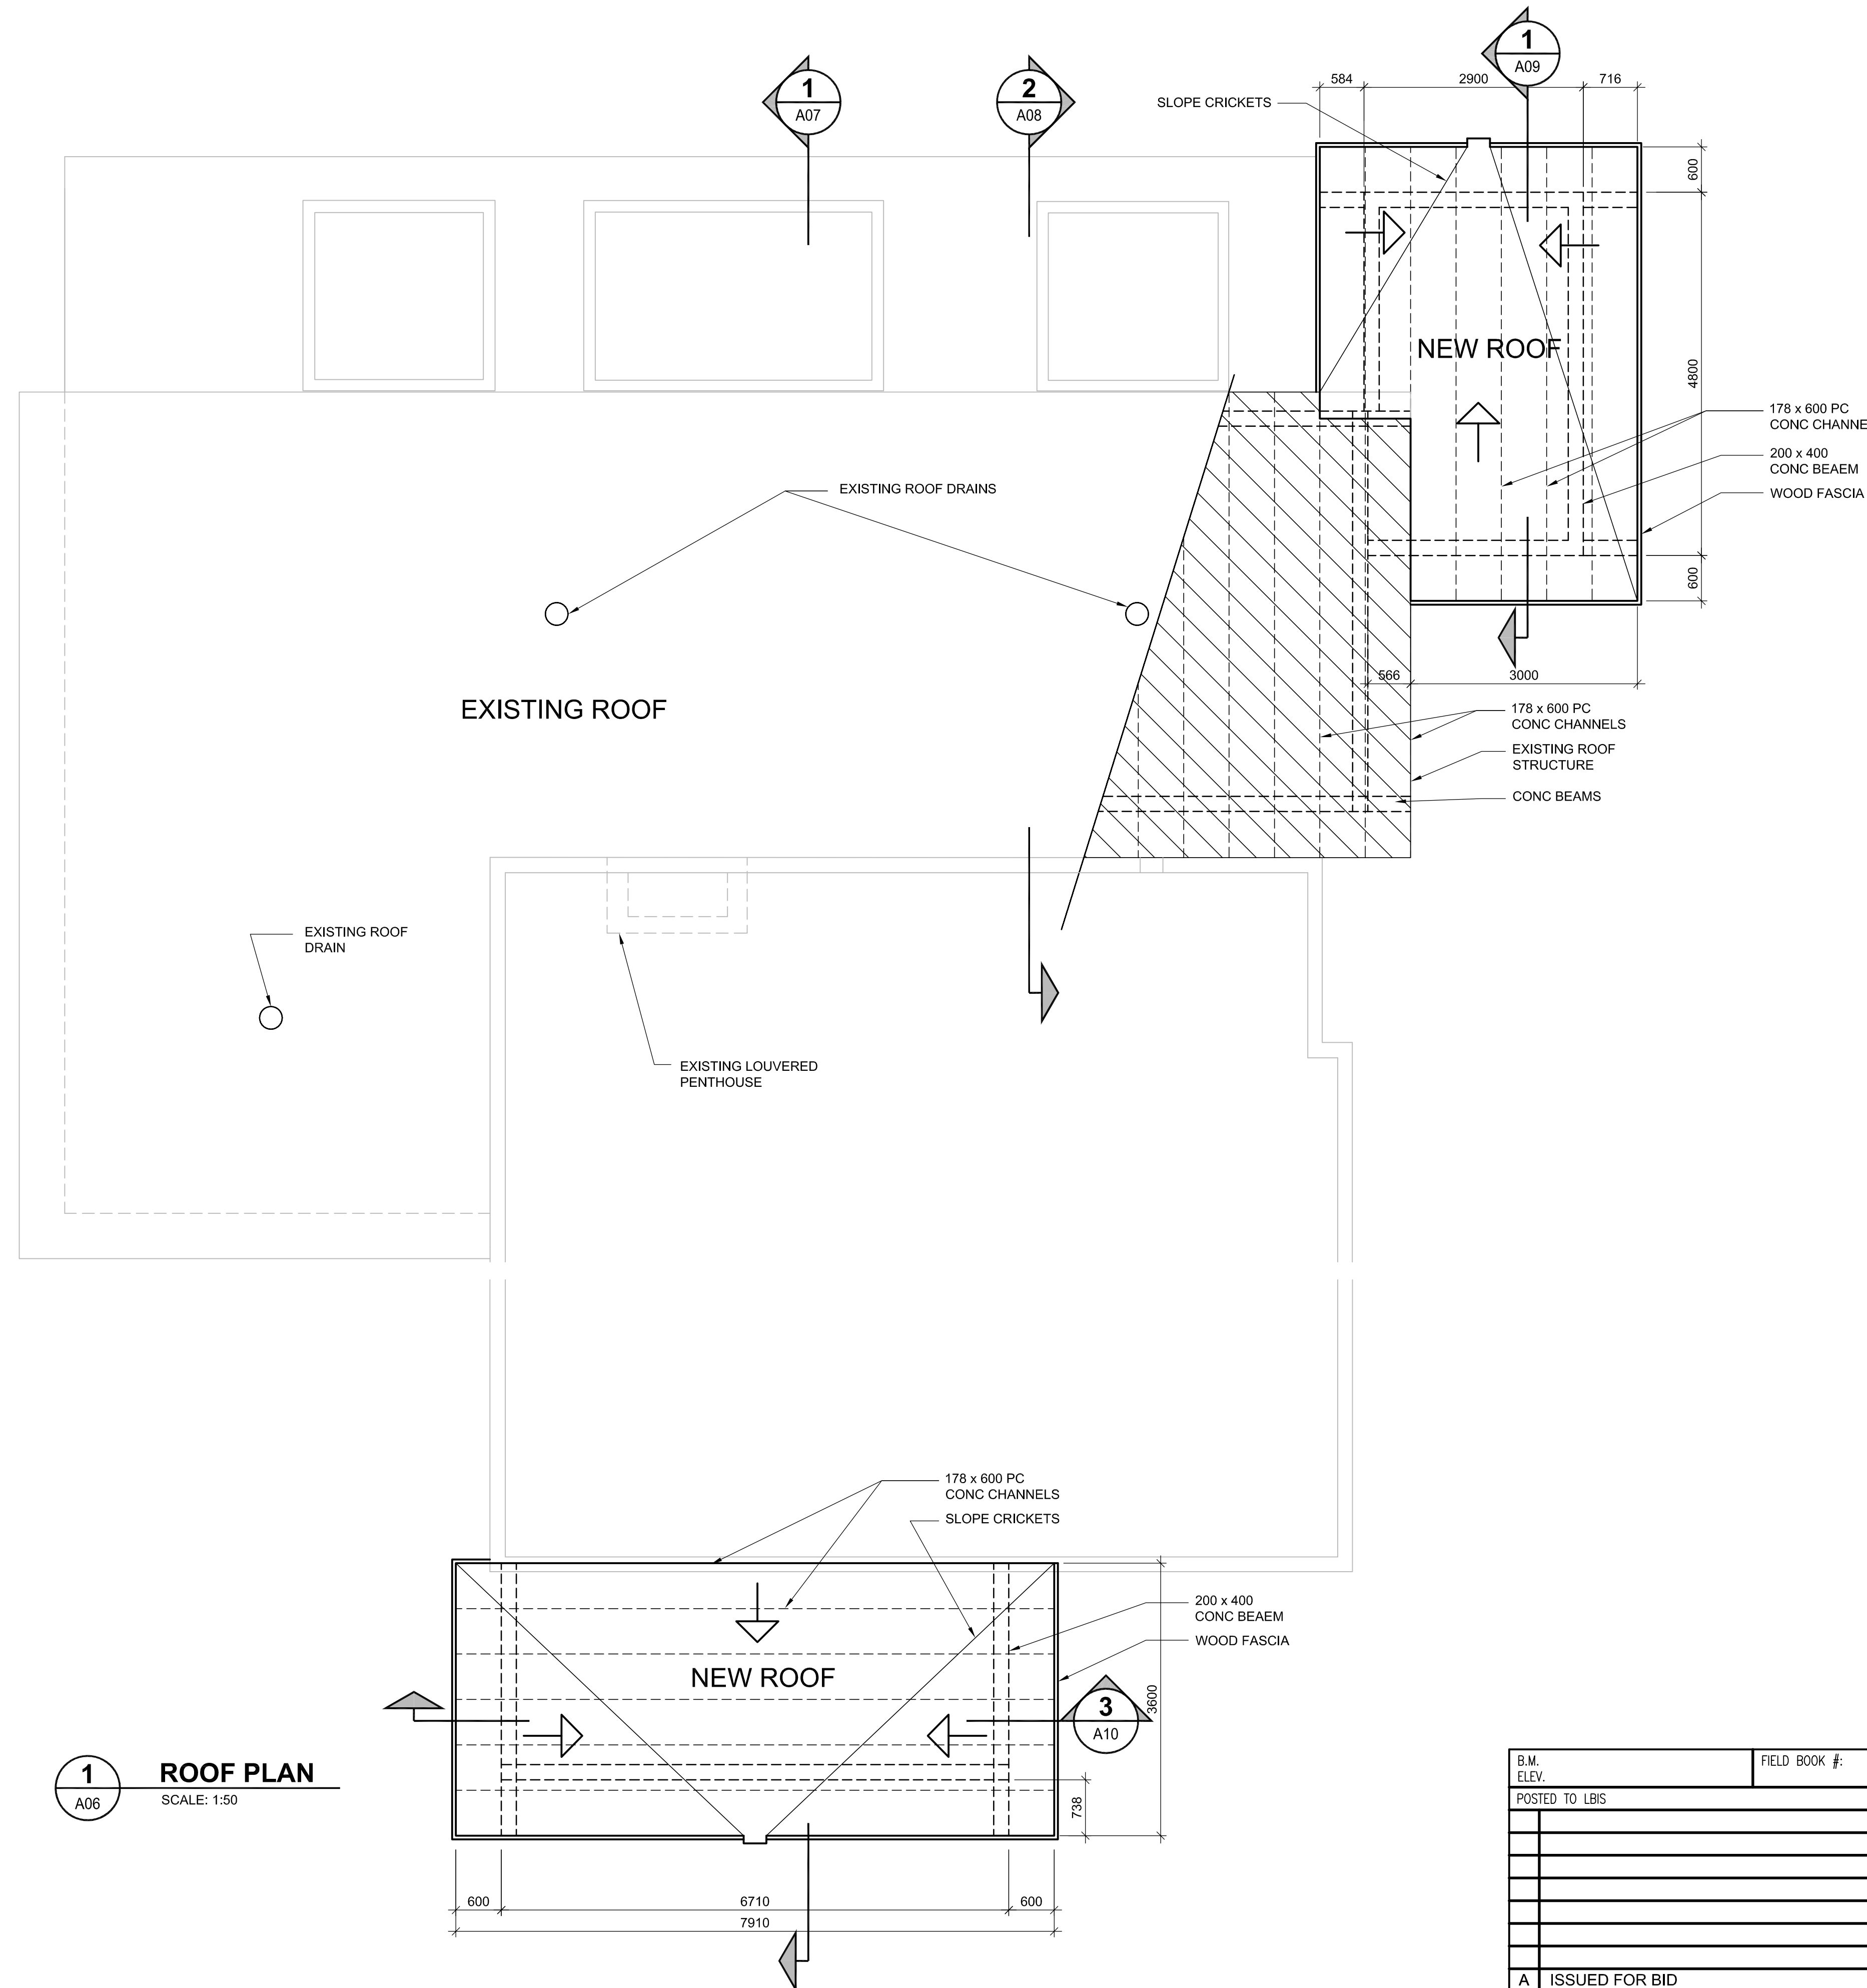

1
A06
ROOF PLAN
SCALE: 1:50

APECM
Certificate of Authorization
UMA Engineering Ltd. (MB)
No. 256 Date: 07/12/14

B.M. ELEV.	FIELD BOOK #:	Neil Cooper Architect Inc. 10-395 Berry Street, Winnipeg, Manitoba R3J 1N6 Phone (204) 885-3855 Fax (204) 831-7148	
POSTED TO LBIS		DESIGNED BY NC	CHECKED BY -
		DRAWN BY CGC/AL	APPROVED BY -
		HOR. SCALE AS NOTED	RELEASED FOR CONSTRUCTION
		VERTICAL AS NOTED	
A ISSUED FOR BID	07/12/14	AL	DATE 07/06/14 DATE
NO. REVISIONS	DATE	BY	FILENAME: AR ROOF LVL.dwg

ENGINEER'S SEAL
REVISION - A
ISSUED FOR BID
WAS SEALED BY
NEIL COOPER
AND DATED
DEC 14, 2007

Winnipeg THE CITY OF WINNIPEG
WATER AND WASTE DEPARTMENT

PERIMETER ROAD PUMPING STATION UPGRADES
Contract B - Building Upgrades

Architectural - New Construction
ROOF LEVEL PLAN

CITY DRAWING NUMBER	SHEET	REV.	SIZE
1-0111L-A0006	001	A	D