


2
A05 **BUILDING SECTION**
SCALE: 1:50

ABBREVIATION LIST

CMU	CONCRETE MASONRY UNITS
CONC	CONCRETE
GWG	GEORGIAN WIRE GLASS
HM	HOLLOW METAL
RH	RIGHT HAND
RHR	RIGHT HAND REVERSE
LH	LEFT HAND
LHR	LEFT HAND REVERSE
PT	PAINT

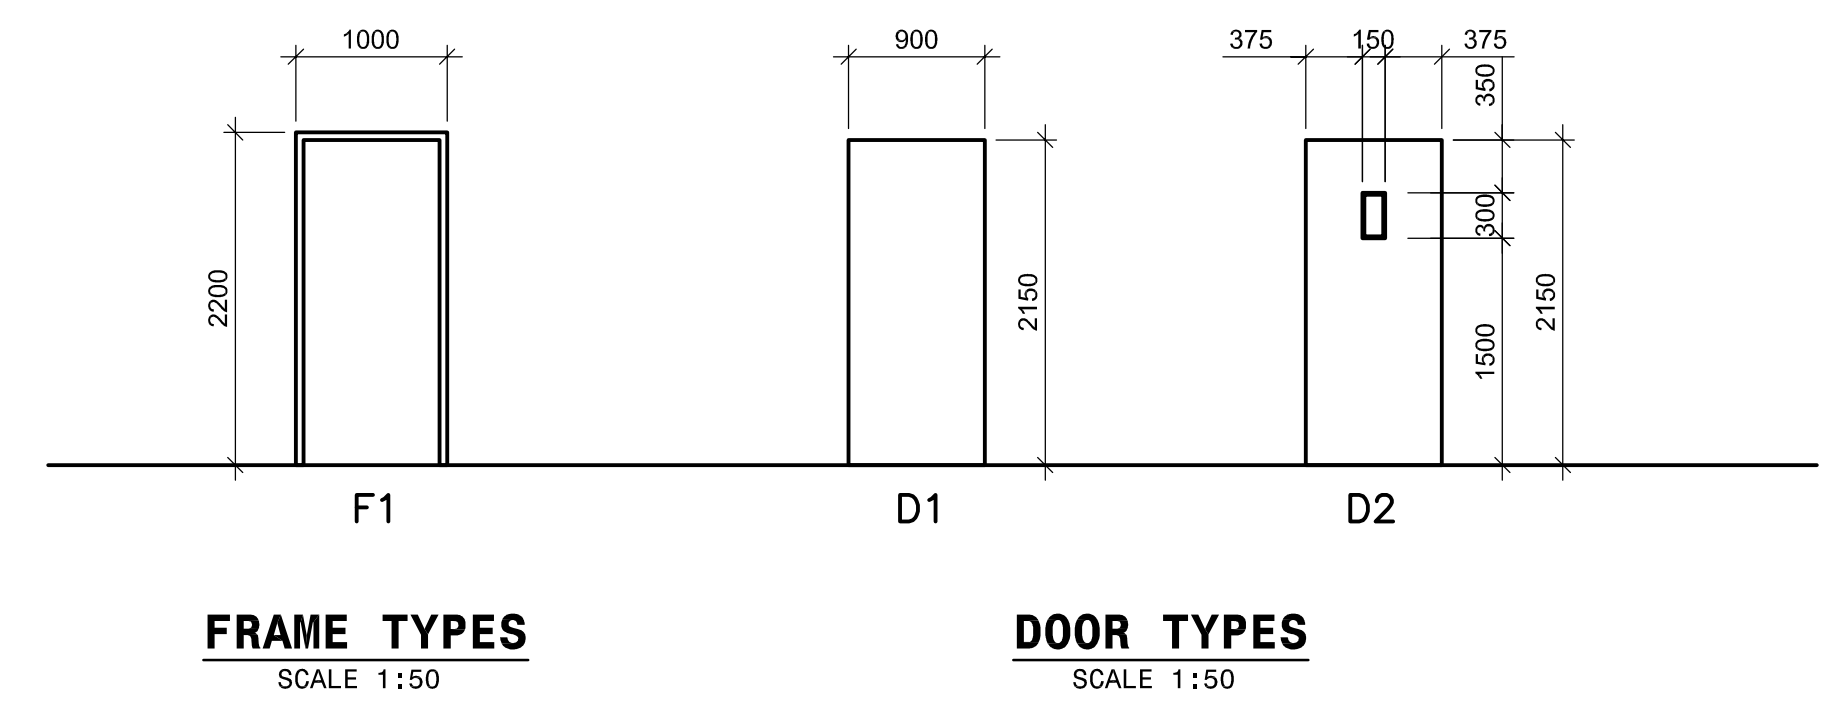

DOOR SCHEDULE

NO.	WIDTHxHEIGHTxTHICKNESS	DOOR					FRAME					RATING (HR)	REMARKS	HW SET
		TYPE	MAT.	FINISH	GLASS	MAT.	FINISH	TYPE	JAMB	HEAD				
D01	900x2150x45	D2	HM	PNT	GWG	HM	PT	F1			3/4	LH		
D02	900x2150x45	D2	HM	PNT	GWG	HM	PT	F1			3/4	LH		
D03	900x2150x45	D2	HM	PNT	GWG	HM	PT	F1			3/4	LH		
D04	900x2150x45	D2	HM	PNT	GWG	HM	PT	F1			3/4	RHR		
D05	900x2150x45	D2	HM	PNT	GWG	HM	PT	F1			3/4	RH		
D06	900x2150x45	D1	HM	PNT	-	HM	PT	F1			-	RHR		
D07	900x2150x45	D1	HM	PNT	-	HM	PT	F1			-	RHR		
D08	900x2150x45	D1	HM	PNT	-	HM	PT	F1			-	LHR		

ROOM FINISH SCHEDULE

ROOM No.	ROOM NAME	FLOOR		NORTH WALL		SOUTH WALL		EAST WALL		WEST WALL		CEILING		HEIGHT	REMARKS
		MATERIAL	BASE	MATERIAL	FIN.	MATERIAL	FIN.	MATERIAL	FIN.	MATERIAL	FIN.	MATERIAL	FIN.		
101	STAIRWELL 1	CONC	-	CONC/CMU	PT	CONC/CMU	PT	CONC/CMU	PT	CONC/CMU	PT	PC CONC	PT		
102	PUMP ROOM	CONC	-	CONC	PT	CONC	PT	CONC	PT	CONC	PT	PC CONC	PT		
201	VALVE ROOM	CONC	-	CONC	PT	CONC	PT	CONC	PT	CONC	PT	PC CONC	PT		
202	WET WELL-LEVEL 200	CONC	-	CONC	PT	CONC	PT	CONC	PT	CONC	PT	PC CONC	PT		
301	STAIRWELL 2	CONC	-	CONC/CMU	PT	CONC/CMU	PT	CONC/CMU	PT	CONC/CMU	PT	PC CONC	PT		
302	WET WELL-LEVEL 300	CONC	-	CONC	PT	CONC	PT	CONC	PT	CONC	PT	PC CONC	PT		
303	MOTOR ROOM	CONC	-	CONC	PT	CONC	PT	CONC	PT	CONC	PT	PC CONC	PT		
401	ELECTRICAL ROOM	CONC	-	CMU	PT	CMU	PT	CMU	PT	CMU	PT	PC CONC	PT		
402	CORRIDOR	CONC	-	CMU	PT	CMU	PT	CMU	PT	CMU	PT	PC CONC	PT		
403	CONTROL ROOM	CONC	-	CMU	PT	CMU	PT	CMU	PT	CMU	PT	PC CONC	PT		
404	GENERATOR ROOM	CONC	-	CMU	PT	CMU	PT	CMU	PT	CMU	PT	PC CONC	PT		
405	ENTRY	CONC	-	CMU	PT	CMU	PT	CMU	PT	CMU	PT	PC CONC	PT		



B.M. ELEV.	FIELD BOOK #:	Neil Cooper Architect Inc. 10-395 Berry Street, Winnipeg, Manitoba R3J 1N6 Phone (204) 885-3855 Fax (204) 831-7148		ENGINEER'S SEAL	THE CITY OF WINNIPEG WATER AND WASTE DEPARTMENT PERIMETER ROAD PUMPING STATION UPGRADES Contract B - Building Upgrades Architectural - New Construction BUILDING SECTION & SCHEDULES
POSTED TO LBIS		DESIGNED BY: NC	CHECKED BY: -	REVISION A ISSUED FOR BID WAS SEALED BY NEIL COOPER AND DATED DEC 14, 2007	
		DRAWN BY: CGC/AL	APPROVED BY: -		
		HOR. SCALE: AS NOTED	RELEASED FOR CONSTRUCTION		
		VERTICAL: AS NOTED			
A	ISSUED FOR BID	DATE: 07/12/14	DATE: 07/06/14		
NO. REVISIONS	DATE	BY	FILENAME: AR_BLDG_SEC.dwg		