
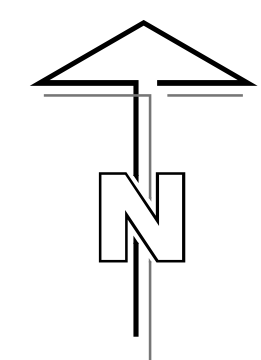



D SIZE 22" x 34" (559mm x 864mm)

PLOT: 07/12/18 9:10:52 AM

UMA FILE NAME: D265-202-02_03-E-0401_RX.dwg Saved By: djl

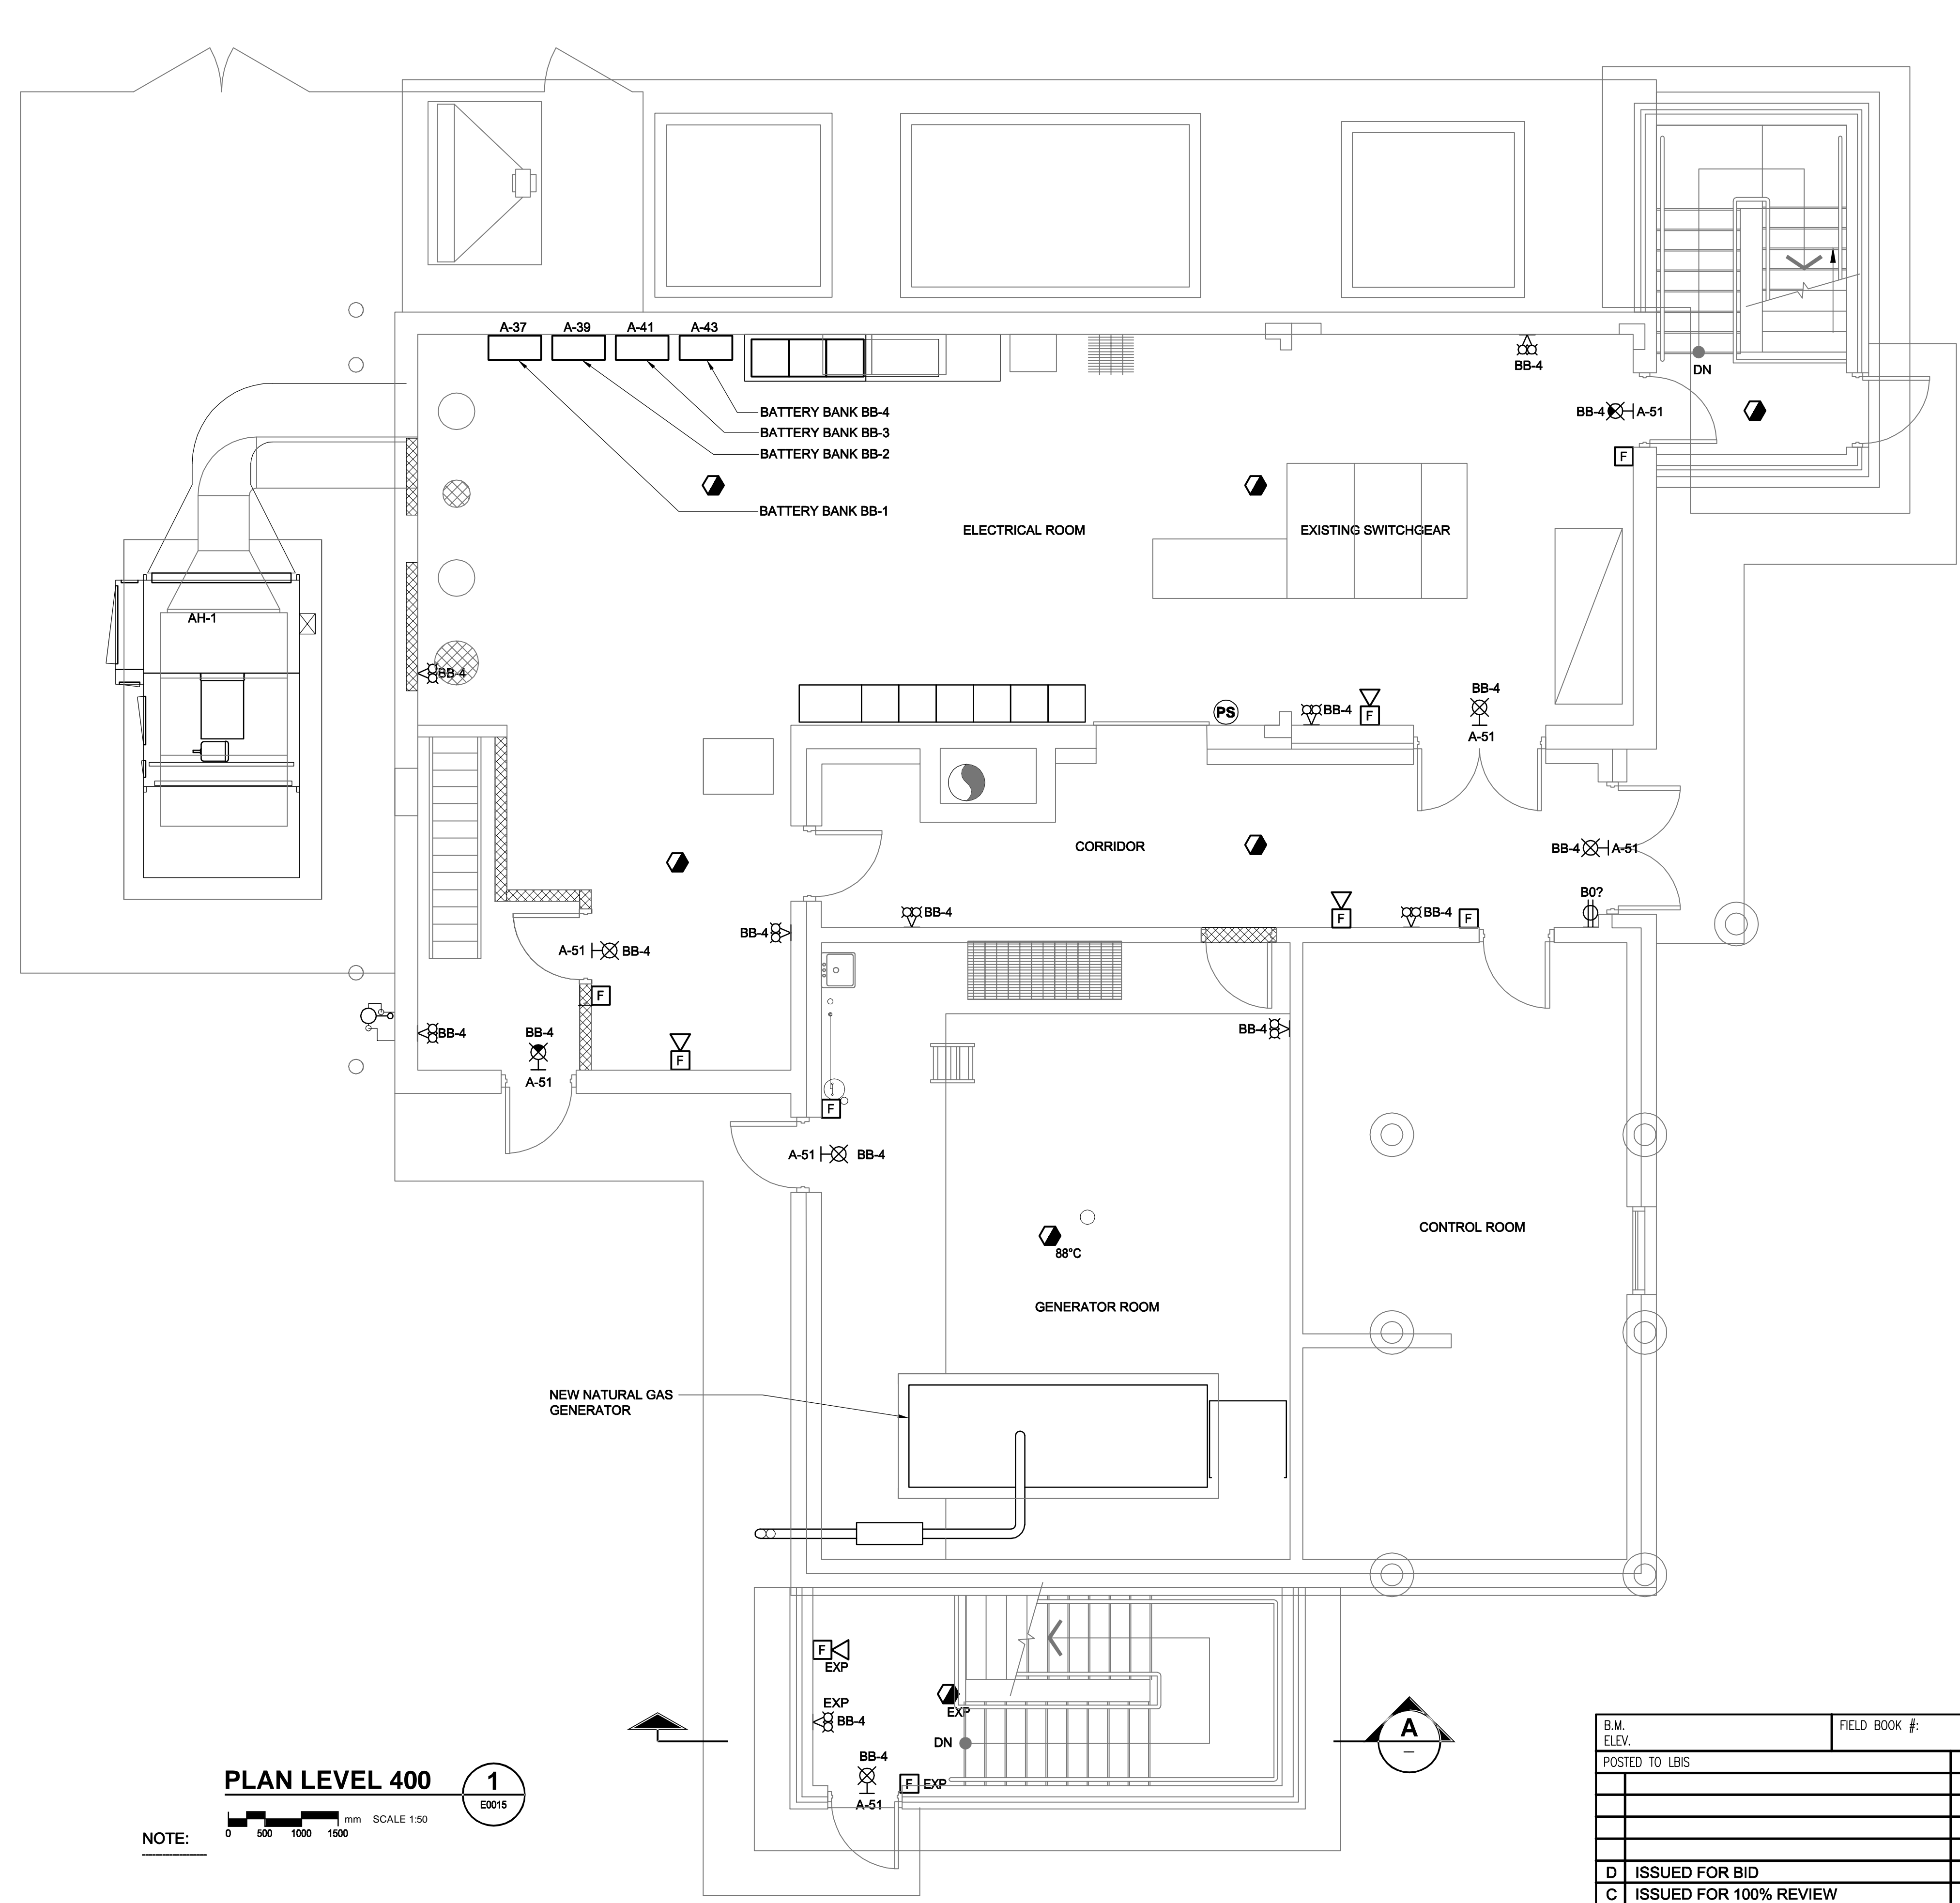

NOTE
 1. BATTERY BANKS BB-4, BB-2, BB-3 AND BB-4 SHALL COME EQUIPPED WITH ZONE SENSOR RELAYS TO ACTIVATE EMERGENCY LIGHTING HEADS UPON DE-ENERGIZATION OF ASSOCIATED LIGHTING.

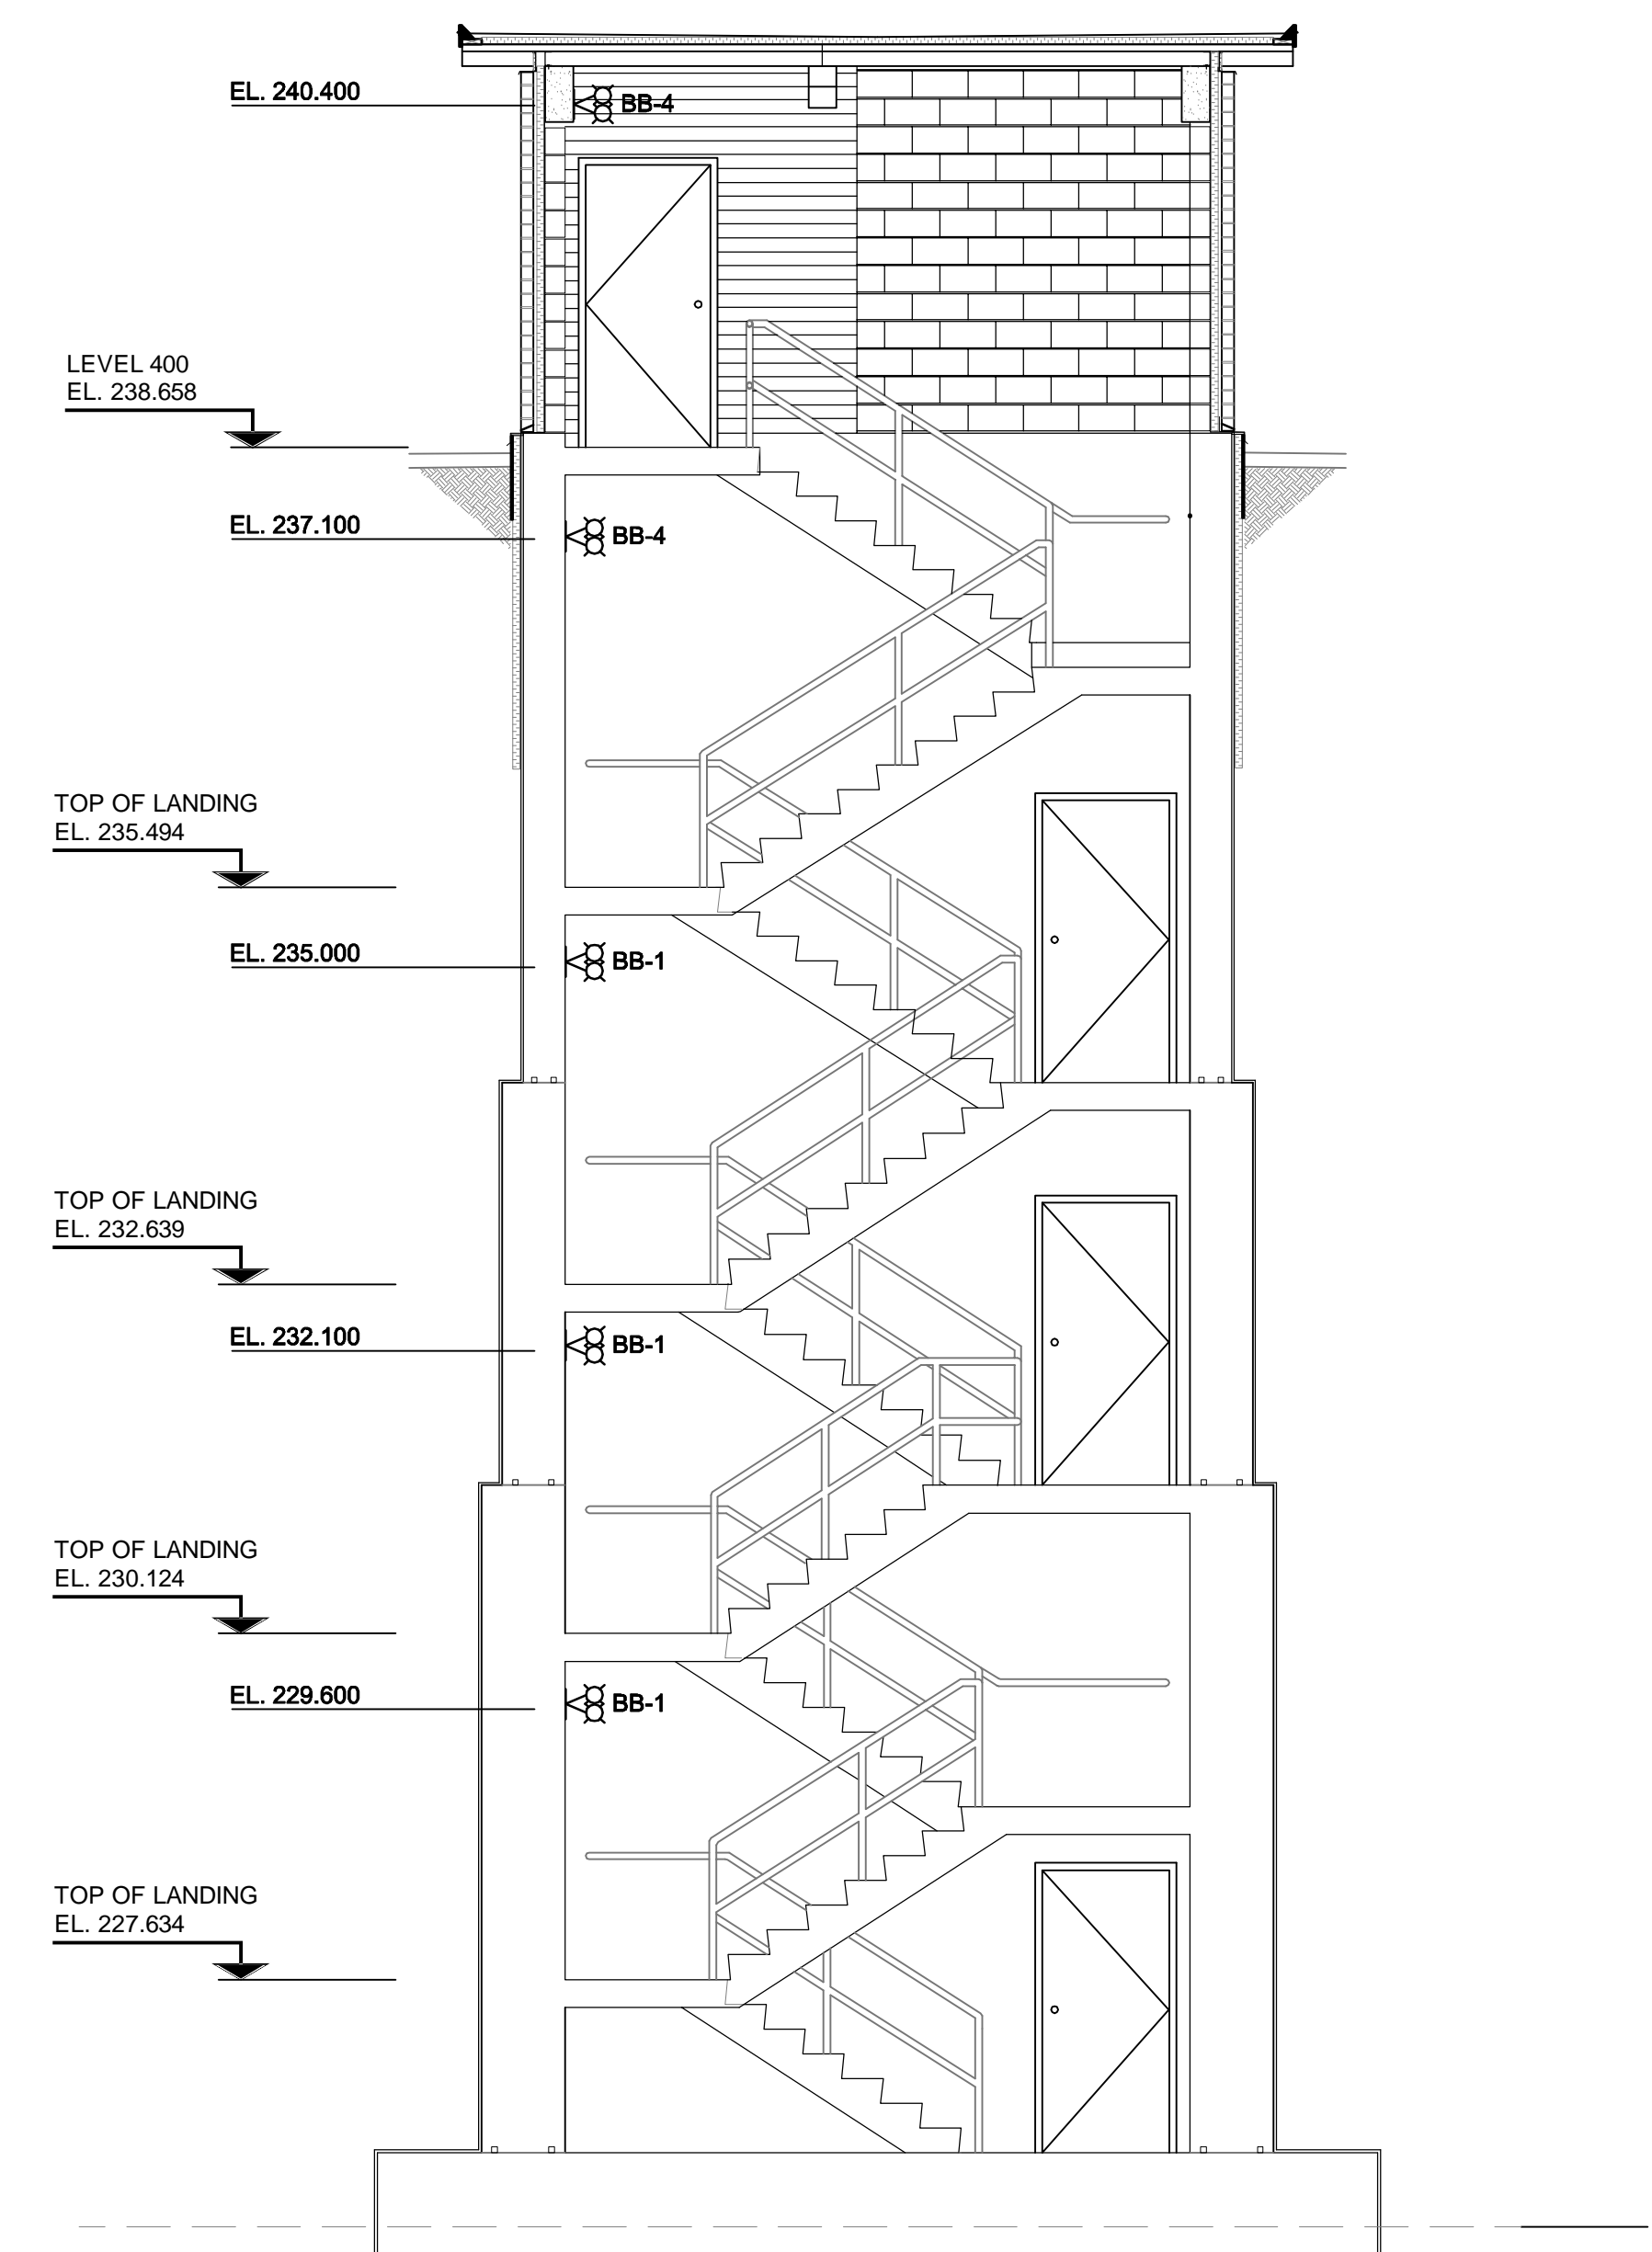

A STAIR SECTION - EMERGENCY LIGHTING
 SCALE: 1:50

PLAN LEVEL 400
 1
 E0015

NOTE: SCALE 1:50
 0 500 1000 1500 mm

APECM
 Certificate of Authorization
 UMA Engineering Ltd. (MB)
 No. 256 Date: 07/12/14

QL	RS	BM	BM	BF
DRN	CHK	DES	ENG	IDR
UMA REVIEW				

B.M. ELEV.	FIELD BOOK #:	UMA AECOM	
POSTED TO LBIS		© 2009 UMA ENGINEERING LTD. ALL RIGHTS RESERVED.	
DESIGNED BY	BM/LK	CHECKED BY	----
DRAWN BY	SCK	APPROVED BY	-
D	ISSUED FOR BID	07/12/14	LJV
C	ISSUED FOR 100% REVIEW	07/11/09	SCK
B	ISSUED FOR ZONING	07/08/21	SCK
A	ISSUED FOR 80% REVIEW	07/06/18	SCK
NO. REVISIONS	DATE	BY	FILENAME: D265-202-02_03-E-0401_RX.dwg

ENGINEER'S SEAL
 ISSUE / REVISION D
 ISSUED FOR BID
 WAS SEALED BY
 B.L. MOORE
 AND DATED
 07/12/14

THE CITY OF WINNIPEG
 WATER AND WASTE DEPARTMENT

PERIMETER ROAD PUMPING STATION UPGRADES
 Contract B - Building Upgrades

Electrical - Emergency Systems
 LEVEL 400 FLOOR PLAN

CITY DRAWING NUMBER	SHEET	REV.	SIZE
1-0111L-E0014	001	D	D