


UMA FILE NAME: F953-001-01-14-2004-RV.dwg DATE: 2007.02.21 FILE NAME: F953-001-01-14-2004-RV.dwg
 PROJECT No: F953-001-01 DESCRIPTION: ROOF PLAN HVAC
 PLOT: 07/07/20 2:31:34 PM
 ADDRESS: 999 Sargent St. Winnipeg, Manitoba

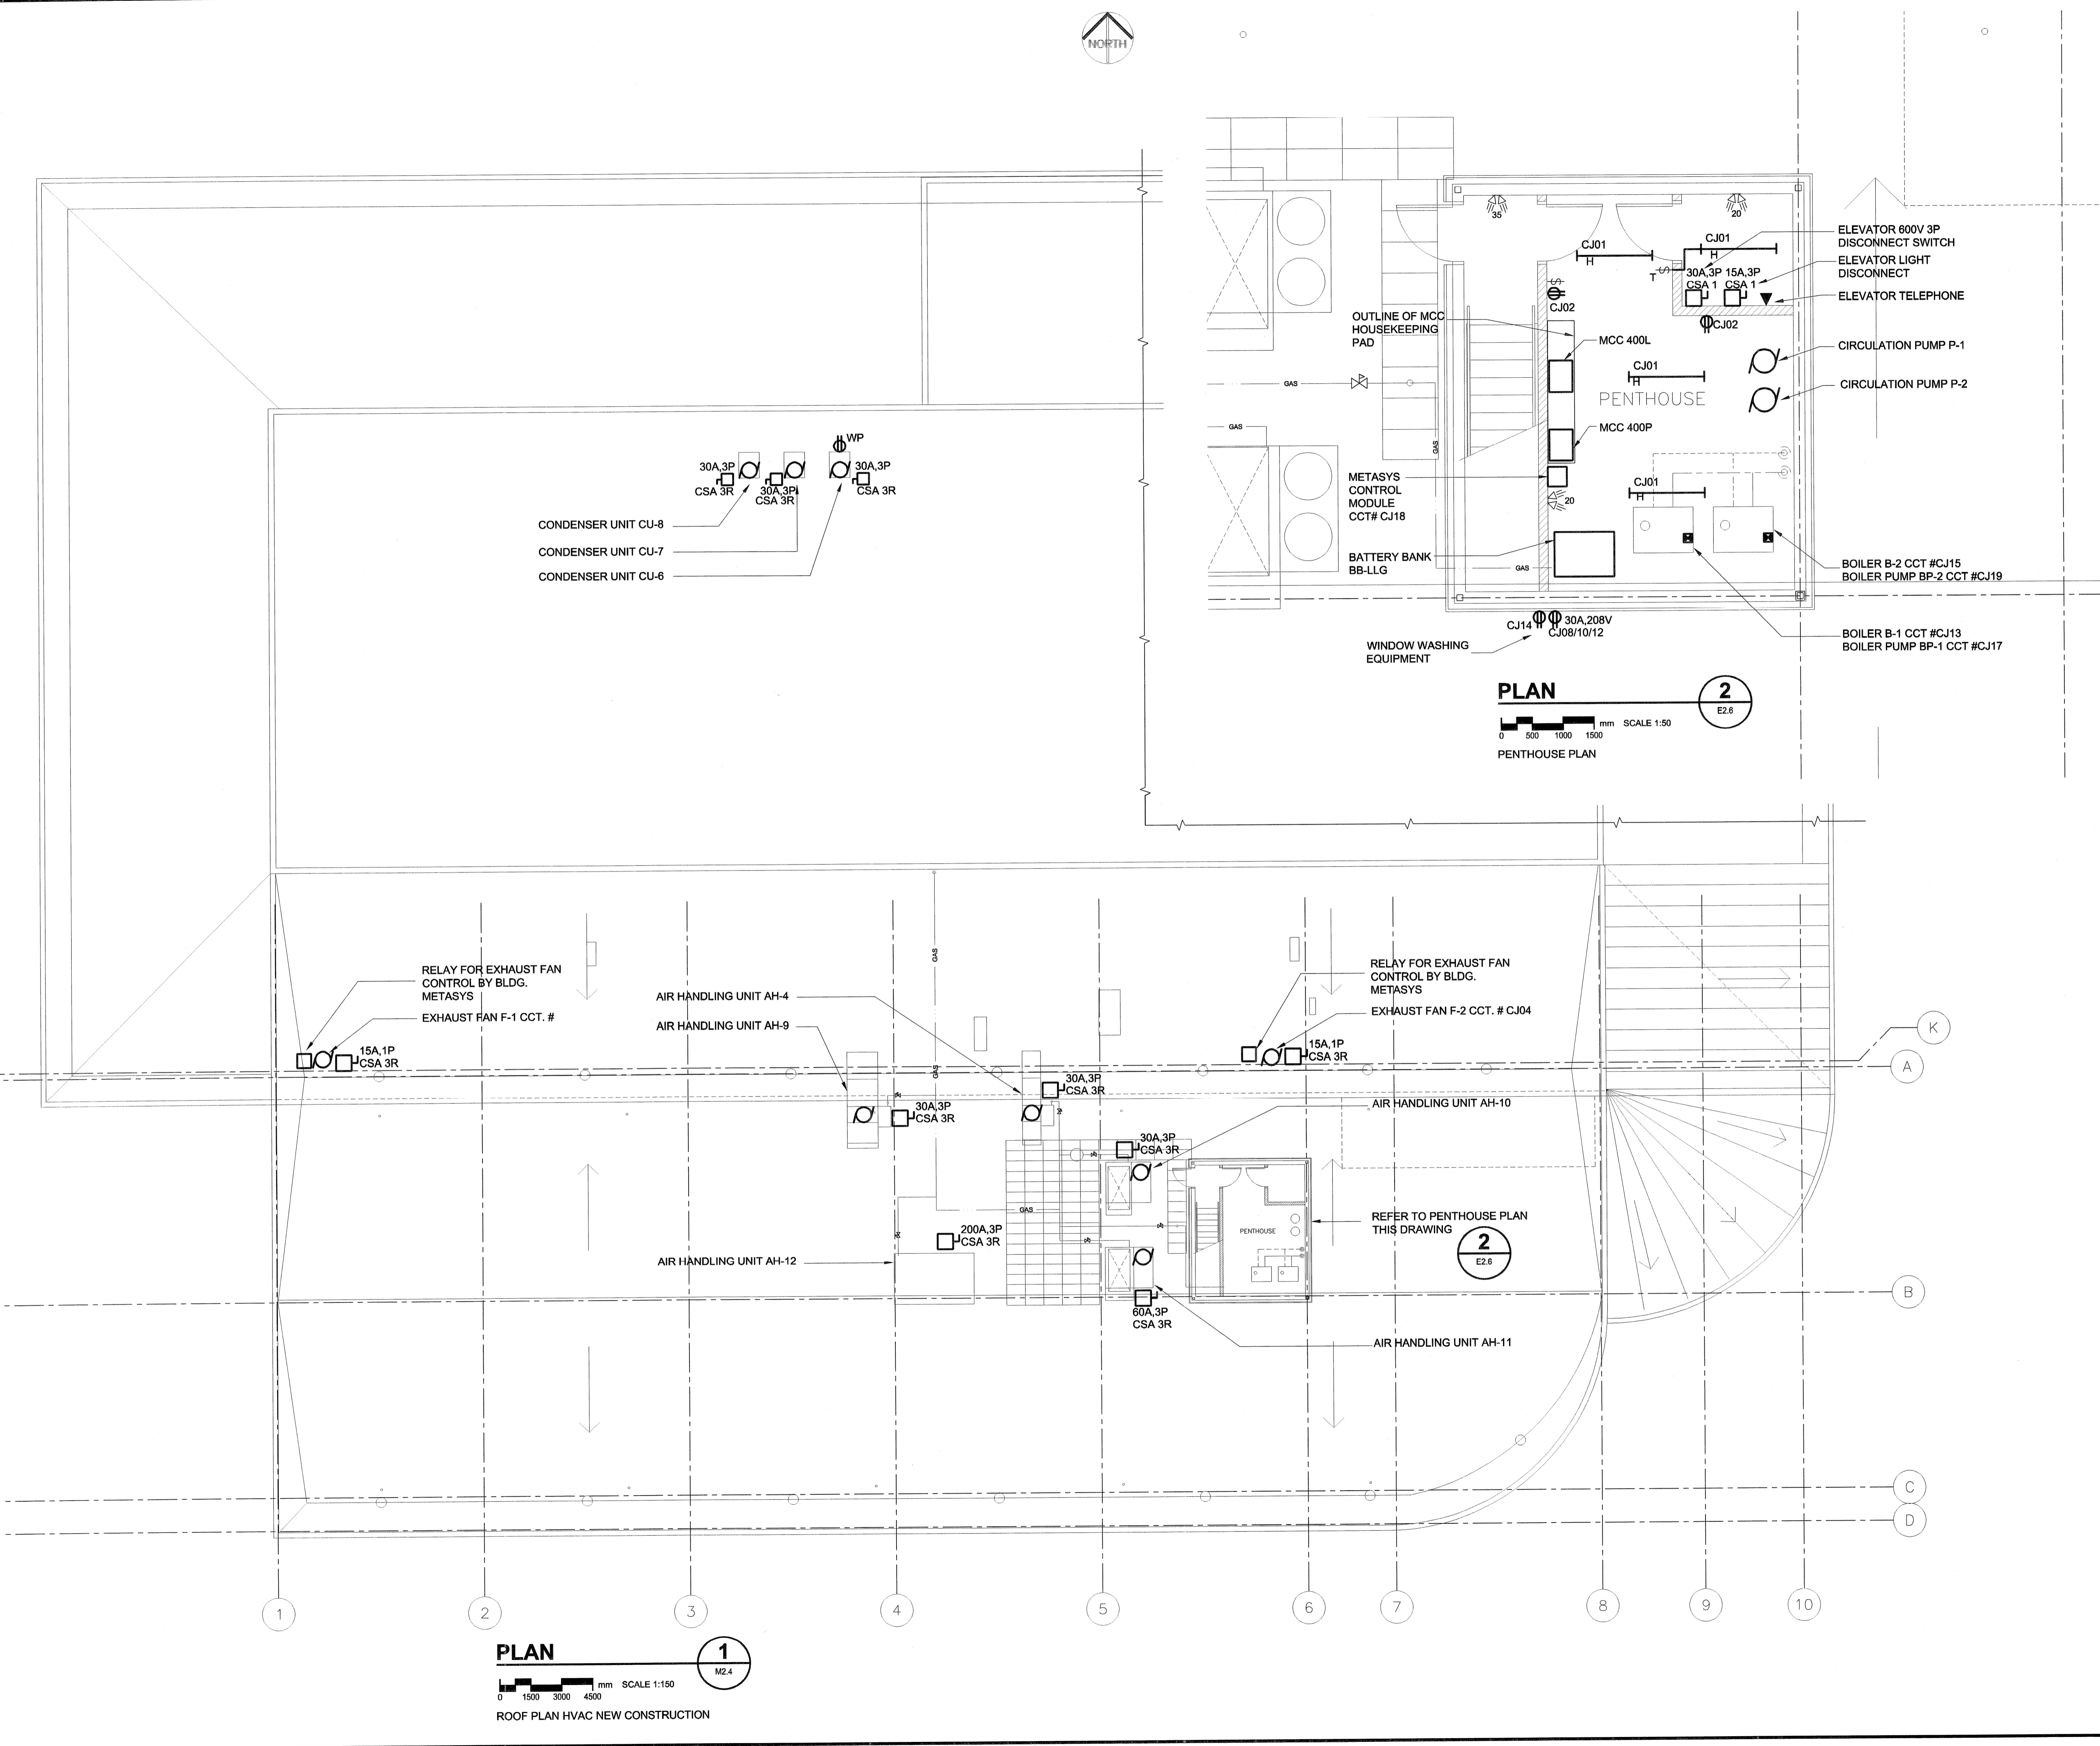

UMA | AECOM
 © 2007 UMA ENGINEERING LTD. ALL RIGHTS RESERVED.

APEGM
 Certificate of Authorization
 UMA Engineering Ltd. (MB)
 No. 256 Date: Jul 23, 2007

DRN	CHK	DES	ENG	IDR

UMA | AECOM REVIEW

NO.	REVISION/DESCRIPTION	BY	DATE
0	ISSUED FOR TENDER	CL	07/07/23

SEALS

PROVINCE OF MANITOBA
 S.K. [Signature]
 SMART Member
 20996
 REGISTERED PROFESSIONAL ENGINEER
 Jul 23, 2007

DRAWN BY	SKX	CHECKED BY	APPROVED
DATE	2007.07.17	USER APPROVAL	

CITY OF WINNIPEG
 PLANNING, PROPERTY & DEVELOPMENT DEPARTMENT
 CIVIC ACCOMMODATIONS DIVISION
 300 - 65 GARRY ST. R3C 4K4

PROJECT
Construction of Cindy Klassen Recreation Complex Facility Enhancement Project
 999 Sargent St. Winnipeg, Manitoba

SHEET TITLE
 Electrical
 Roof and Penthouse Plan
 New Construction

SCALE	PROJECT NO.	SHEET NO.
AS SHOWN	2005-059	E2.6

DRAWING SHEET SIZE: A1 (841mm x 594mm) PLOT 1:1