
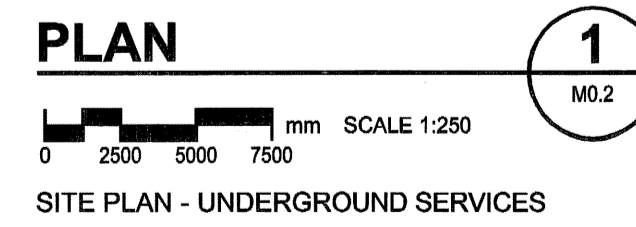


UMA FILE NAME: F953-001-01_01-14-002_RV.dwg
 DATE: 2007.02.21
 DESCRIPTION: Site Plan Underground Services
 PROJECT No: F953-001-01
 PLOT: 07/07/23 11:05:47 AM
 ADDRESS: 999 Sargent St. Winnipeg, Manitoba
 UMA FILE NAME: F953-001-01_01-14-002_RV.dwg

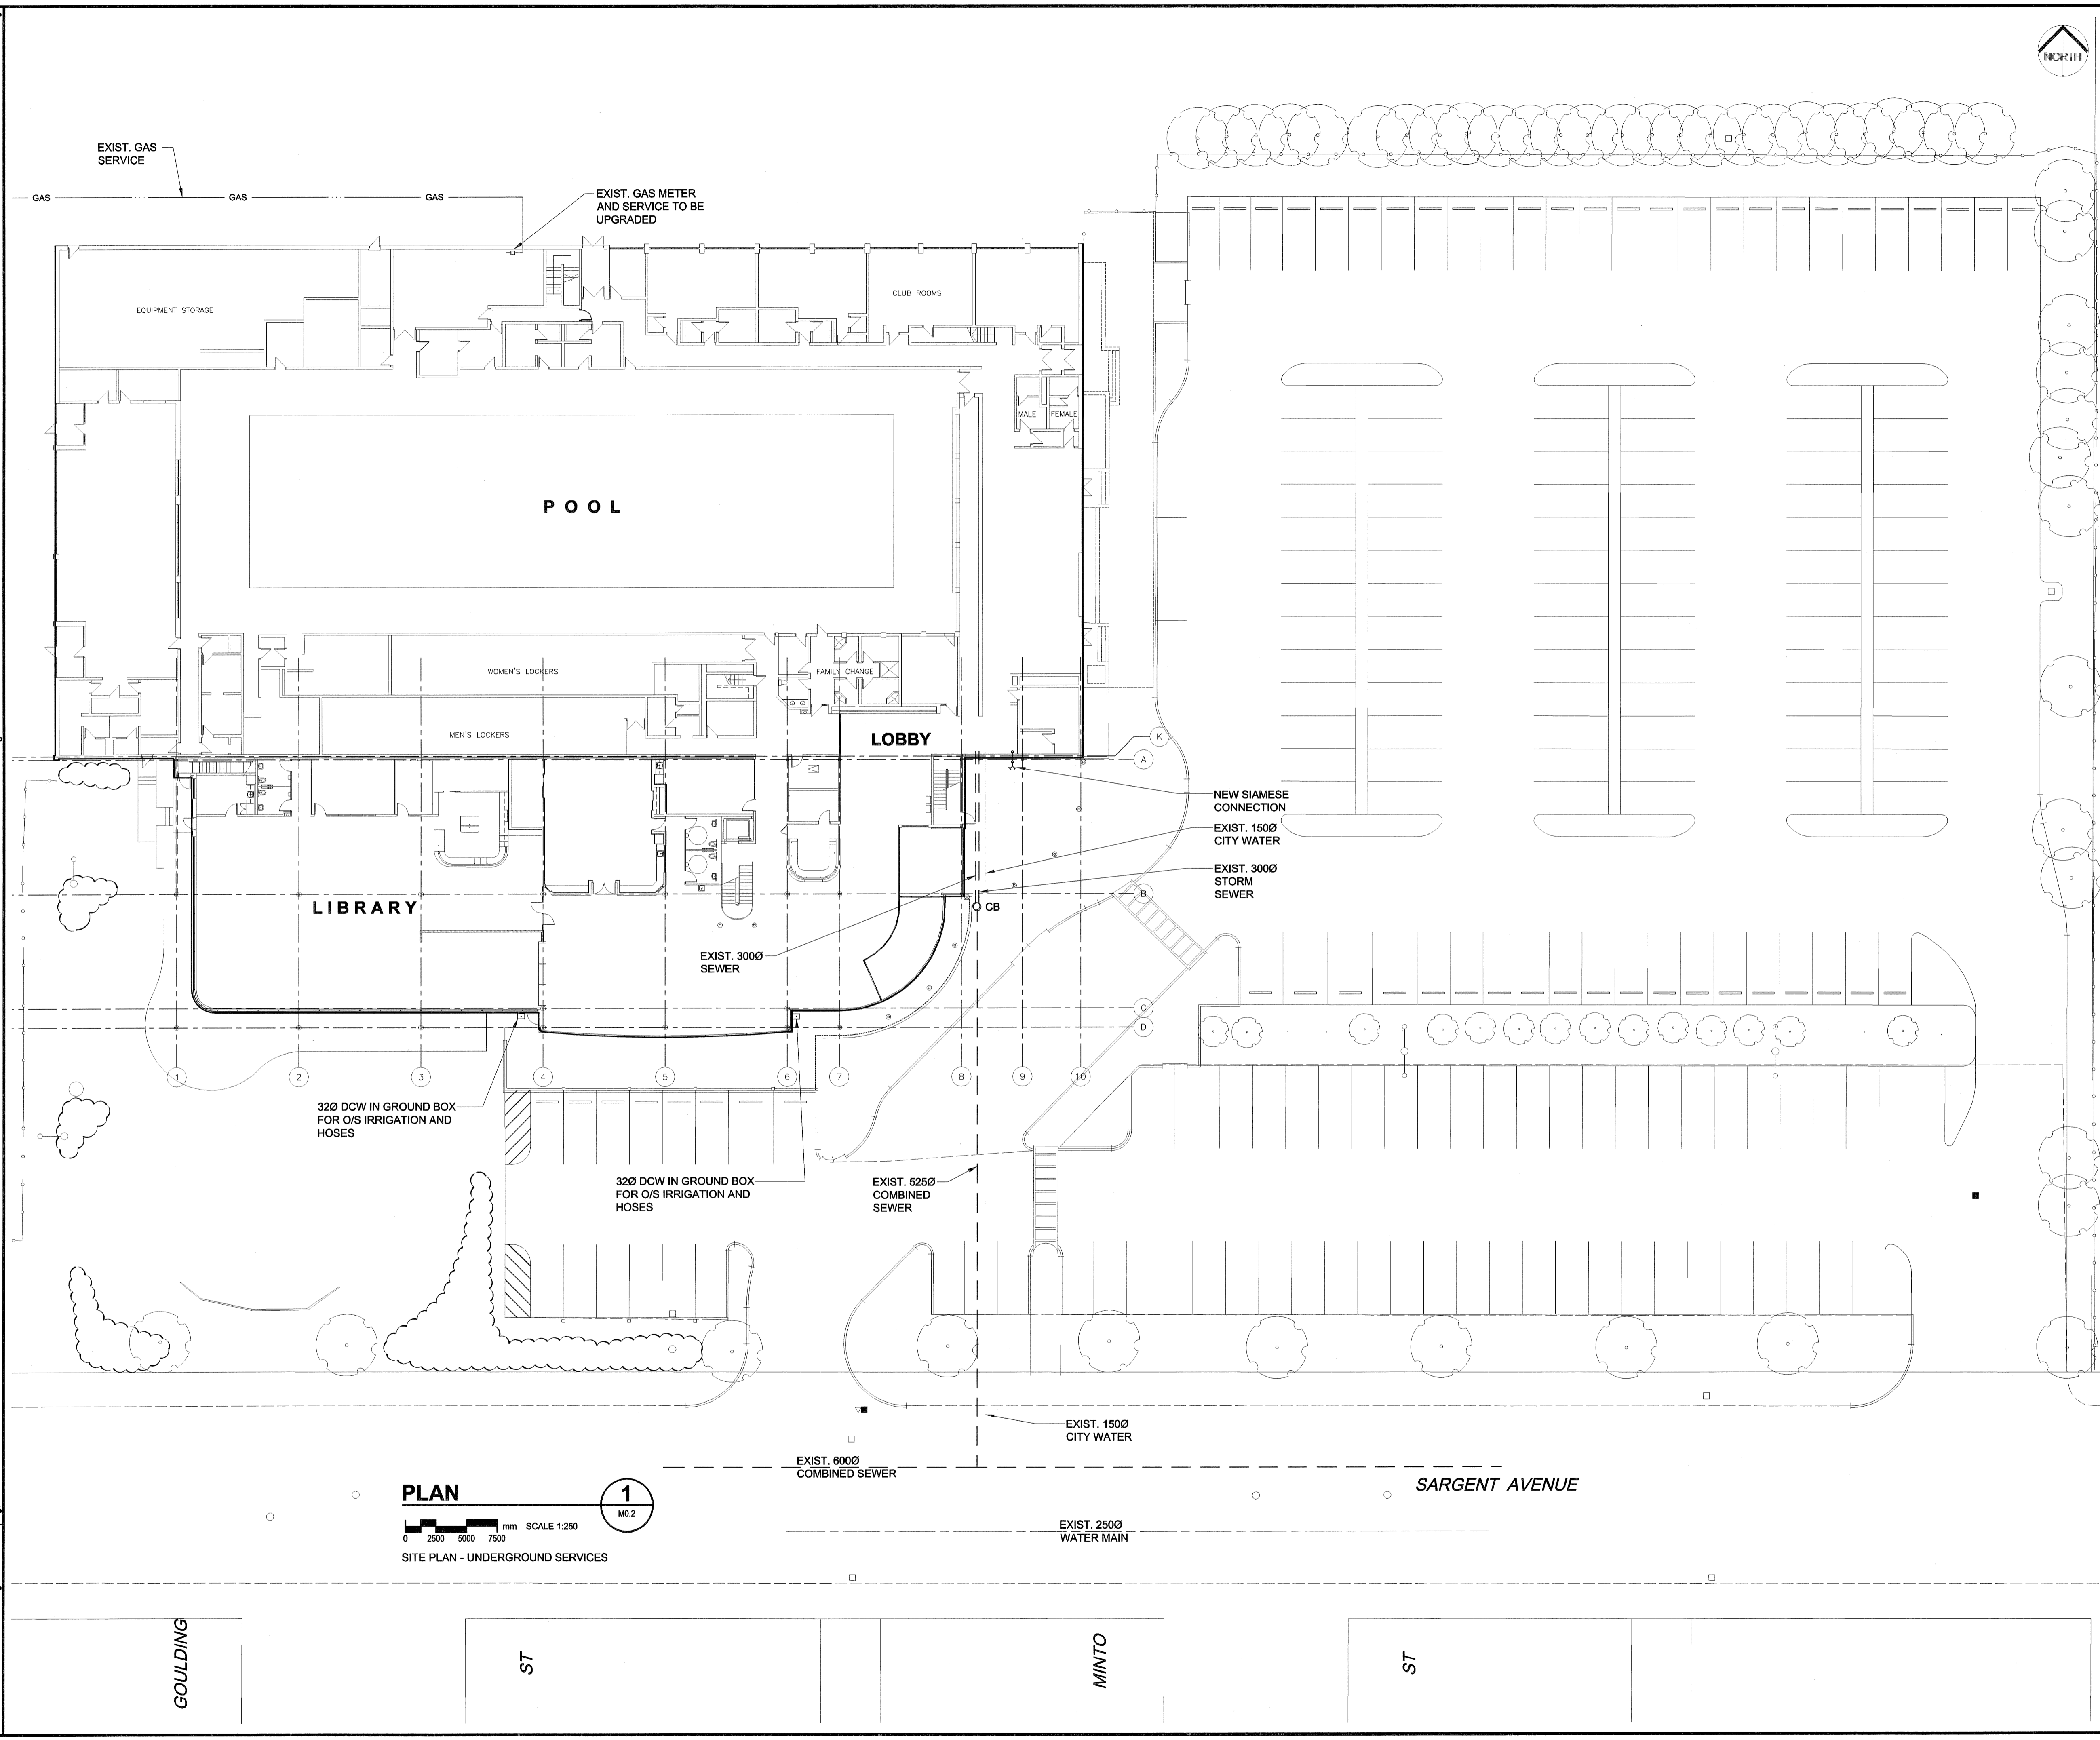

UMA | AECOM

© 2007 UMA ENGINEERING LTD. ALL RIGHTS RESERVED.

APEGM
 Certificate of Authorization
 UMA Engineering Ltd. (MB)
 No. 256 Date: 07/07/23

DRN CHK DES ENG IDR
 UMA | AECOM REVIEW

0	ISSUED FOR TENDER	RJP	07/07/23
NO.	REVISION/DESCRIPTION	BY	DATE

SEALS

PROVINCE OF MANITOBA
 July 20, 2023
 B.M. PETERSON
 REGISTERED PROFESSIONAL ENGINEER

DRAWN BY RJP CHECKED BY APPROVED
 DATE 2007.07.17 USER APPROVAL

CITY OF WINNIPEG
 PLANNING, PROPERTY & DEVELOPMENT DEPARTMENT
 CIVIC ACCOMMODATIONS DIVISION
 300 - 65 GARRY ST. R3C 4K4

PROJECT
Construction of Cindy Klassen Recreation Complex Facility Enhancement Project
 999 Sargent St. Winnipeg, Manitoba

SHEET TITLE
 Mechanical
 Site Plan
 Underground Services

SCALE 1:250	PROJECT NO. 2005-059	SHEET NO. M0.2
----------------	-------------------------	--------------------------

DRAWING SHEET SIZE: A1 (841mm x 594mm) PLOT 1:1