



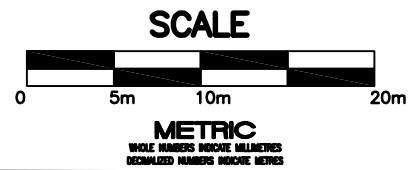

CONSTRUCTION NOTES:

1. ALL CONSTRUCTION SHALL BE IN ACCORDANCE WITH THE CITY OF WINNIPEG STANDARD CONSTRUCTION SPECIFICATIONS, LATEST EDITION.
2. LOCATION OF UNDERGROUND STRUCTURES AS SHOWN ARE BASED ON THE BEST INFORMATION AVAILABLE. NO GUARANTEE IS GIVEN THAT ALL EXISTING UTILITIES ARE SHOWN OR THAT THE GIVEN LOCATIONS ARE EXACT.
3. CONFIRMATION OF EXISTENCE AND EXACT LOCATION OF ALL SERVICES MUST BE OBTAINED FROM THE INDIVIDUAL UTILITIES BEFORE PROCEEDING WITH CONSTRUCTION. LOCATION AND ELEVATION OF EXISTING WORKS TO BE VERIFIED BY THE CONTRACTOR PRIOR TO CONSTRUCTION. IT IS THE RESPONSIBILITY OF THE CONTRACTOR TO VERIFY THE LOCATIONS OF SUCH UTILITIES, PIPES, SURVEY MARKERS, OR STRUCTURES, AND TO NOTIFY ALL RELEVANT UTILITIES PRIOR TO COMMENCEMENT OF CONSTRUCTION. THE CONTRACTOR SHALL NOTIFY THE CONTRACT ADMINISTRATOR OF ANY ERROR OR OMISSION PRIOR TO CONSTRUCTION.
4. MEASUREMENTS ARE IN METRIC. WHOLE NUMBERS INDICATE MILLIMETRES, DECIMALIZED NUMBERS INDICATE METRES.

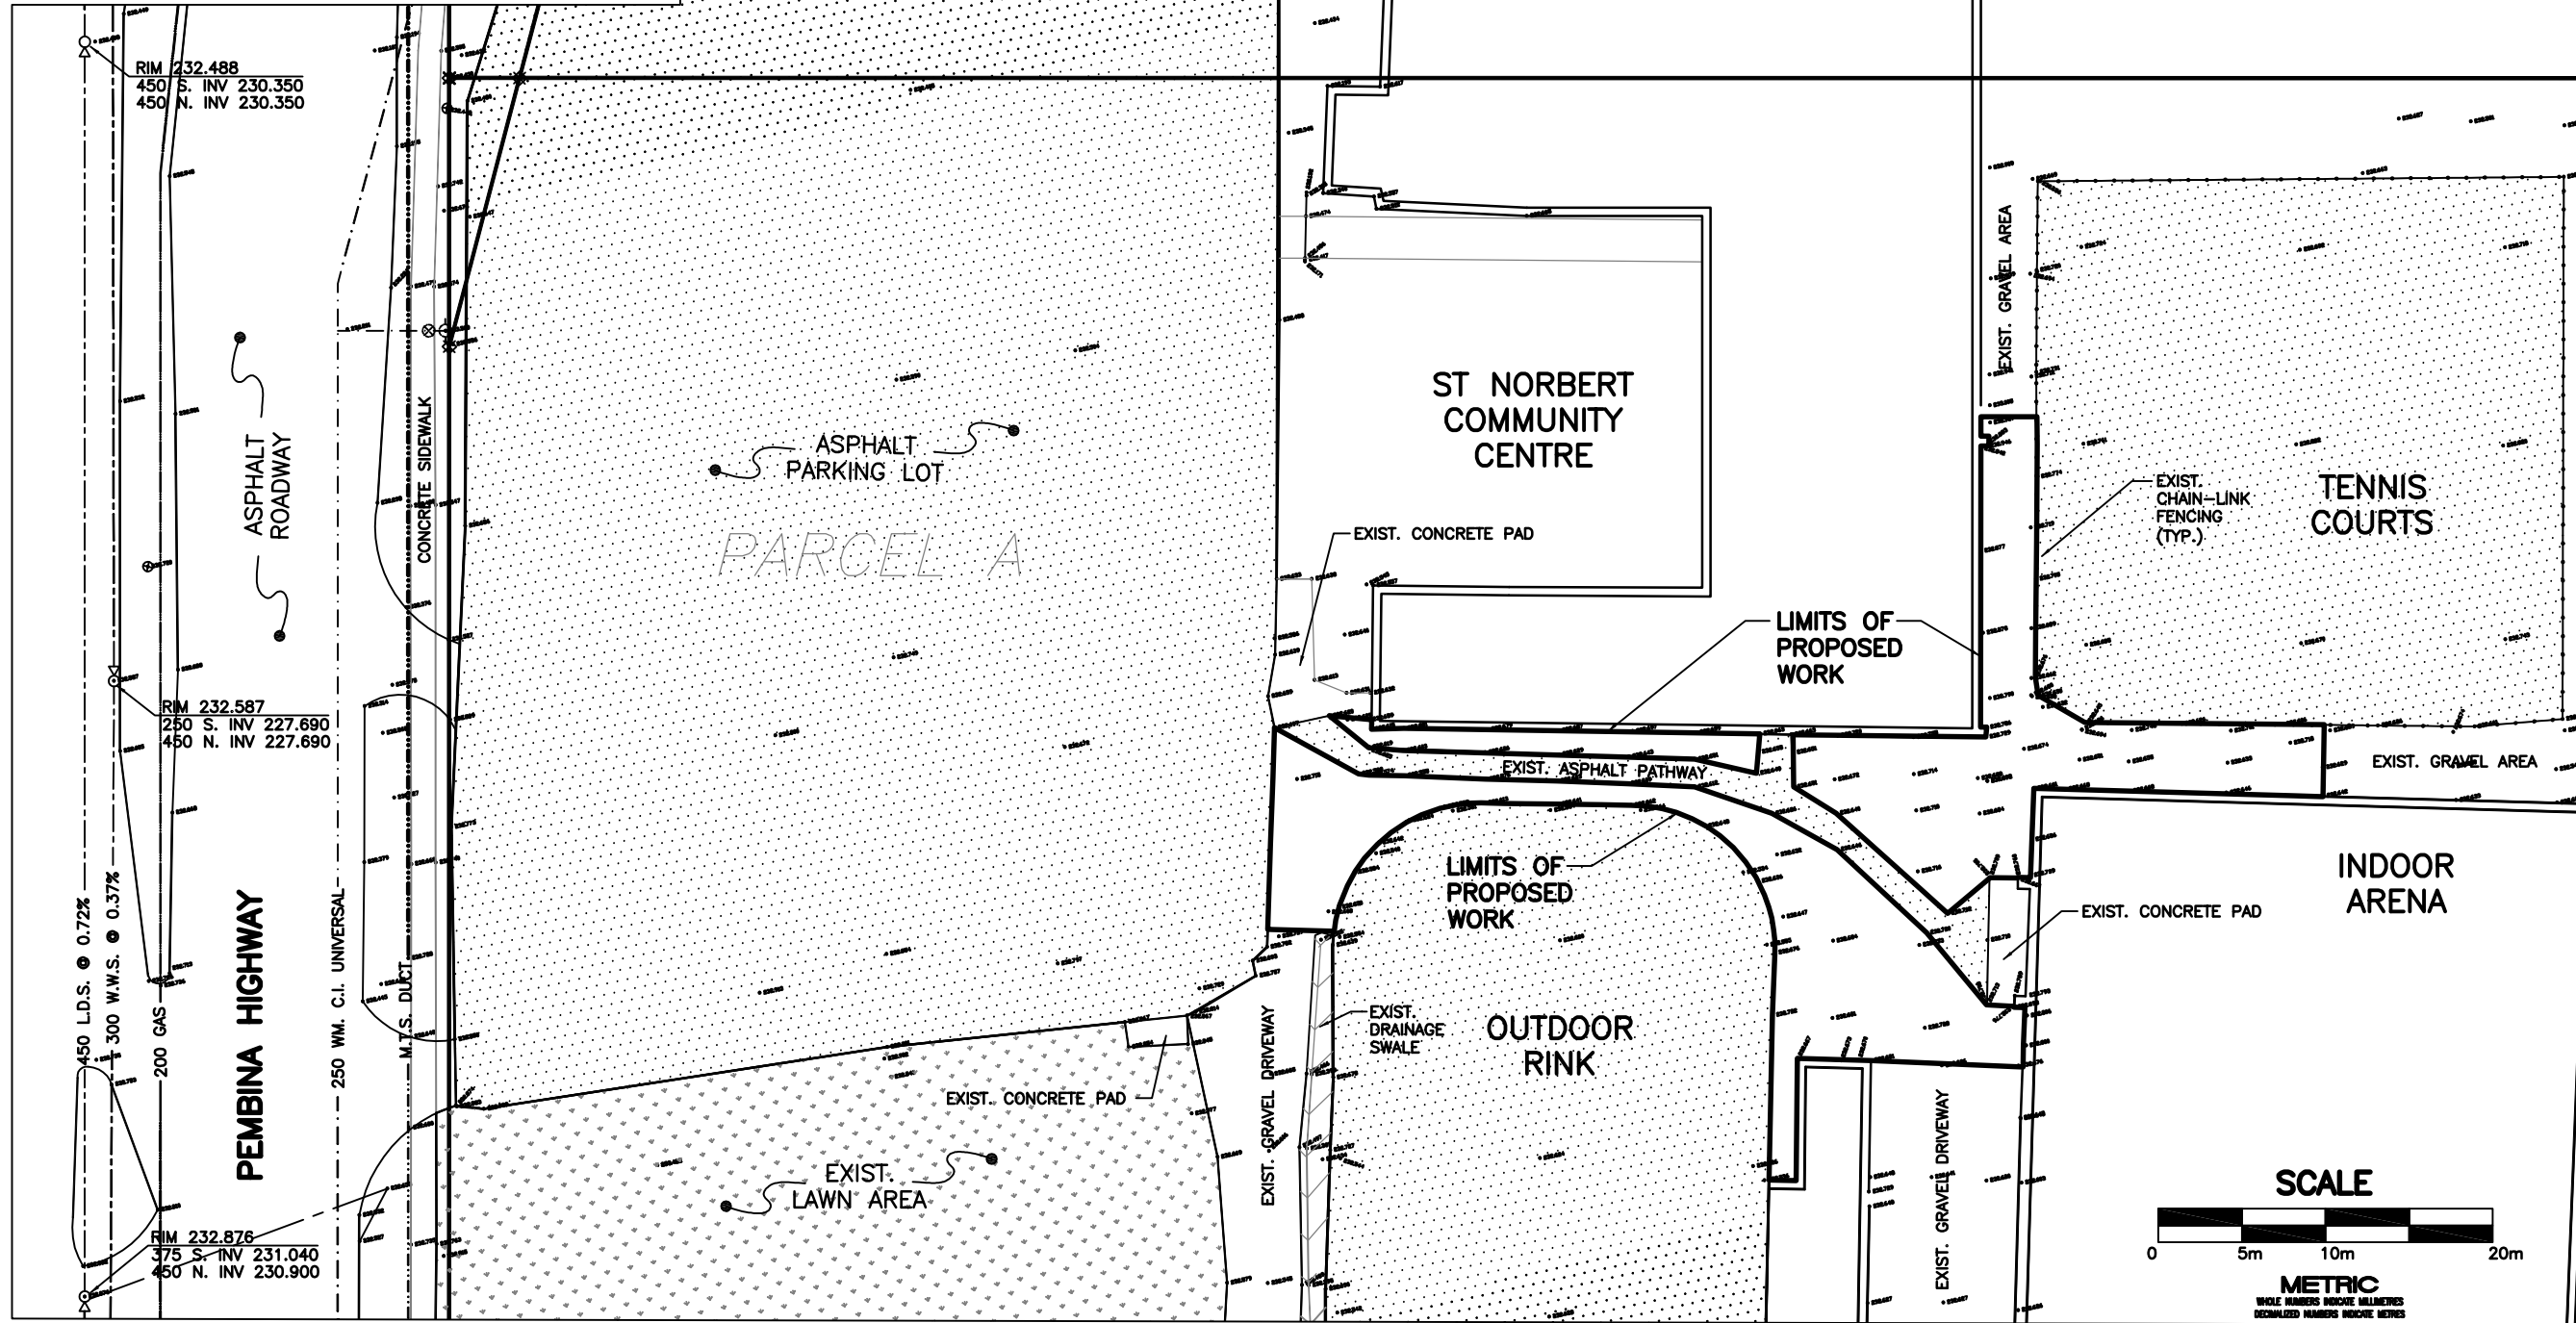

150 mm WM	WATERMAIN	150 mm WM	HYDRO	150 mm WM	WATERMAIN
+	HYDRANT	+	MTS	+	HYDRANT
o	VALVE	o	GRASS	o	VALVE
300 mm L/S	LAND DRAINAGE SEWER	300 mm L/S	SWALE	300 mm L/S	SEWER
250 mm CS	COMBINED SEWER	250 mm CS	CURB RENEWAL	300 mm L/S	SEWER
o	MANHOLE	o	ASPHALT	300 mm L/S	SEWER
□	CATCH BASIN (CB)	□	ELEVATIONS	300 mm L/S	SEWER
△	CATCH PIT (CP)	△	PROPERTY LINE	300 mm L/S	SEWER
o	SIGN	o	SURVEY BAR	300 mm L/S	SEWER
o	LAMP STANDARD	o	CURB STOP	300 mm L/S	SEWER
o	GAS	o	RAMP CURB	300 mm L/S	SEWER
EXISTING	LEGEND - PLAN	NEW	EXISTING	LEGEND - PROFILE	NEW

LOCATION APPROVED UNDERGROUND STRUCTURES

DATE: _____

NOTE: LOCATION OF UNDERGROUND STRUCTURES AS SHOWN ARE BASED ON THE BEST INFORMATION AVAILABLE. BUT NO GUARANTEE IS GIVEN THAT ALL EXISTING UTILITIES ARE SHOWN OR THAT THE GIVEN LOCATIONS ARE EXACT. CONFIRMATION OF EXISTENCE AND EXACT LOCATION OF ALL SERVICES MUST BE OBTAINED FROM THE INDIVIDUAL UTILITIES BEFORE PROCEEDING WITH CONSTRUCTION.

GENIVAR
 600-5 DONALD STREET
 WINNIPEG, MB R3L 2T4
 Tel: (204)477-6650
 Fax: (204)474-2864

DESIGNED BY: W.D.M. CHECKED BY: D.T.S.
 DRAWN BY: W.D.M. APPROVED BY: B.D.E.

HOR. SCALE: 1:800
 DATE: July 24, 2007

ENGINEER'S SEAL
 PROVINCE OF MANITOBA
 D.T. BLACKBURN
 Member
 23146
 REGISTERED PROFESSIONAL ENGINEER

THE CITY OF WINNIPEG
 PUBLIC WORKS DEPARTMENT

ST NORBERT COMMUNITY CENTER DRAINAGE IMPROVEMENT PROJECT

EXISTING SITE PLAN

CITY DRAWING NUMBER: 535-2007-C01
 SHEET 1 OF 2

REV. 0

L:\Projects\2007\WE-07-101-WE\Drawings\02 Working Drawings\04 Civil\Submissions\535-2007_DRAWING_C01-R0.dwg, 7/30/2007 8:34:10 AM