
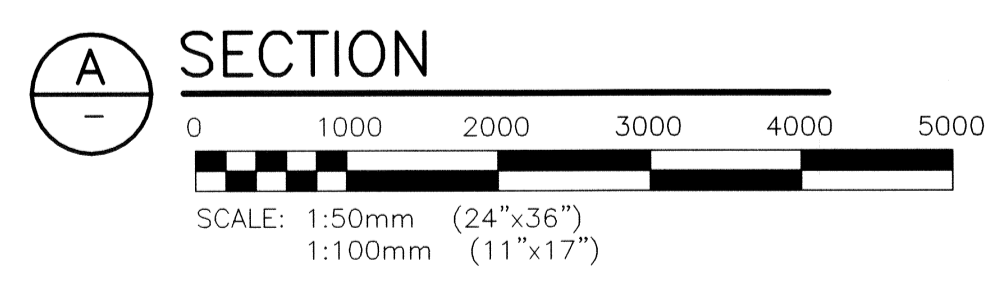
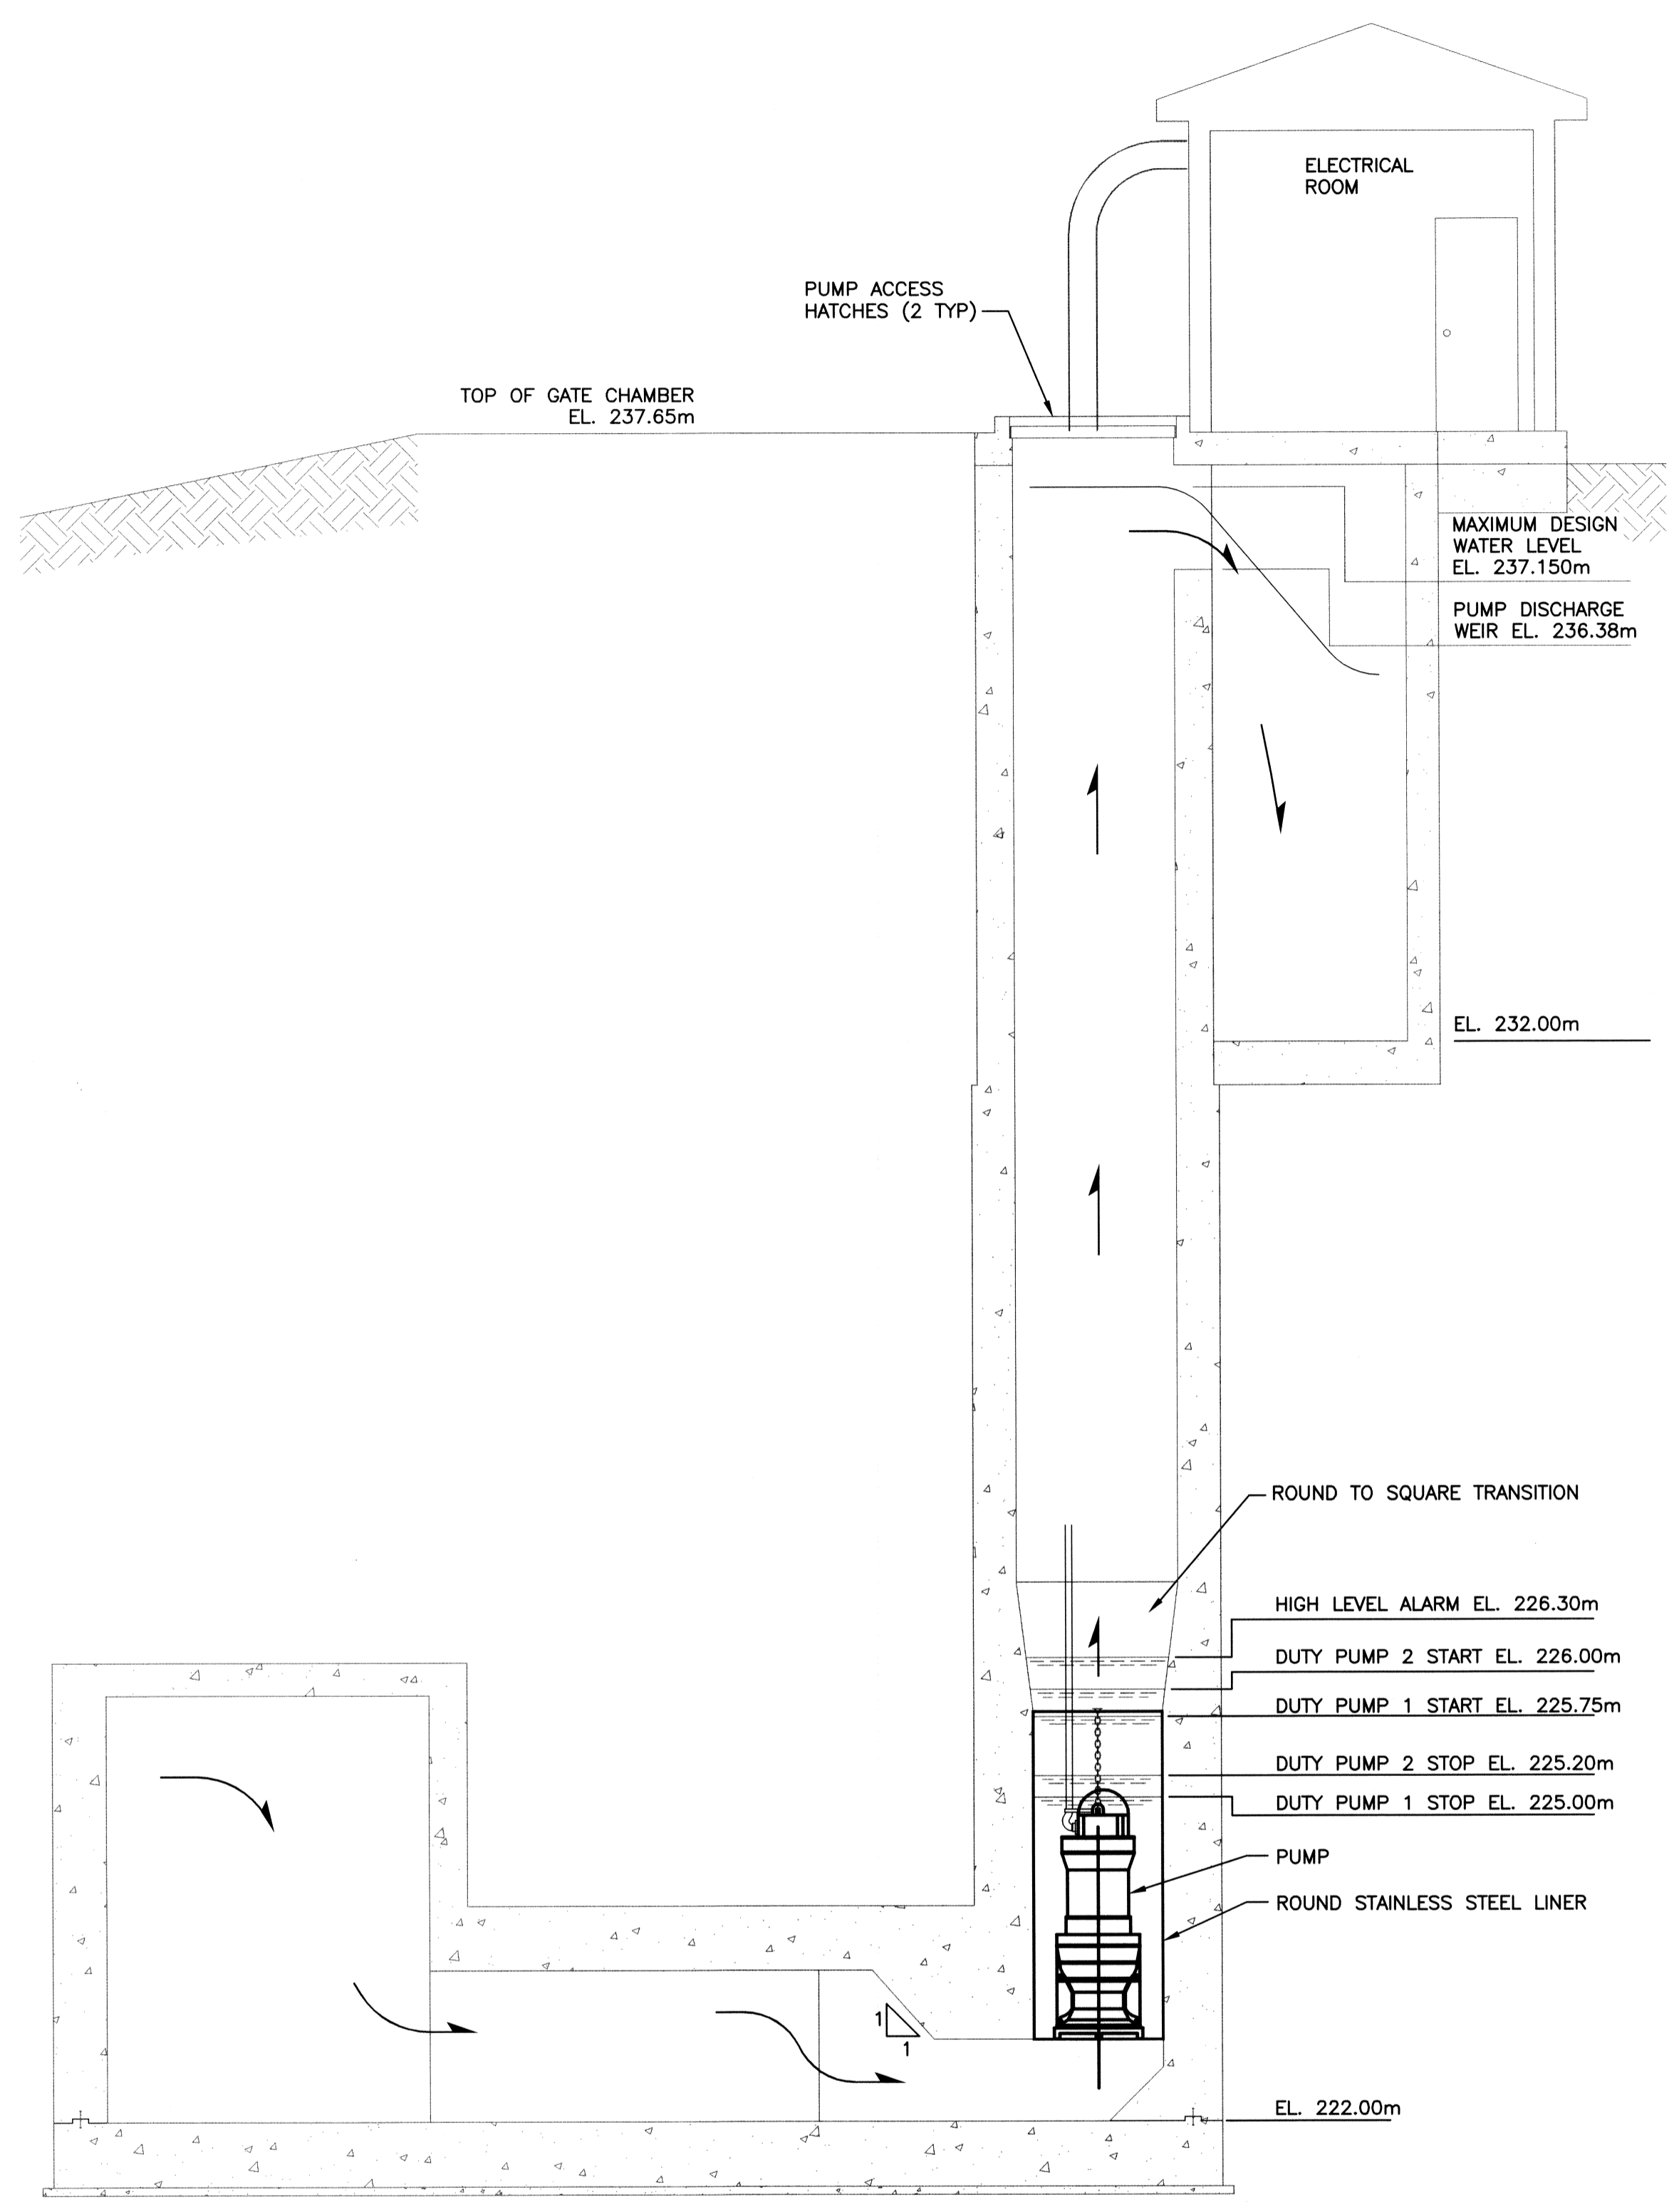
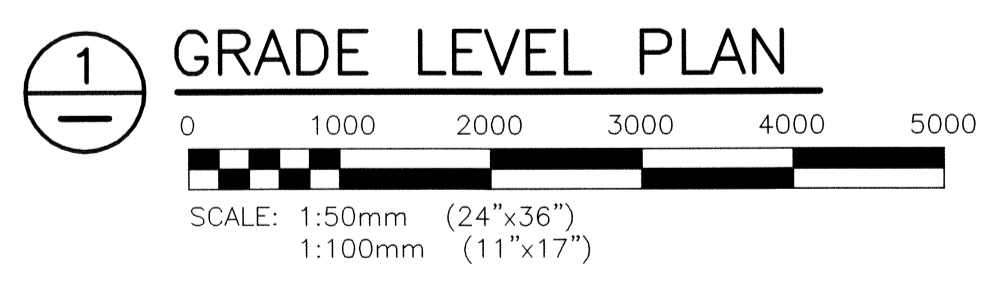


24"x36"/[609x914] P:\Projects\2005\05-0107-17\Mech\Draws\CC5-48aM-001c-01-00.dwg - Tab: M001.dwg - Jun 01, 2007 - 4:54pm - UserName: GNilsson

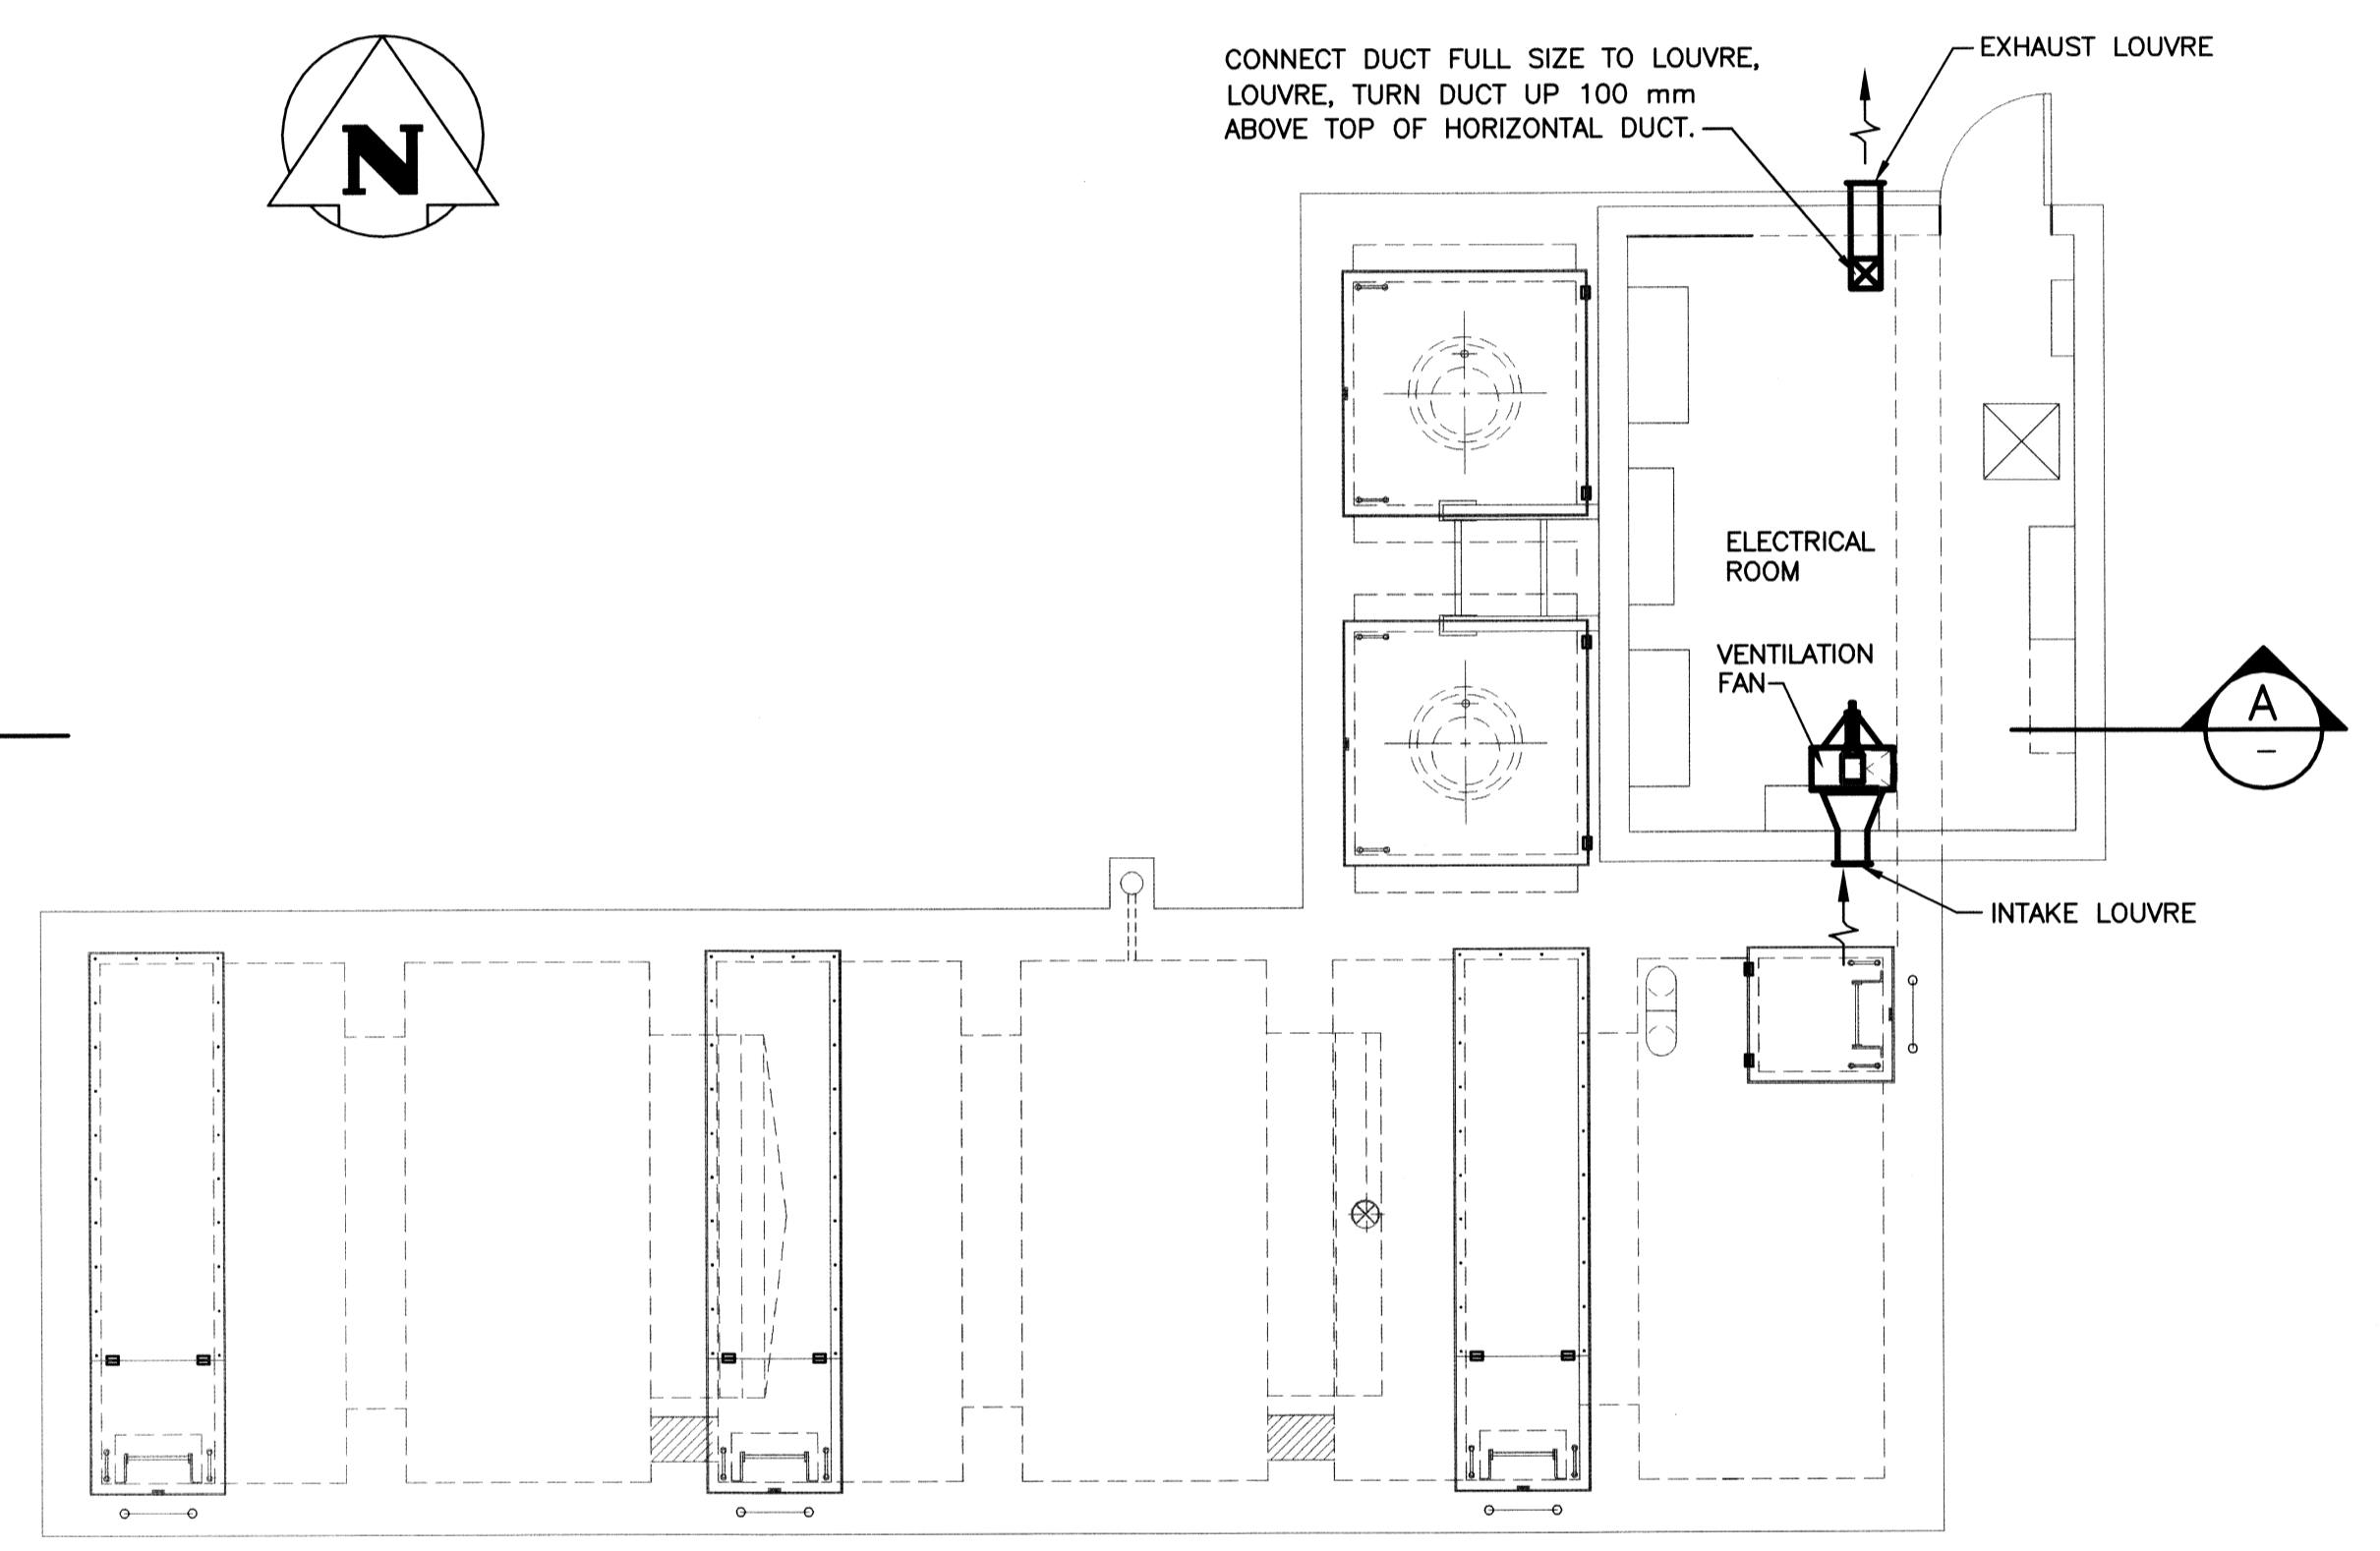

- GENERAL NOTES:**
1. PROVIDE DUCT FROM LOUVRE TO VENTILATION FAN. SEAL DUCTWORK WATERTIGHT. SET FAN TO DISCHARGE DOWN. HANG FAN FROM ROOF FRAMING.
 2. 450mm x 300mm "E.H. PRICE" K609 HP, FIXED BLADE LOUVRE c/w BIRD SCREEN.
 3. BEFORE INSTALLING, CONFIRM AND COORDINATE EXACT HEIGHT OF VENTILATION FAN AND EXHAUST LOUVRE WITH CONTRACT ADMINISTRATOR.
 4. PROVIDE SHEET METAL GASKETED CLOSURE PANELS THAT CAN BE EASILY FASTENED TO THE ELECTRICAL ROOM, VENTILATION FAN SUPPLY AND EXHAUST DUCT ON A SEASONAL BASIS. SUBMIT SHOP DRAWINGS FOR REVIEW.

00	05/04/07	Issued for Tender and Construction By City of Winnipeg	GCN	DDW	RED
0C	05/04/07	Issued for Review To City of Winnipeg	RED	RED	REW
0B	04/07/06	Issued with Contract C5 as Reference Only	RED	RED	JBS
0A	09/06/06	ISSUED FOR REVIEW - 90% COMPLETE			RED
NO.	DATE	REVISIONS	BY	CHKD.	APP.

KGS GROUP

SUBCONSULTANT DWG NO.:

C of A

ENG. STAMP

DESIGNED BY:	RED	DRAWN BY:	VJH	SCALE:	AS NOTED
CHECKED BY:	RED	APPROVED BY:		DATE:	

KGS GROUP SUBMITTED BY:

OWNER
MANITOBA FLOODWAY AUTHORITY

PROJECT:
RED RIVER FLOODWAY EXPANSION

PHASE:
MAIN CHANNEL CONTRACT No. C5

TITLE:
KILDARE LAND DRAINAGE FLOOD PUMPING STATION MECHANICAL WORKS PUMPS AND VENTILATION PLAN AND SECTION

MFA acceptance:

DOUG McNEIL VICE PRESIDENT OF ENGINEERING AND CONSTRUCTION	OWNER DWG NO.:	CC5-48aM-001c	SHT.	01	REV.	00
---	----------------	---------------	------	----	------	----

CITY OF WINNIPEG IS RESPONSIBLE FOR MECHANICAL AND ELECTRICAL WORK
MFA acceptance is limited to the Red River Floodway Expansion project only, and specifically excludes acceptance of any mechanical and electrical works indicated on this drawing, which are incorporated for the purpose of City of Winnipeg Bid Opportunity 238-2007

THE CITY OF WINNIPEG WATER & WASTE DEPARTMENT

CAD FILE DRAWING NUMBER: CC5-48aM-001c-01-00.dwg

CITY DRAWING NUMBER: -

