




1 PLAN - ELECTRICAL RM  
1c SCALE: 1:40

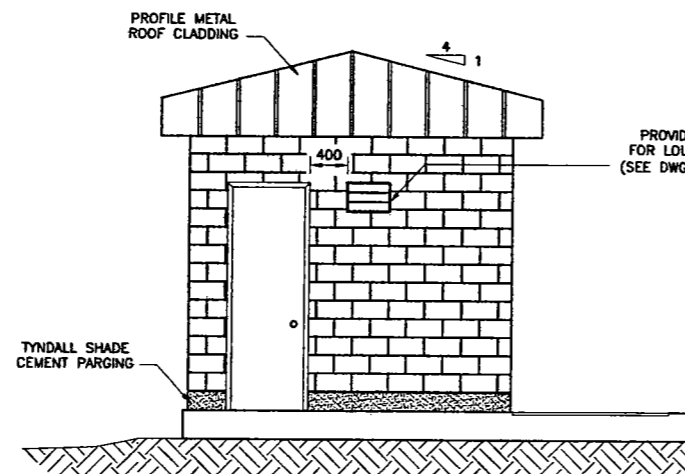


NORTH ELEVATION  
SCALE: 1:40

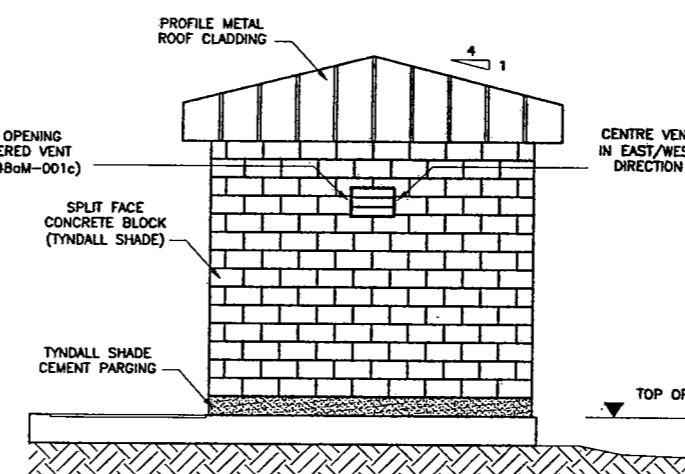


SOUTH ELEVATION  
SCALE: 1:40

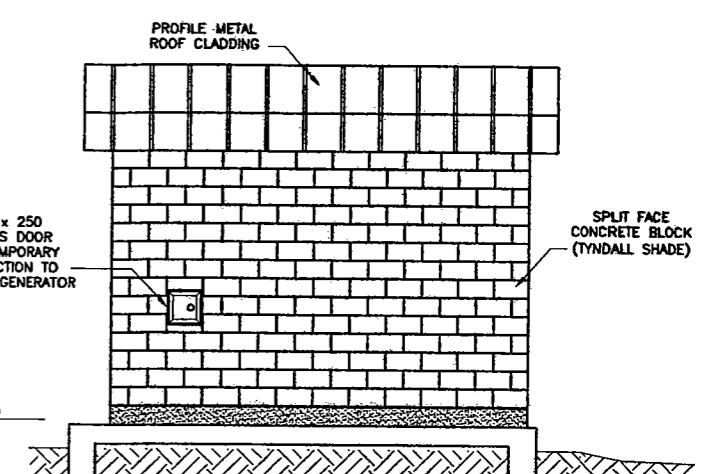


EAST ELEVATION  
SCALE: 1:40

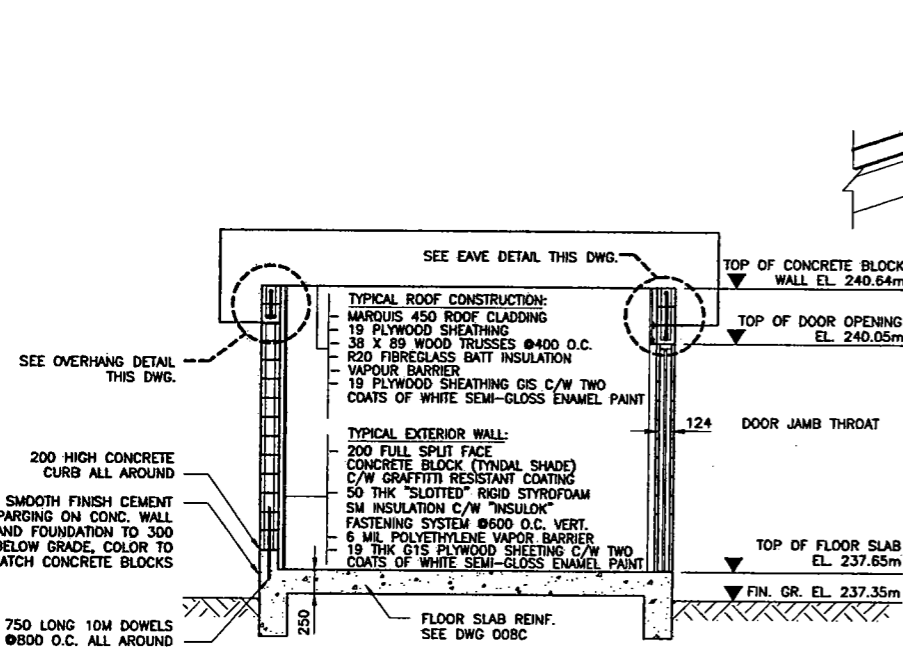

SECTION A-A  
SCALE: 1:40

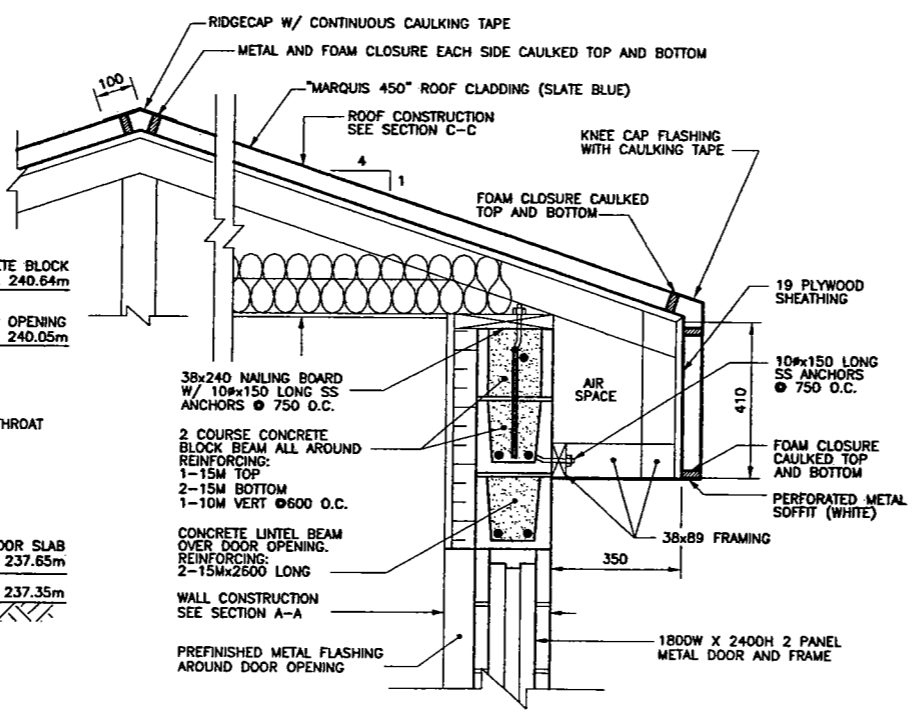


EAVE DETAIL  
SCALE: 1:10

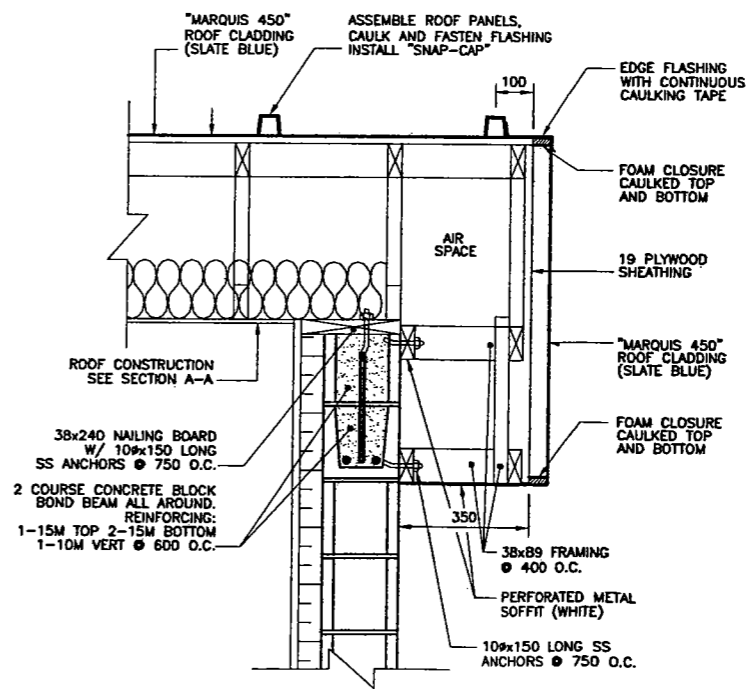

OVERHANG DETAIL  
SCALE: 1:10

 1. REFER TO DRAWING 48aS-001c FOR GENERAL NOTES.



00	04/07/06	ISSUED FOR TENDER AND CONSTRUCTION	TF	CMS/JBS
NO.	DATE	REVISIONS	BY	CHKD./APP.

**KGS GROUP**  
SUBCONSULTANT DWG NO.:

C of A

ENG. STAMP  
C.M. SIEPMAN  
Member  
20613

DESIGNED BY:	TF	DRAWN BY:	EC	SCALE:	AS NOTED
CHECKED BY:	CMS	APPROVED BY:	J B SMITH	DATE:	MAY 2006
KGS GROUP SUBMITTED BY: RICK CARSON					

OWNER  
**MANITOBA FLOODWAY AUTHORITY**

PROJECT:  
RED RIVER FLOODWAY EXPANSION

PHASE:  
MAIN CHANNEL CONTRACT No. C5

TITLE:  
KILDARE LAND DRAINAGE FLOOD PUMPING STATION  
STRUCTURAL WORKS  
ELECTRICAL ROOM  
PLAN, SECTION, ELEVATIONS & DETAILS

RELEASED FOR CONSTRUCTION:

DOUG McNEIL  
VICE PRESIDENT OF ENGINEERING AND CONSTRUCTION

OWNER DWG NO.:	CC5-48aS-015c	SHT.	01	REV.	00
----------------	---------------	------	----	------	----



24x36 // E09-0114 // P:\Projects\2005-05-0107-17\Civil\Drawings\REVISED\005-015c-01-00.dwg - Tab: S15 - Apr 05, 2007 - 3:59pm - User: jgnitzinger